




NATIONAL CENTRE OF EXCELLENCE IN FOOTBALL @RAJRAHAT, KOLKATA

TENDER DRAWINGS-PHASE 1

- ARCHITECTURAL
- STRUCTURE
- MEP

TENDER DRAWINGS LIST-01		
SR. NO.	DRAWINGS	DRAWING NO
ARCHITECTURAL PACKAGE		
SR. NO.	DRAWINGS	DRAWING NO
SITE		
1	SITE SURVEY PLAN	TD.A.0.01
2	SITE DEVELOPMENT LAYOUT	TD.A.0.02
3	COMPOUND WALL-SITE PLAN	TD.A.4.01
4	COMPOUND WALL-TYPICAL SECTION & ELEVATION (SOUTH, EAST & WEST SIDE)	TD.A.4.02
5	COMPOUND WALL-TYPICAL SECTION & ELEVATION (NORTH SIDE)	TD.A.4.03
STRUCTURAL PACKAGE		
6	COMPOUND WALL DETAILS	TD.S.4.01
MEP PACKAGE		
7	STORM WATER DRAIN LAYOUT	TD.P.0.01



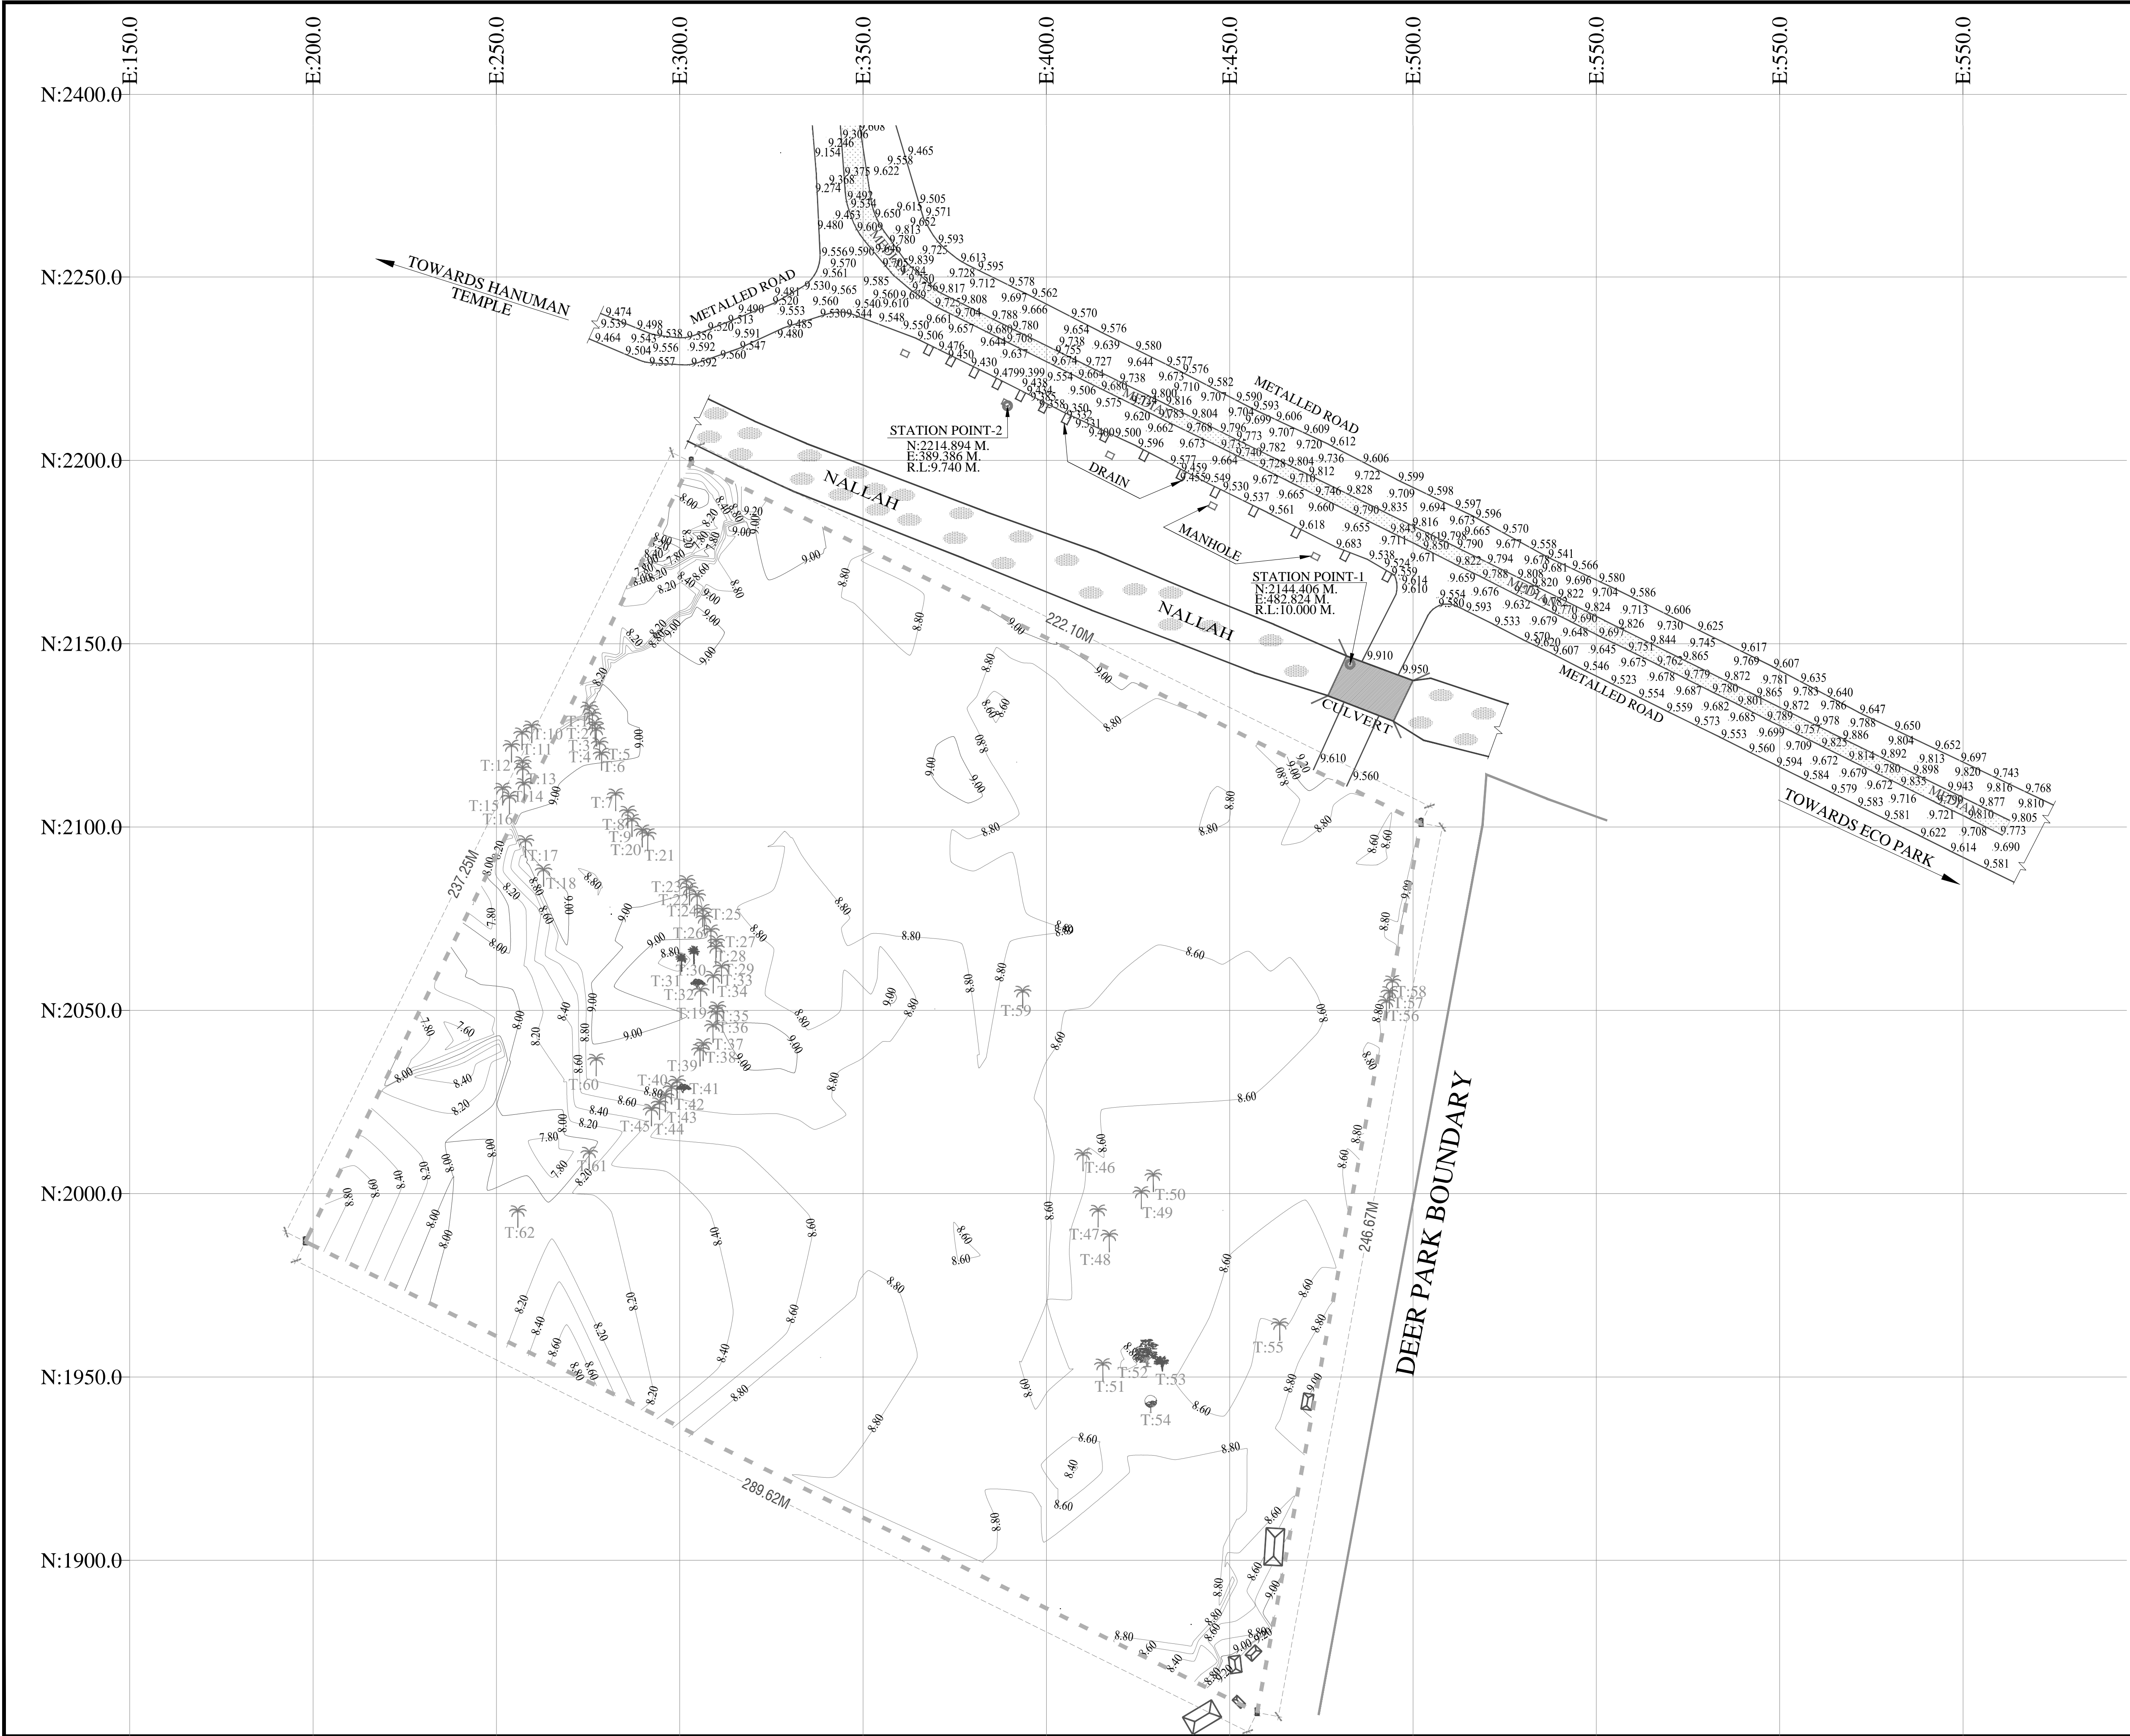

TENDER DRAWING

GENERAL NOTES

1. ALL DIMENSIONS IN MILLIMETERS AND LEVELS ARE IN METER UNLESS OTHERWISE SPECIFIED.
2. ALL DIMENSIONS ARE TO BE CHECKED AND CO-RELATED WITH THE RELEVANT ARCHITECTURAL, STRUCTURAL AND SERVICES DRAWINGS AND ANY AMBIGUITY, DISCREPANCY OR OMISSION SHALL BE BROUGHT IN TO NOTICE OF ARCHITECT PRIOR TO COMMENCEMENT OF EXECUTION.
3. DO NOT SCALE THE DRAWING, WRITTEN DIMENSION TO BE FOLLOWED.
4. THIS DRAWING TO BE READ IN CONJUNCTION WITH THE RELEVANT SERVICES AND STRUCTURAL DRAWINGS.

REVISIONS

REV	DESCRIPTION	DATE

KEY PLAN

CLIENT

ALL INDIA FOOTBALL FEDERATION

ARCHITECT

Architecture | Interiors | PMC | EPC
COLLAGE DESIGN PVT. LTD.
300 Sai Sampada, Station Rd
Vikhroli East, Mumbai - 400 083
T +91 22 2574 0844 / 45 F +91 22 2574 0846
E info@collagedesign.net
collagedesign.net

STRUCTURAL CONSULTANT

Shanghvi and Associates
Consultants Pvt. Ltd.
7th Floor, Patravali Heights,
Shradhdham Road, Vile Parle (E),
Mumbai - 400057.
Tel: +91 22 2514 4832, Fax: +91
22 2817 1804

MEP CONSULTANT

MEPCON DESIGN STUDIO


PROJECT

NATIONAL CENTRE OF EXCELLENCE
IN FOOTBALL @ RAJRAHAT, KOLKATA

DRAWING TITLE

SURVEY PLAN

DWG. NO.	REV. NO.	
TD.A.0.01	R0	
PROJECT NO.		18-P245
SCALE		NORTH
1"=ISSUED ON		
APPROVED		
CHECKED BY		
DRAWN BY		

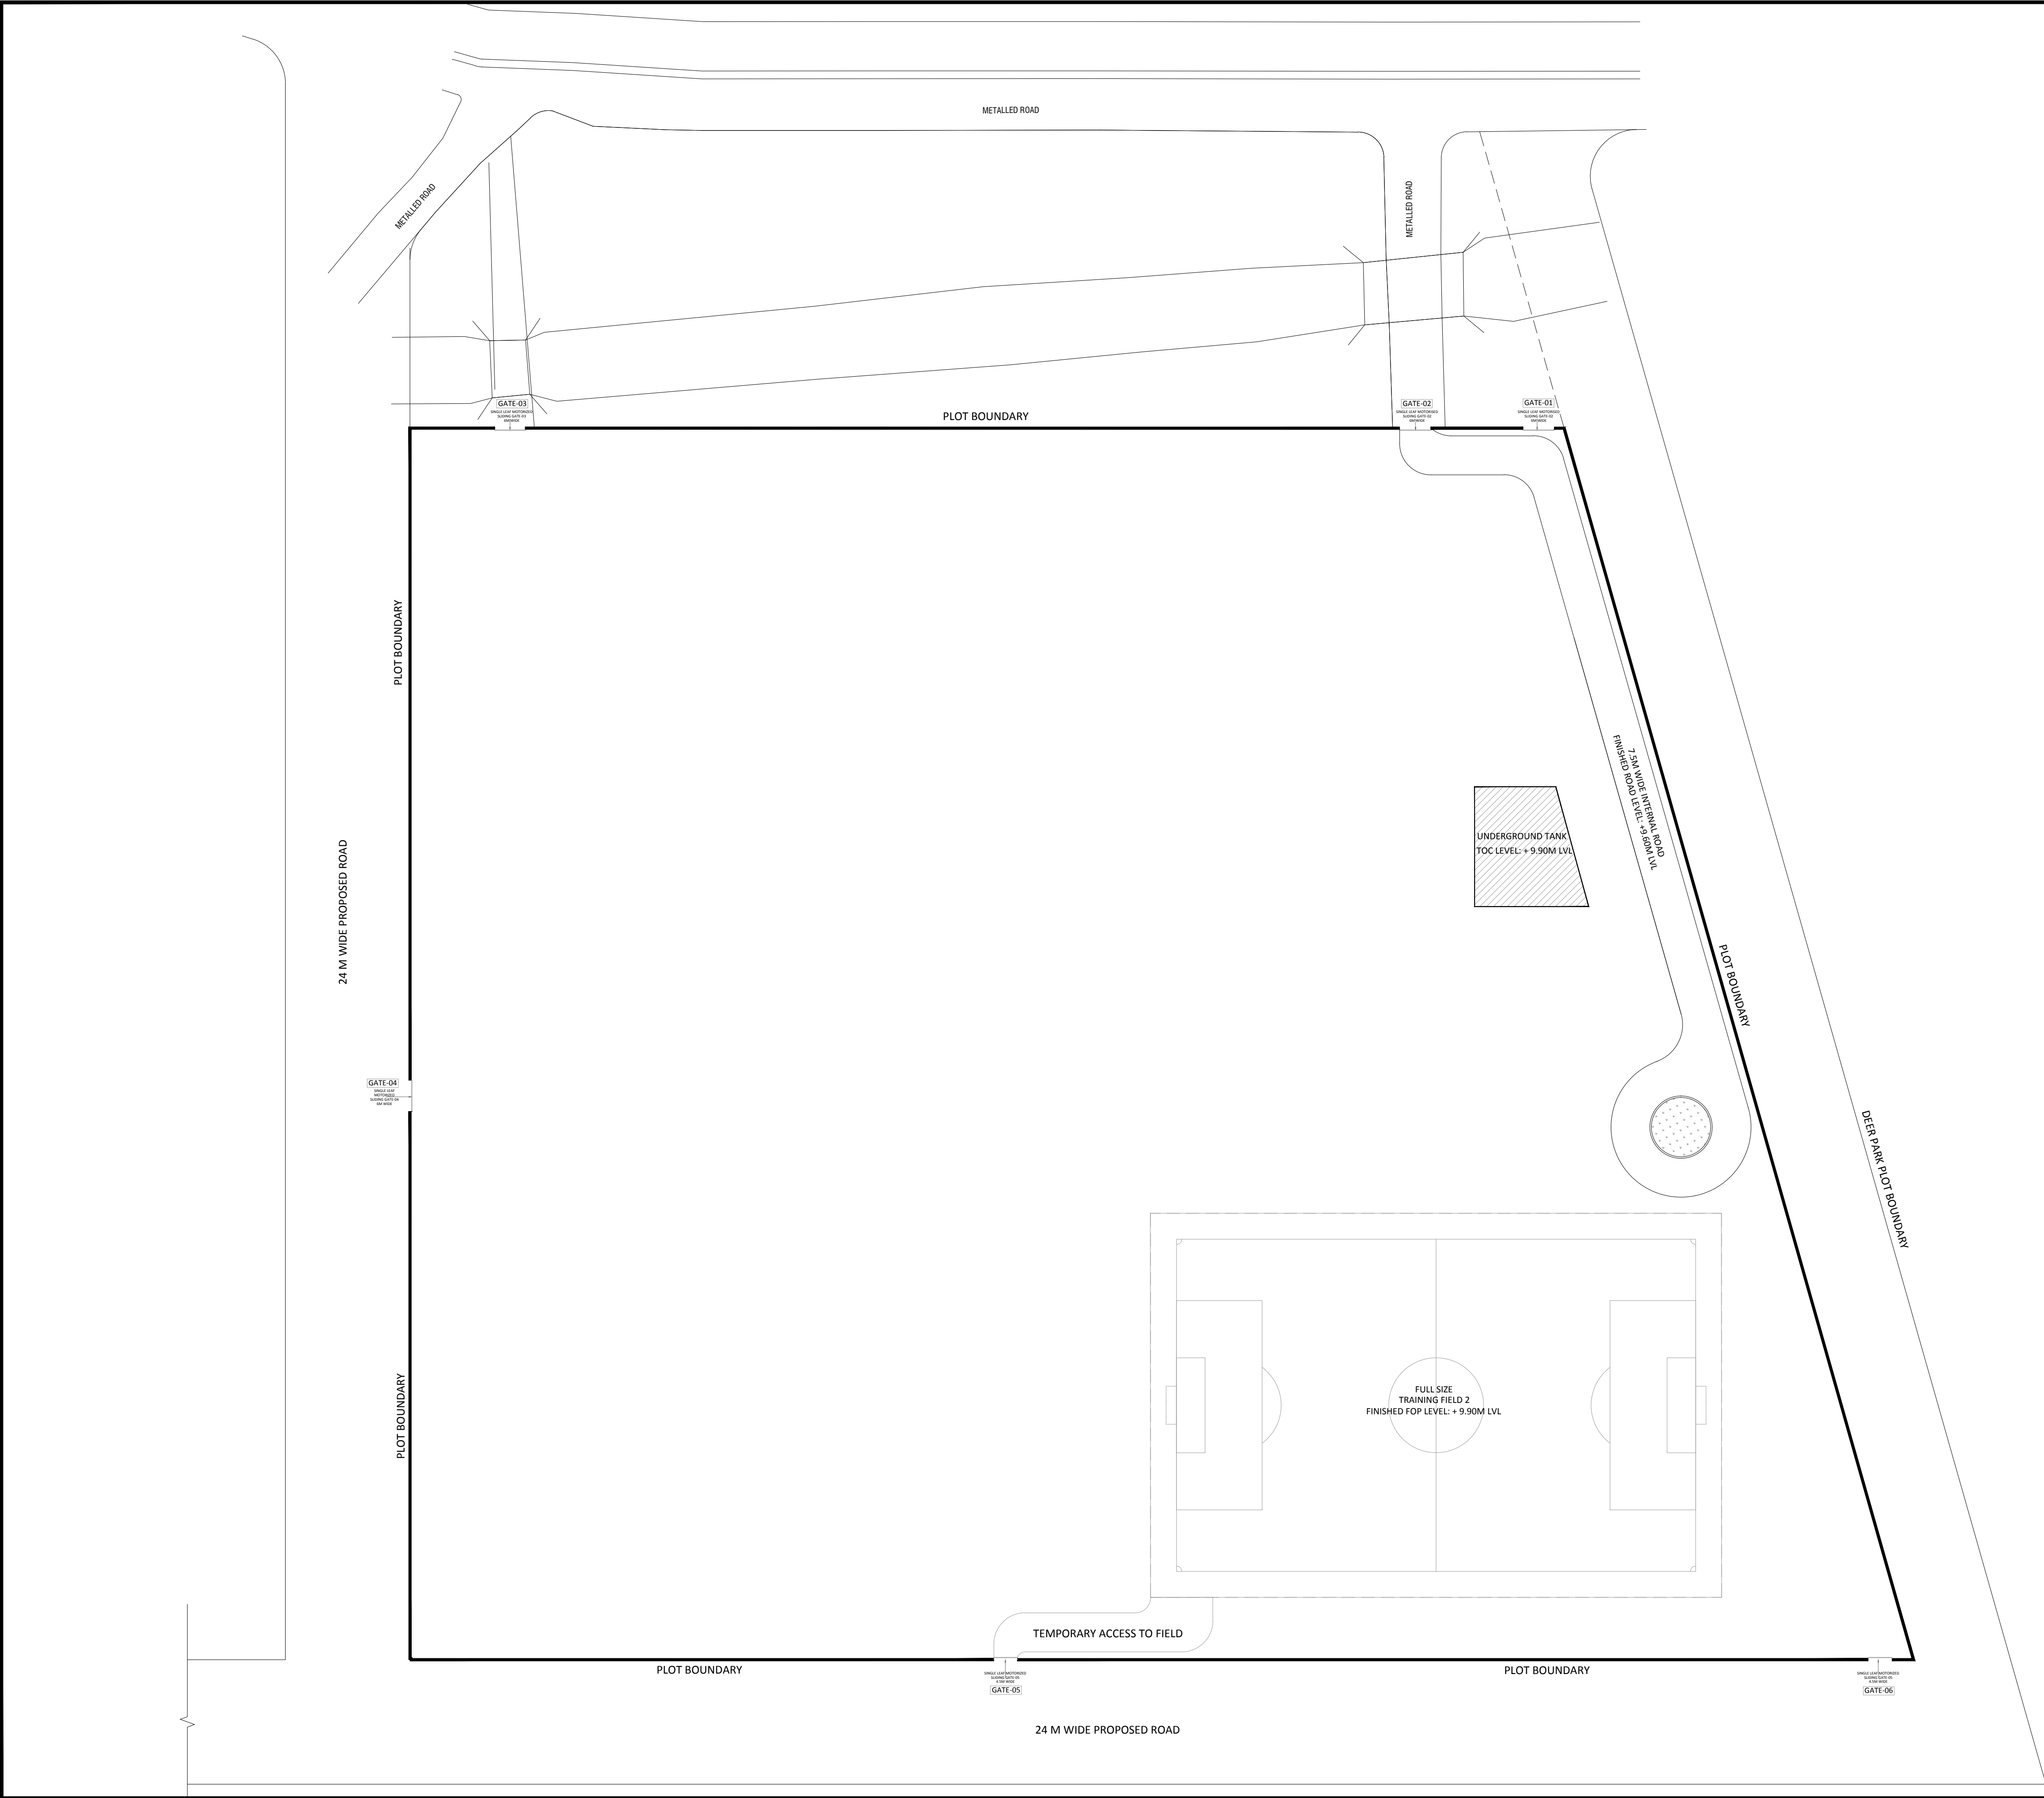


TENDER DRAWING

- GENERAL NOTES**
1. ALL DIMENSIONS ARE IN MILLIMETERS AND LEVELS ARE IN METER UNLESS OTHERWISE SPECIFIED.
 2. ALL DIMENSIONS ARE TO BE CHECKED AND CO-RELATED WITH THE RELEVANT ARCHITECTURAL, STRUCTURAL AND SERVICES DRAWINGS AND ANY AMBIGUITY, DISCREPANCY OR OMISSION SHALL BE BROUGHT IN TO NOTICE OF ARCHITECT PRIOR TO COMMENCEMENT OF EXECUTION.
 3. DO NOT SCALE THE DRAWING, WRITTEN DIMENSION TO BE FOLLOWED.
 4. THIS DRAWING TO BE READ IN CONJUNCTION WITH THE RELEVANT SERVICES AND STRUCTURAL DRAWINGS.

REVISIONS

REV	DESCRIPTION	DATE

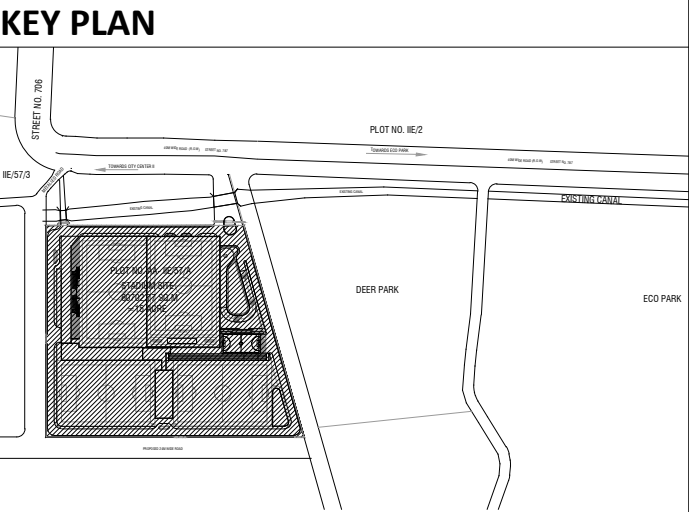

CLIENT

 **ALL INDIA FOOTBALL FEDERATION**
Football House, Sector 19, Phase 1,
Dwarka, New Delhi: 110075
Tel- 91-11-25308200/ 201
Fax- 91-11-25308234/ 25308236
Email- aiff@the-aiff.com

ARCHITECT

 **collage design**
ARCHITECTURE | INTERIORS | PMC
COLLAGE DESIGN PVT. LTD
300, Sai Sampanna, Station Rd
Vikhroli East, Mumbai 400 083
+91 22 2574 0842 / 43 / 44 / 45
www.collagedesign.net

STRUCTURAL CONSULTANT

 **SACPL**
Shanghvi and Associates
Consultants Pvt.Ltd.
7th Floor, Padmavati Heights,
Shradhdhanand Road,Vile Parle (E),
Mumbai - 400057.
Tel - +91 22 2614 4832, Fax - +91
22 2617 1804

PROJECT

NATIONAL CENTRE OF EXCELLENCE
IN FOOTBALL @ RAJRAHAT, KOLKATA

DRAWING TITLE

**SITE DEVELOPMENT LAYOUT
PHASE-1**

DWG. NO.	REV. NO.
TD.A.0.02	R0
PROJECT NO. 18-P245	
SCALE	NORTH
1 st ISSUED ON	28-09-2018
APPROVED	RS
CHECKED BY	
DRAWN BY	BD

GENERAL NOTES

- ## REVISIONS

KEY PLAN




ARCHITECT



www.collagedesign.net

STRUCTURAL CONSULTANT

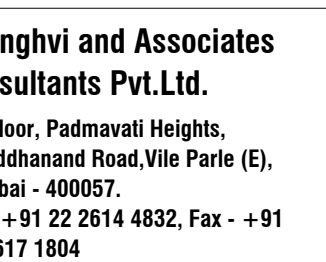

PROJECT

DRAWING TITLE

DWG. NO.

TD.A.4.01

PROJECT NO.	18-P245
-------------	---------

SCALE	1:500
-------	-------

ST ISSUED C


APPROVED


CHECKED BY _____

EV. NO.

R0

NORTH

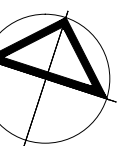

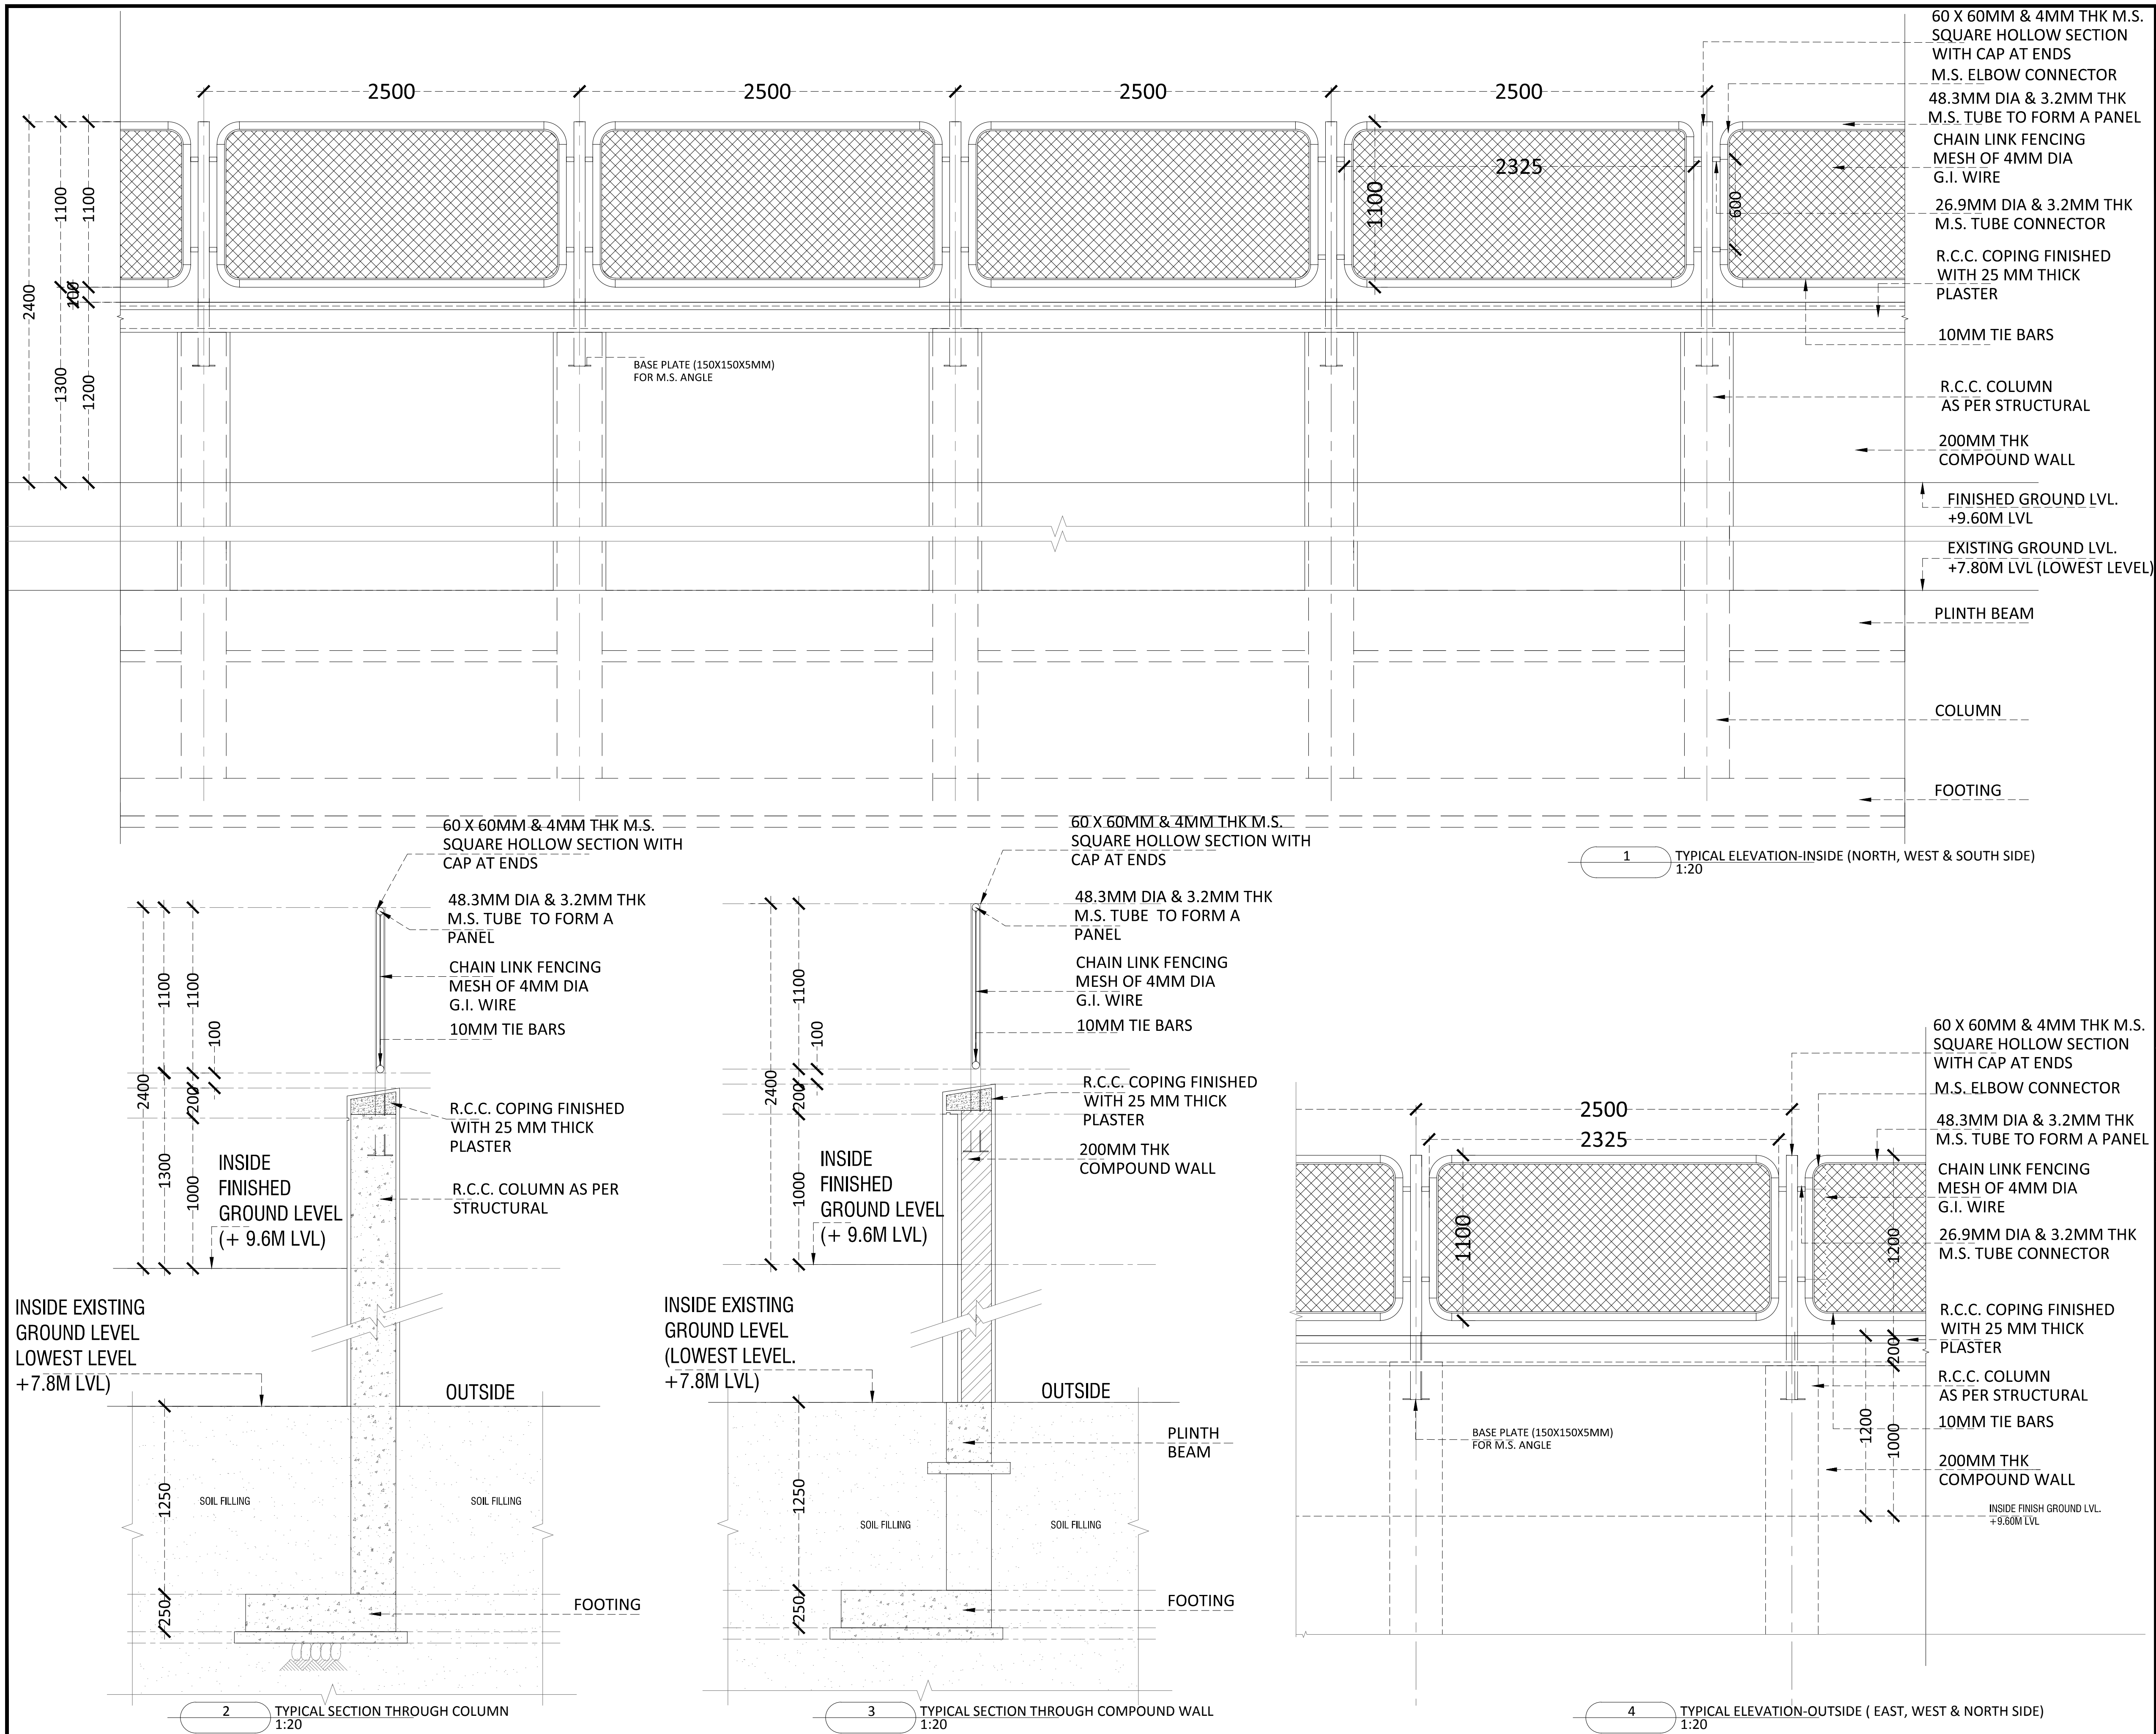

TENDER DRAWING


GENERAL NOTES

1. ALL DIMENSIONS ARE IN MILLIMETERS AND LEVELS ARE IN METER UNLESS OTHERWISE SPECIFIED.
2. ALL DIMENSIONS ARE TO BE CHECKED AND CO-RELATED WITH THE RELEVANT ARCHITECTURAL, STRUCTURAL AND SERVICES DRAWINGS AND ANY AMBIGUITY, DISCREPANCY OR OMISSION SHALL BE BROUGHT IN TO NOTICE OF ARCHITECT PRIOR TO COMMENCEMENT OF EXECUTION.
3. DO NOT SCALE THE DRAWING, WRITTEN DIMENSION TO BE FOLLOWED.
4. THIS DRAWING TO BE READ IN CONJUNCTION WITH THE RELEVANT SERVICES AND STRUCTURAL DRAWINGS.

REVISIONS

REV	DESCRIPTION	DATE

KEY PLAN

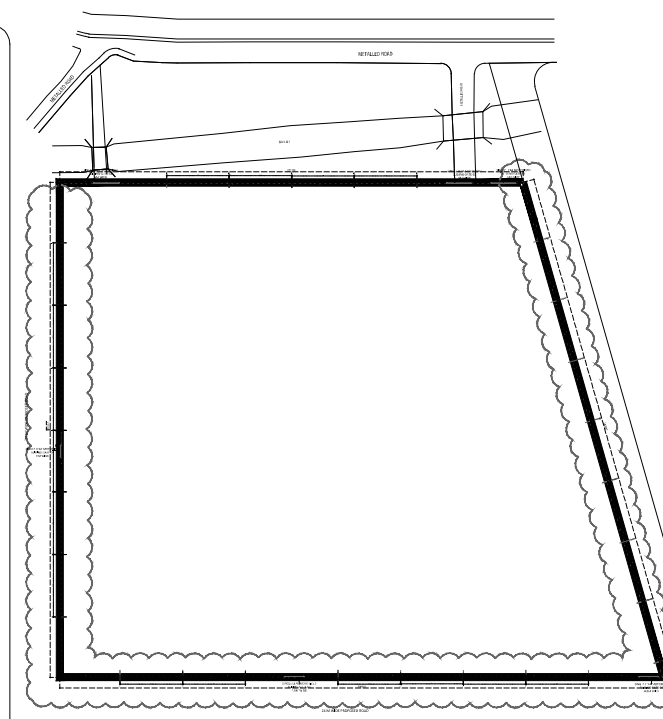

CLIENT



ARCHITECT



STRUCTURAL CONSULTANT



PROJECT

NATIONAL CENTRE OF EXCELLENCE
IN FOOTBALL @ RAJRAHAT, KOLKATA

DRAWING TITLE

COMPOUND WALL-
TYPICAL SECTION & ELEVATION
(FOR SOUTH, EAST & WEST SIDE)

DWG. NO.	REV. NO.
TD.A.4.02	R0
PROJECT NO.	18-P245
SCALE	1:20
1 st ISSUED ON	28-09-2018
APPROVED	RS
CHECKED BY	
DRAWN BY	BD


GENERAL NOTES

- ## REVISIONS

KEY PLAN



CLIENT

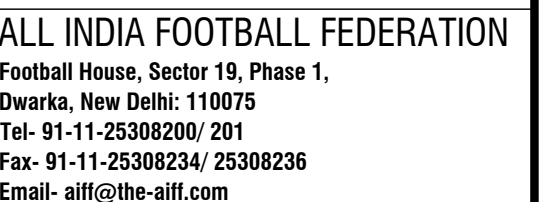

ARCHITECT



STRUCTURAL CONSULTANT



PROJECT

DRAWING TITLE
COMPOUND WALL-
TYPICAL SECTION & ELEVATION
(NORTH SIDE)

PART A - ENLARGED ELEVATION

1 NORTH ELEVATION- OUTSIDE

PART B - ENLARGED ELEVATION

2 PART A- ENLARGED ELEVATION

3 PART B- ENLARGED ELEVATION

SINGLE LEAF MOTORIZED
SLIDING GATE

M.S. FINS (50MM X 50MM X 3.6MM
THK SQUARE HOLLOW SECTION WITH
CAPS AT ENDS) EMBEDDED IN
COLUMN/ WALL.

200MM THK COMPOUND WALL

SINGLE LEAF MOTORIZED
SLIDING GATE

M.S. FINS (50MM X 50MM X 3.6MM THK SQUARE HOLLOW SECTION WITH CAPS AT ENDS) EMBEDDED IN COLUMN/ WALL.

R.C.C. COPING FINISHED
WITH 25 MM THICK
PLASTER

WALL

6 TYPICAL NORTH ELEVATION-INSIDE

INSIDE EXISTING
GROUND LEVEL
LOWEST LEVEL.
+7.8M LVL)

FILLING

OUTSIDE

SOIL FILLING

FOOTING

INSIDE EXISTING
GROUND LEVEL
(LOWEST LEVEL
+7.8M LVL)

250

OUTSIDE

FOOTING

M.S. FINS (50MM X 50MM
SQUARE HOLLOW SECTION
WITH CAP AT ENDS)
EMBEDDED IN COLUMN/
WALL.


R.C.C. COPING FINISHED
WITH 25 MM THICK
PLASTER

RCC COLUMN AS PER
STRUCTURAL

GH COLUMN


4 TYPICAL SECTION THROUGH COMPOUND WALL
1:20

5 TYPICAL SECTION THROUGH COLUMN

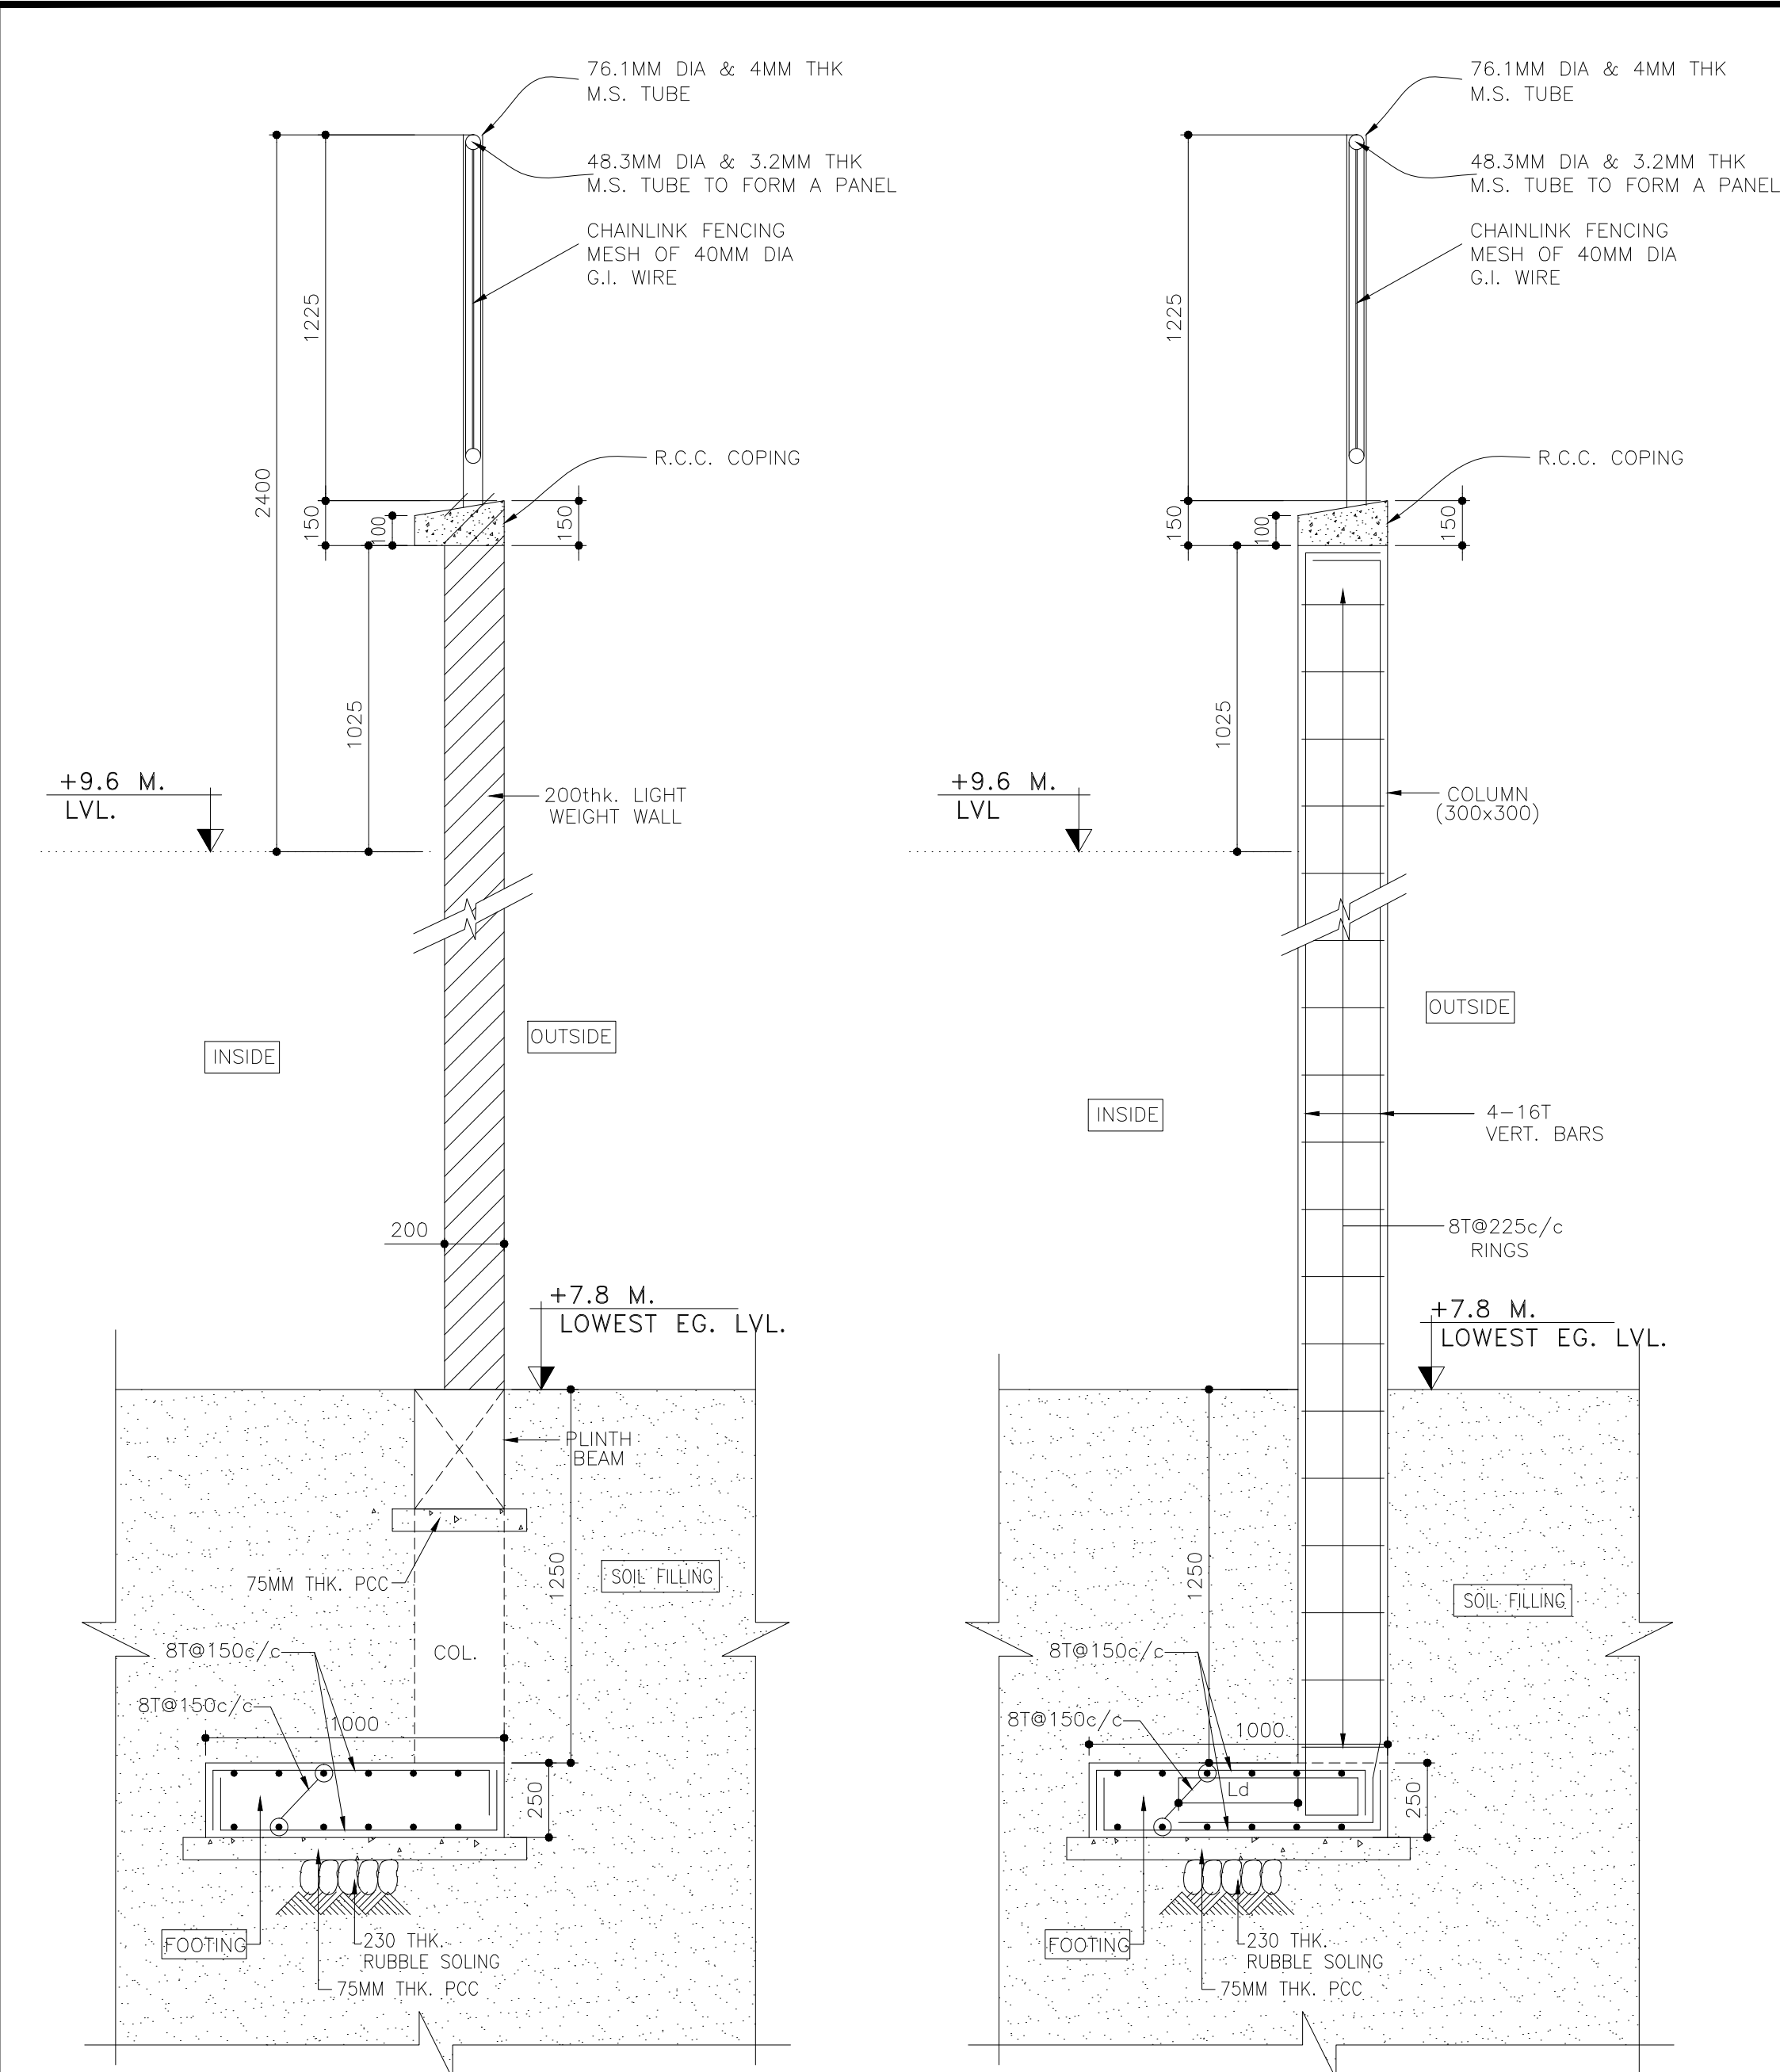


SECTION A-A
TYPICAL SECTION
THROUGH COMPOUND WALL


SECTION B-B
TYPICAL SECTION THROUGH COLUMN

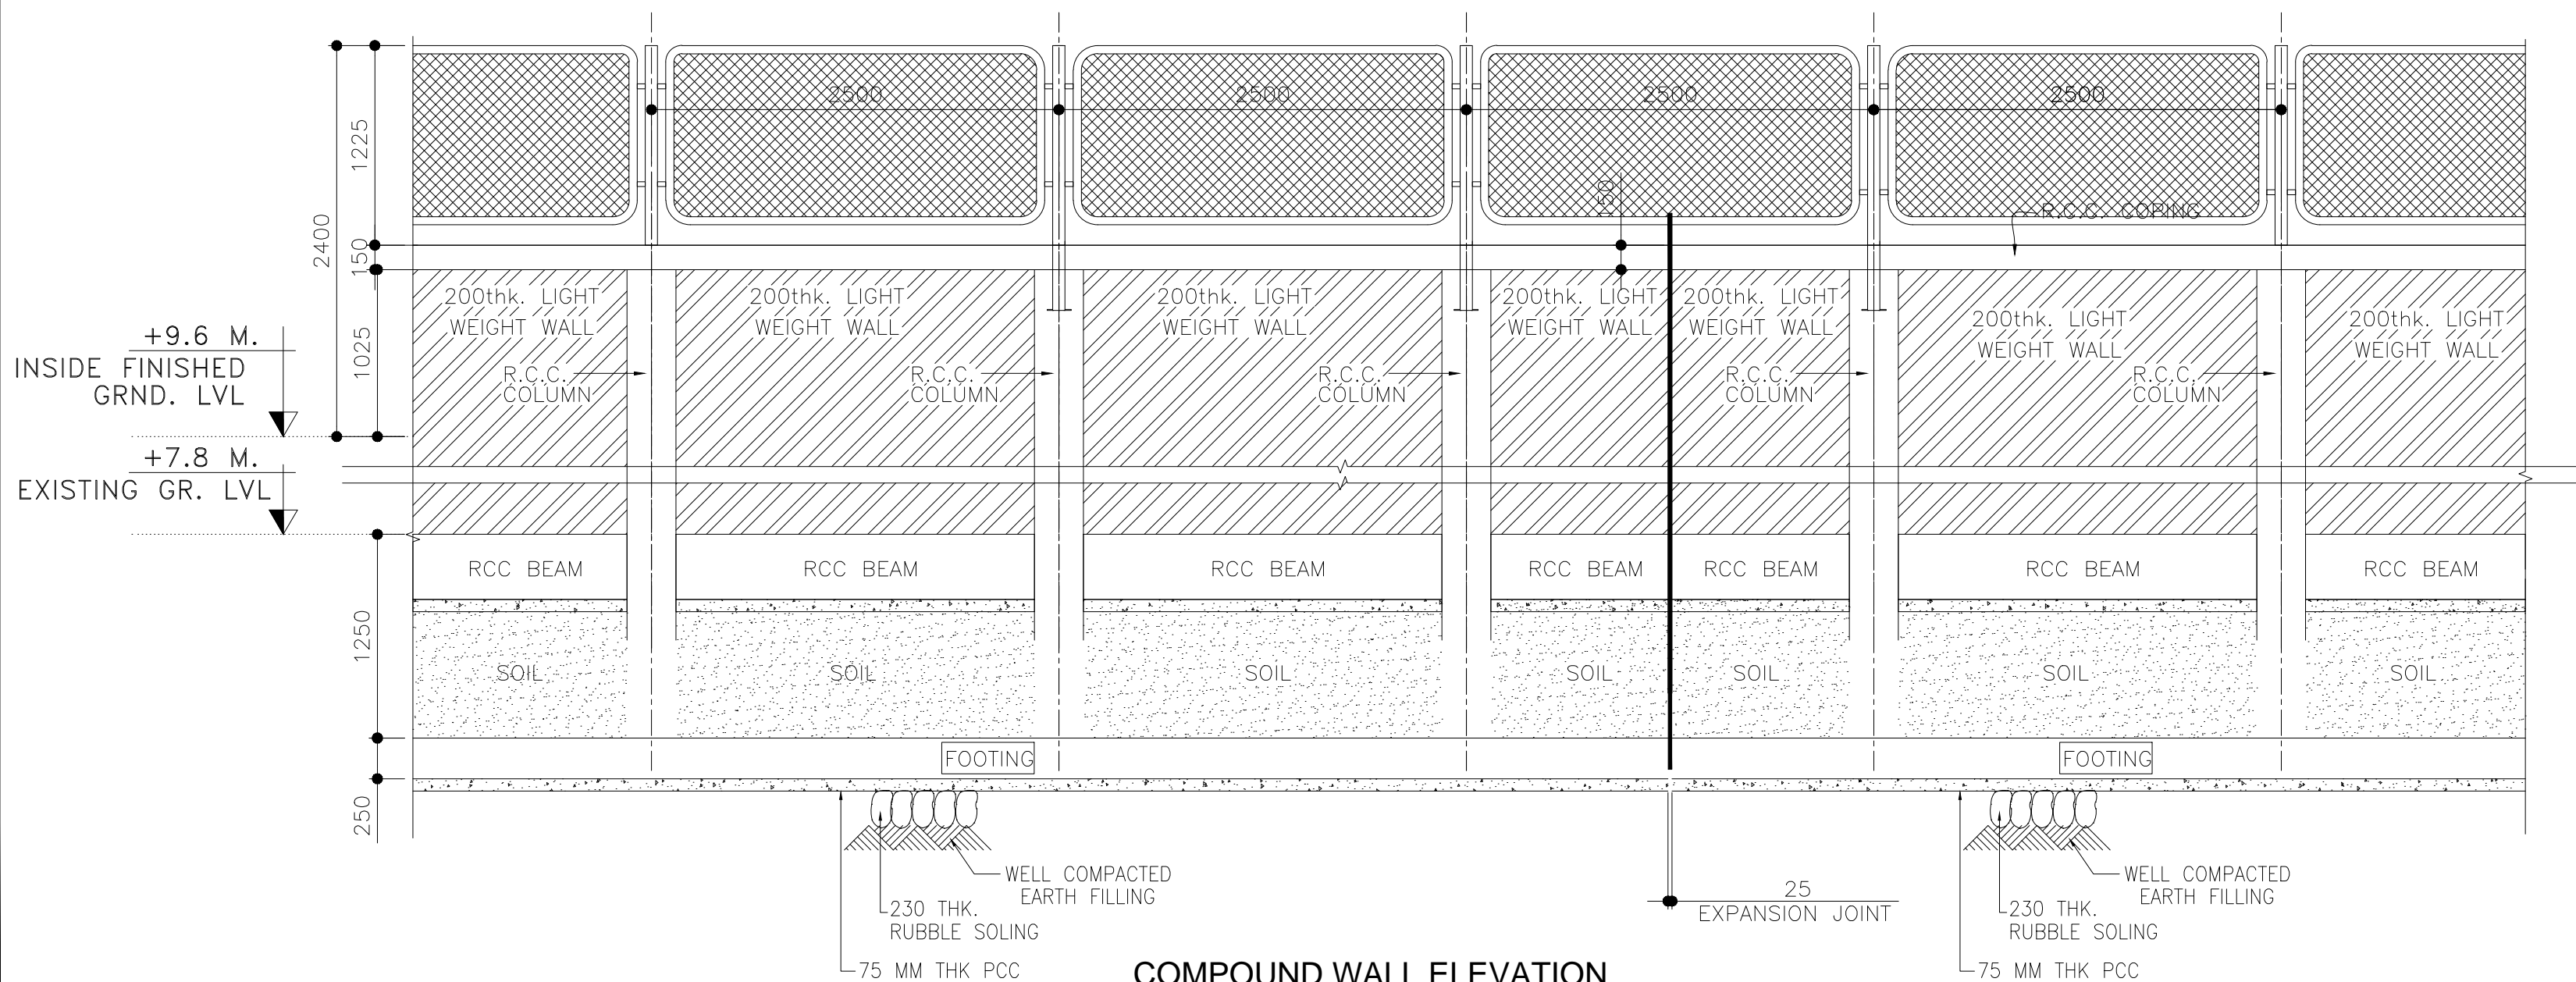


COMPOUND WALL ELEVATION

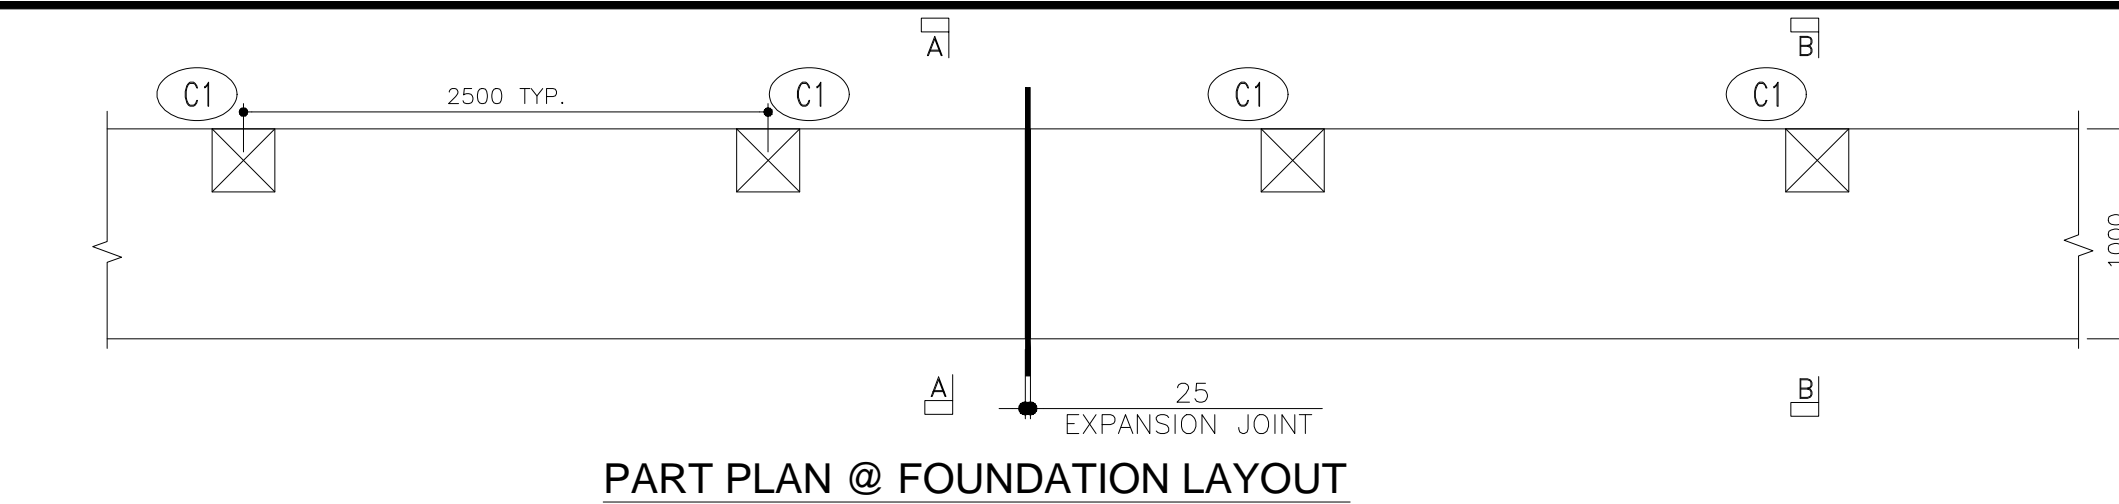





PART PLAN @ FOUNDATION LAYOUT

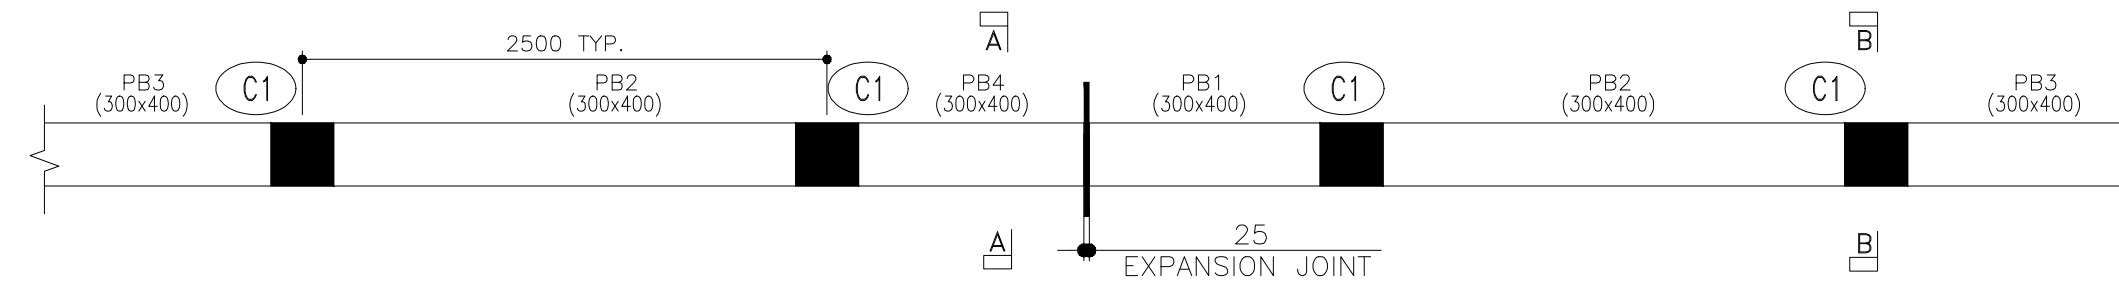

PART PLAN @ GROUND LEVEL LAYOUT

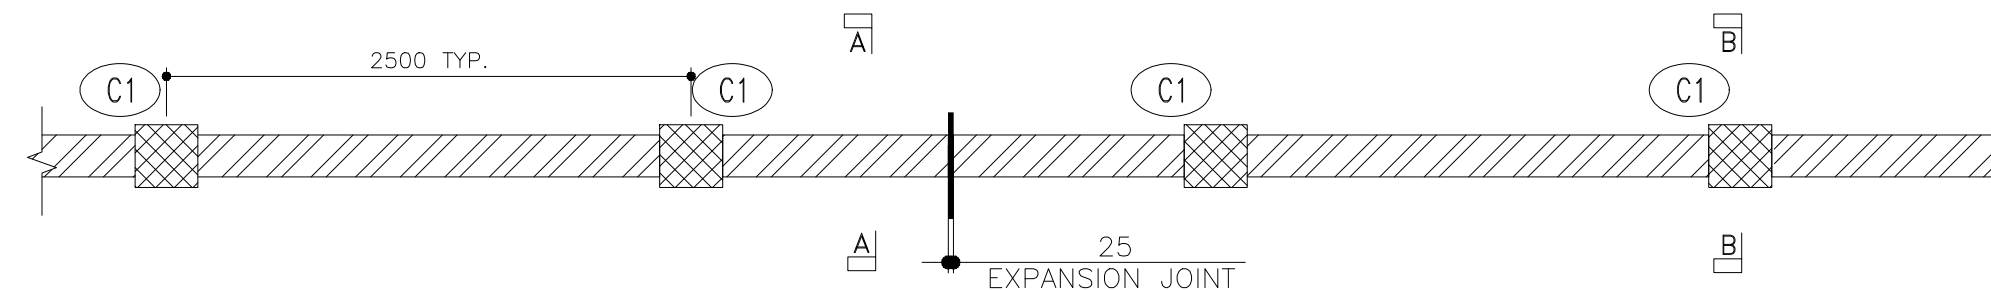

PART PLAN @ TOP OF COMPOUND WALL LAYOUT

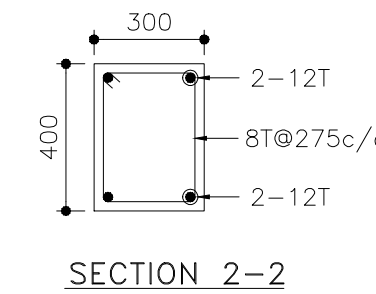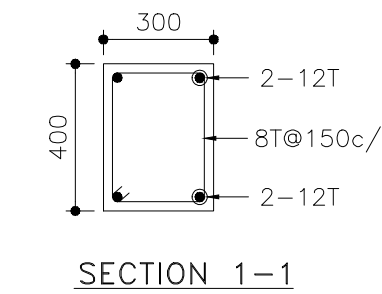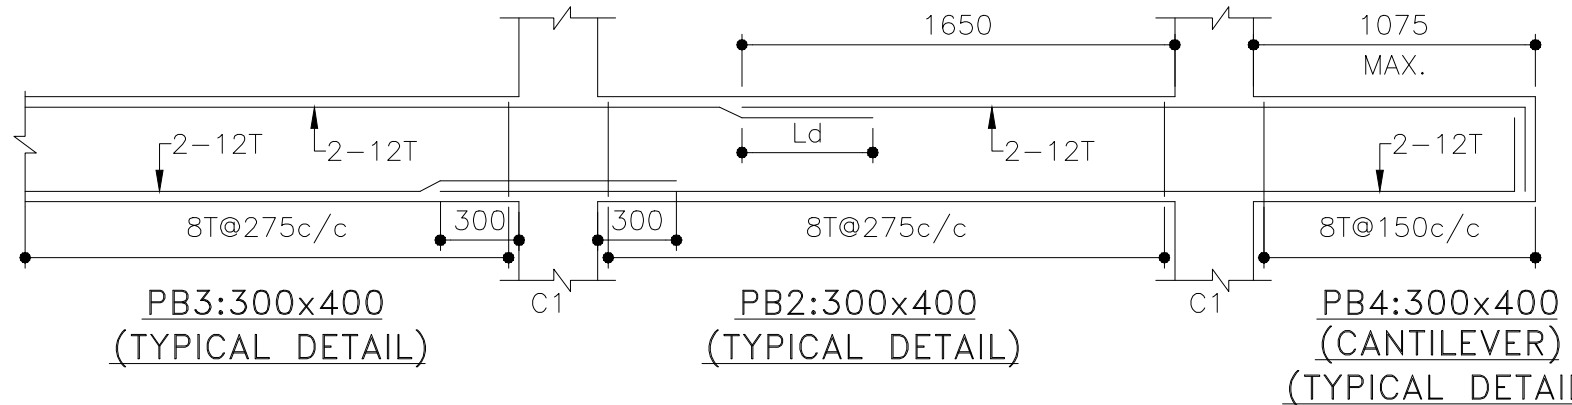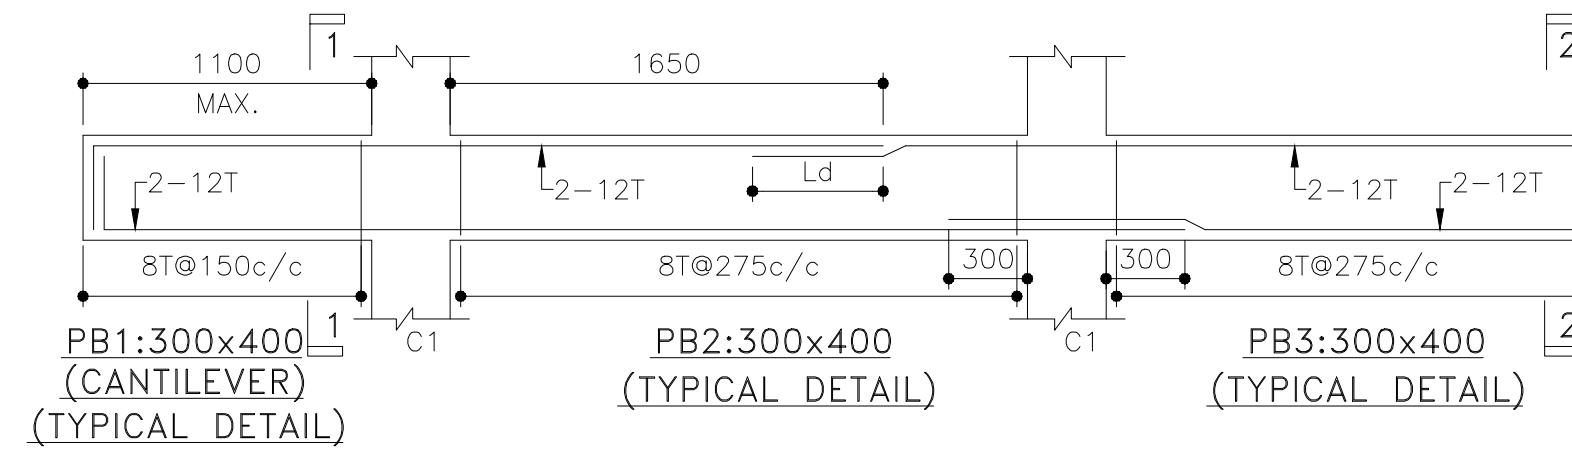

COLUMN LINK DETAIL:-

M-25	GROUND FLOOR TO BELOW GROUND FLOOR LEVEL	<p>STEEL:- 4-16T</p> <p>LINKS:- M/B = 8T@225 c/c</p>
GRADE	COLUMN NO.	C1

COMPOUND WALL DESIGN FOR NO RETENTION LOAD.

This structural drawings are based on Architectural Layout email received dated:- 15.11.2018
Architectural Section email received dated:- 20.11.2018

THIS DRG. SHOULD BE READ IN CONJUNCTION WITH DRG NO. SK-04

TENDER DRAWING

GENERAL NOTES

1. ALL DIMENSIONS ARE IN MILLIMETERS AND LEVELS ARE IN METER UNLESS OTHERWISE SPECIFIED.
2. ALL DIMENSIONS ARE TO BE CHECKED AND CO-RELATED WITH THE RELEVANT ARCHITECTURAL, STRUCTURAL AND SERVICES DRAWINGS AND ANY AMBIGUITY, DISCREPANCY OR OMISSION SHALL BE BROUGHT IN TO NOTICE OF ARCHITECT PRIOR TO COMMENCEMENT OF EXECUTION.
3. DO NOT SCALE THE DRAWING, WRITTEN DIMENSION TO BE FOLLOWED.
4. THIS DRAWING TO BE READ IN CONJUNCTION WITH THE RELEVANT SERVICES AND STRUCTURAL DRAWINGS.

REVISIONS

REV	DESCRIPTION	DATE

KEY PLAN

CLIENT

INDIA ALL INDIA FOOTBALL FEDERATION
Football House, Sector 19, Phase 1,
Dwarka, New Delhi: 110075
Tel: 91-11-25308200/ 201
Fax: 91-11-25308234/ 25308236
Email: aiff@the-aiff.com

ARCHITECT

collage design COLLAGE DESIGN PVT. LTD
300, Sai Sampanna, Station Rd
Vikhroli East, Mumbai 400 083
+91 22 2574 0842 / 43 / 44 / 45
ARCHITECTURE | INTERIORS | PMC www.collagedesign.net

STRUCTURAL CONSULTANT

SACPL Shanghi and Associates
Consultants Pvt.Ltd.
7th Floor, Padmavati Heights,
Shradhdhanand Road, Vile Parle (E),
Mumbai - 400057.
Tel - +91 22 2614 4832, Fax - +91
22 2617 1804


PROJECT

NATIONAL CENTRE OF EXCELLENCE
IN FOOTBALL @ RAJRAHAT, KOLKATA

DRAWING TITLE

COMPOUND WALL-
STRUCTURAL DETAILS

DWG. NO.	REV. NO.
TD.S.4.01	R0
PROJECT NO.	18-P245
SCALE	NORTH
1 st ISSUED ON	28-09-2018
APPROVED	
CHECKED BY	
DRAWN BY	

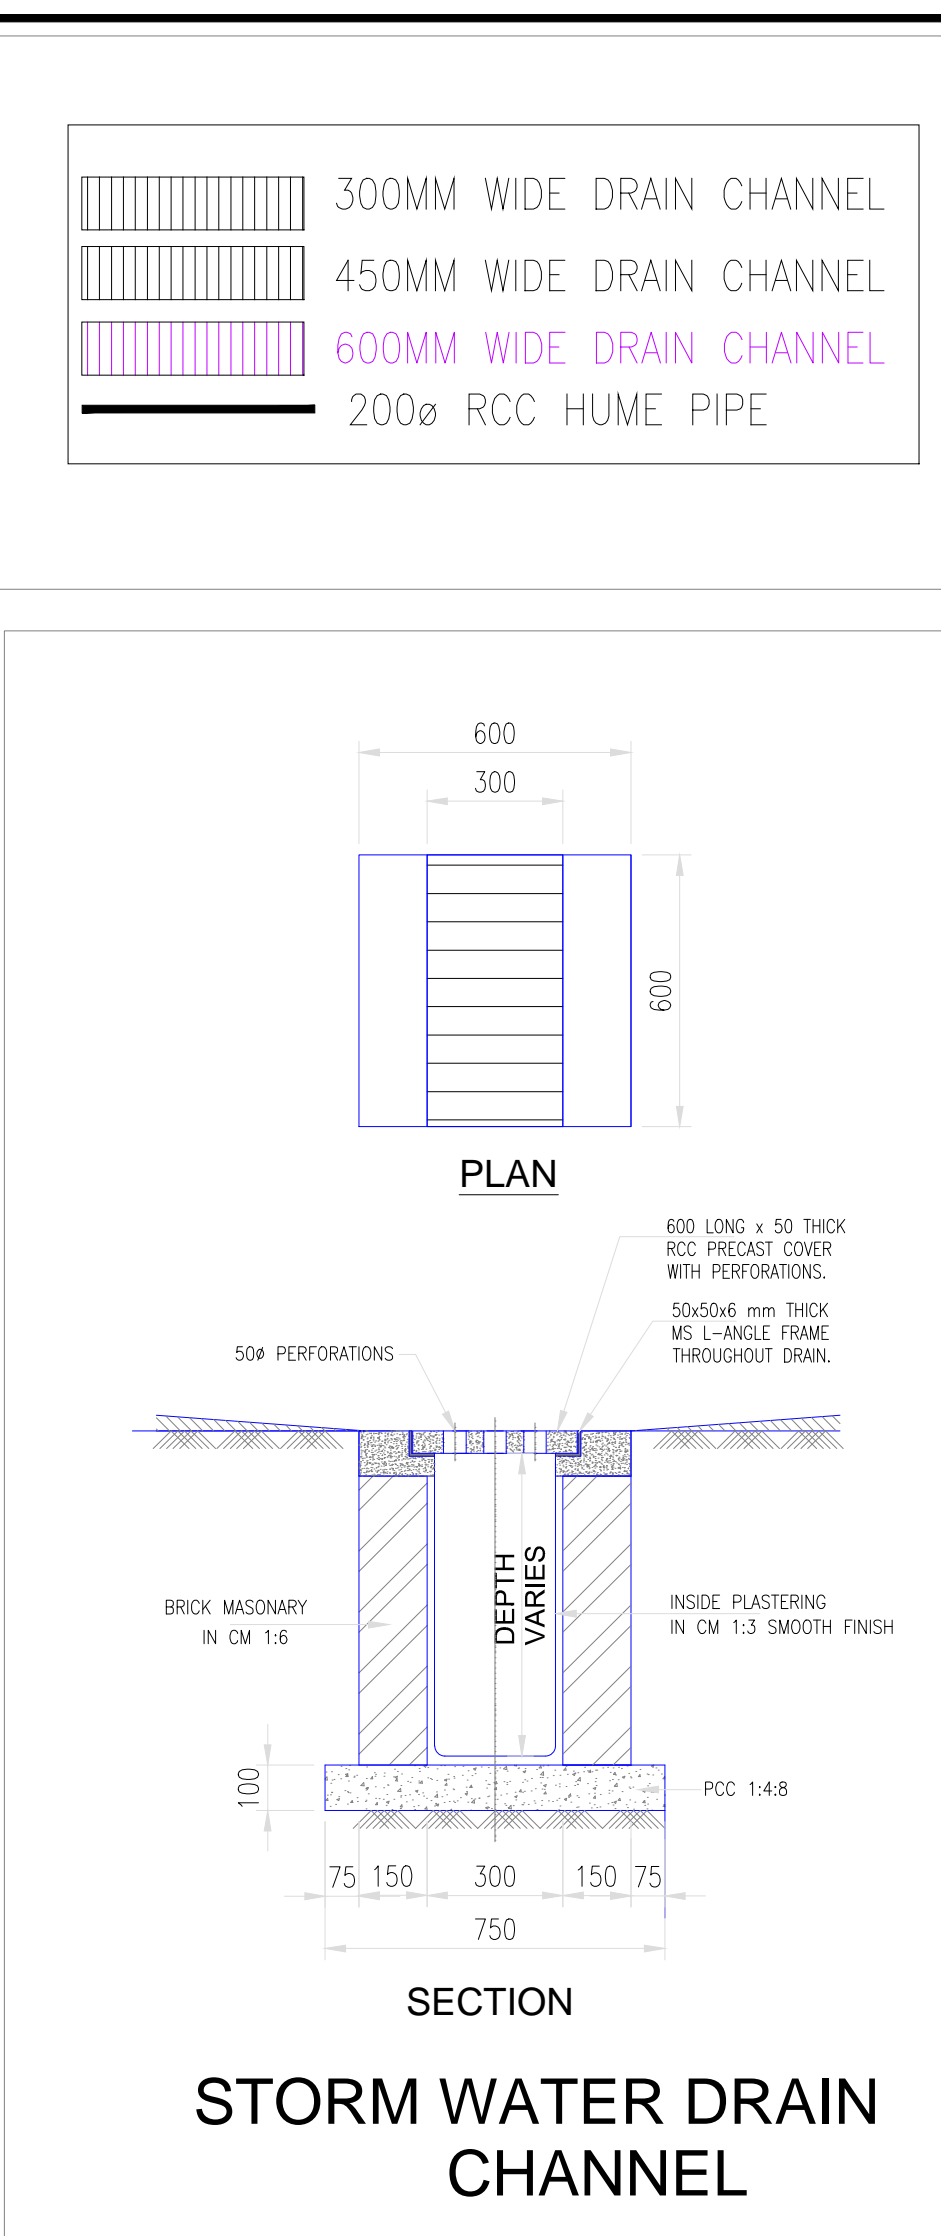

<h1>TENDER DRAWING</h1>			
GENERAL NOTES			
1. ALL DIMENSIONS ARE IN MILLIMETERS AND LEVELS ARE IN METER UNLESS OTHERWISE SPECIFIED.			
2. ALL DIMENSIONS ARE TO BE CHECKED AND CO-RELATED WITH THE RELEVANT ARCHITECTURAL, STRUCTURAL AND SERVICES DRAWINGS AND ANY AMBIGUITY, DISCREPANCY OR OMISSION SHALL BE BROUGHT IN TO NOTICE OF ARCHITECT PRIOR TO COMMENCEMENT OF EXECUTION.			
3. DO NOT SCALE THE DRAWING, WRITTEN DIMENSION TO BE FOLLOWED.			
4. THIS DRAWING TO BE READ IN CONJUNCTION WITH THE RELEVANT SERVICES AND STRUCTURAL DRAWINGS.			
REVISIONS			
REV	DESCRIPTION	DATE	
KEY PLAN			
CLIENT			
ALL INDIA FOOTBALL FEDERATION Football House, Sector 19, Phase 1, Dwarka, New Delhi: 110075 Tel: 91-11-25308200/ 201 Fax: 91-11-25308234/ 25308236 Email: aiff@the-aiff.com			
ARCHITECT			
<div style="display: flex; justify-content: space-between; align-items: center;"> <div style="text-align: center;"> ARCHITECTURE INTERIORS PMC </div> <div style="font-size: small;"> COLLAGE DESIGN PVT. LTD 300, Sai Sampanna, Station Rd Vikhroli East, Mumbai: 400 083 +91 22 2574 0842 / 43 / 44 / 45 www.collagedesign.net </div> </div>			
STRUCTURAL CONSULTANT			
<div style="display: flex; justify-content: space-between; align-items: center;"> <div style="text-align: center;"> SACPL </div> <div style="font-size: x-small;"> Shanghvi and Associates Consultants Pvt.Ltd. 7th Floor, Padmavati Heights, Shradhdhanand Road,Vile Parle (E), Mumbai - 400057. Tel : + 91 22 2614 4832, Fax : +91 22 2617 1804 </div> </div>			
PROJECT			
NATIONAL CENTRE OF EXCELLENCE IN FOOTBALL @ RAJRAHAT, KOLKATA			
DRAWING TITLE			
STORM WATER LAYOUT- PHASE 1			
DWG. NO.			REV. NO.
TD.P.0.01			RO
PROJECT NO.	SCALE		NORTH
1 st ISSUED ON	18-P245		
APPROVED	28-09-2018		
CHECKED BY			
DRAWN BY			