






NATIONAL CENTRE OF EXCELLENCE IN FOOTBALL @RAJRAHAT, KOLKATA

TENDER DRAWINGS-PHASE 1

- ARCHITECTURAL
- STRUCTURE
- MEP

TENDER DRAWINGS LIST		
SR. NO.	DRAWINGS	DRAWING NO
ARCHITECTURAL PACKAGE		
SR. NO.	DRAWINGS	DRAWING NO
SITE		
1	SITE SURVEY PLAN	TD.A.0.01
2	SITE DEVELOPMENT LAYOUT	TD.A.0.02
3	COMPOUND WALL-SITE PLAN	TD.A.3.01
4	COMPOUND WALL-TYPICAL SECTION & ELEVATION (SOUTH, EAST & WEST SIDE)	TD.A.3.02
5	COMPOUND WALL-TYPICAL SECTION & ELEVATION (NORTH SIDE)	TD.A.3.03
STRUCTURAL PACKAGE		
6	COMPOUND WALL DETAILS	TD.S.3.01
MEP PACKAGE		
7	STORM WATER DRAIN LAYOUT	TD.P.0.01

CLIENT :	ARCHITECT :	
		Architecture Interiors PMC EPC COLLAGE DESIGN PVT. LTD. 300 Sai Sampanna, Station Rd Vikhroli East, Mumbai - 400 083 T +91 22 2574 0844 / 45 F +91 22 2574 0846 E info@collagedesign.net collagedesign.net

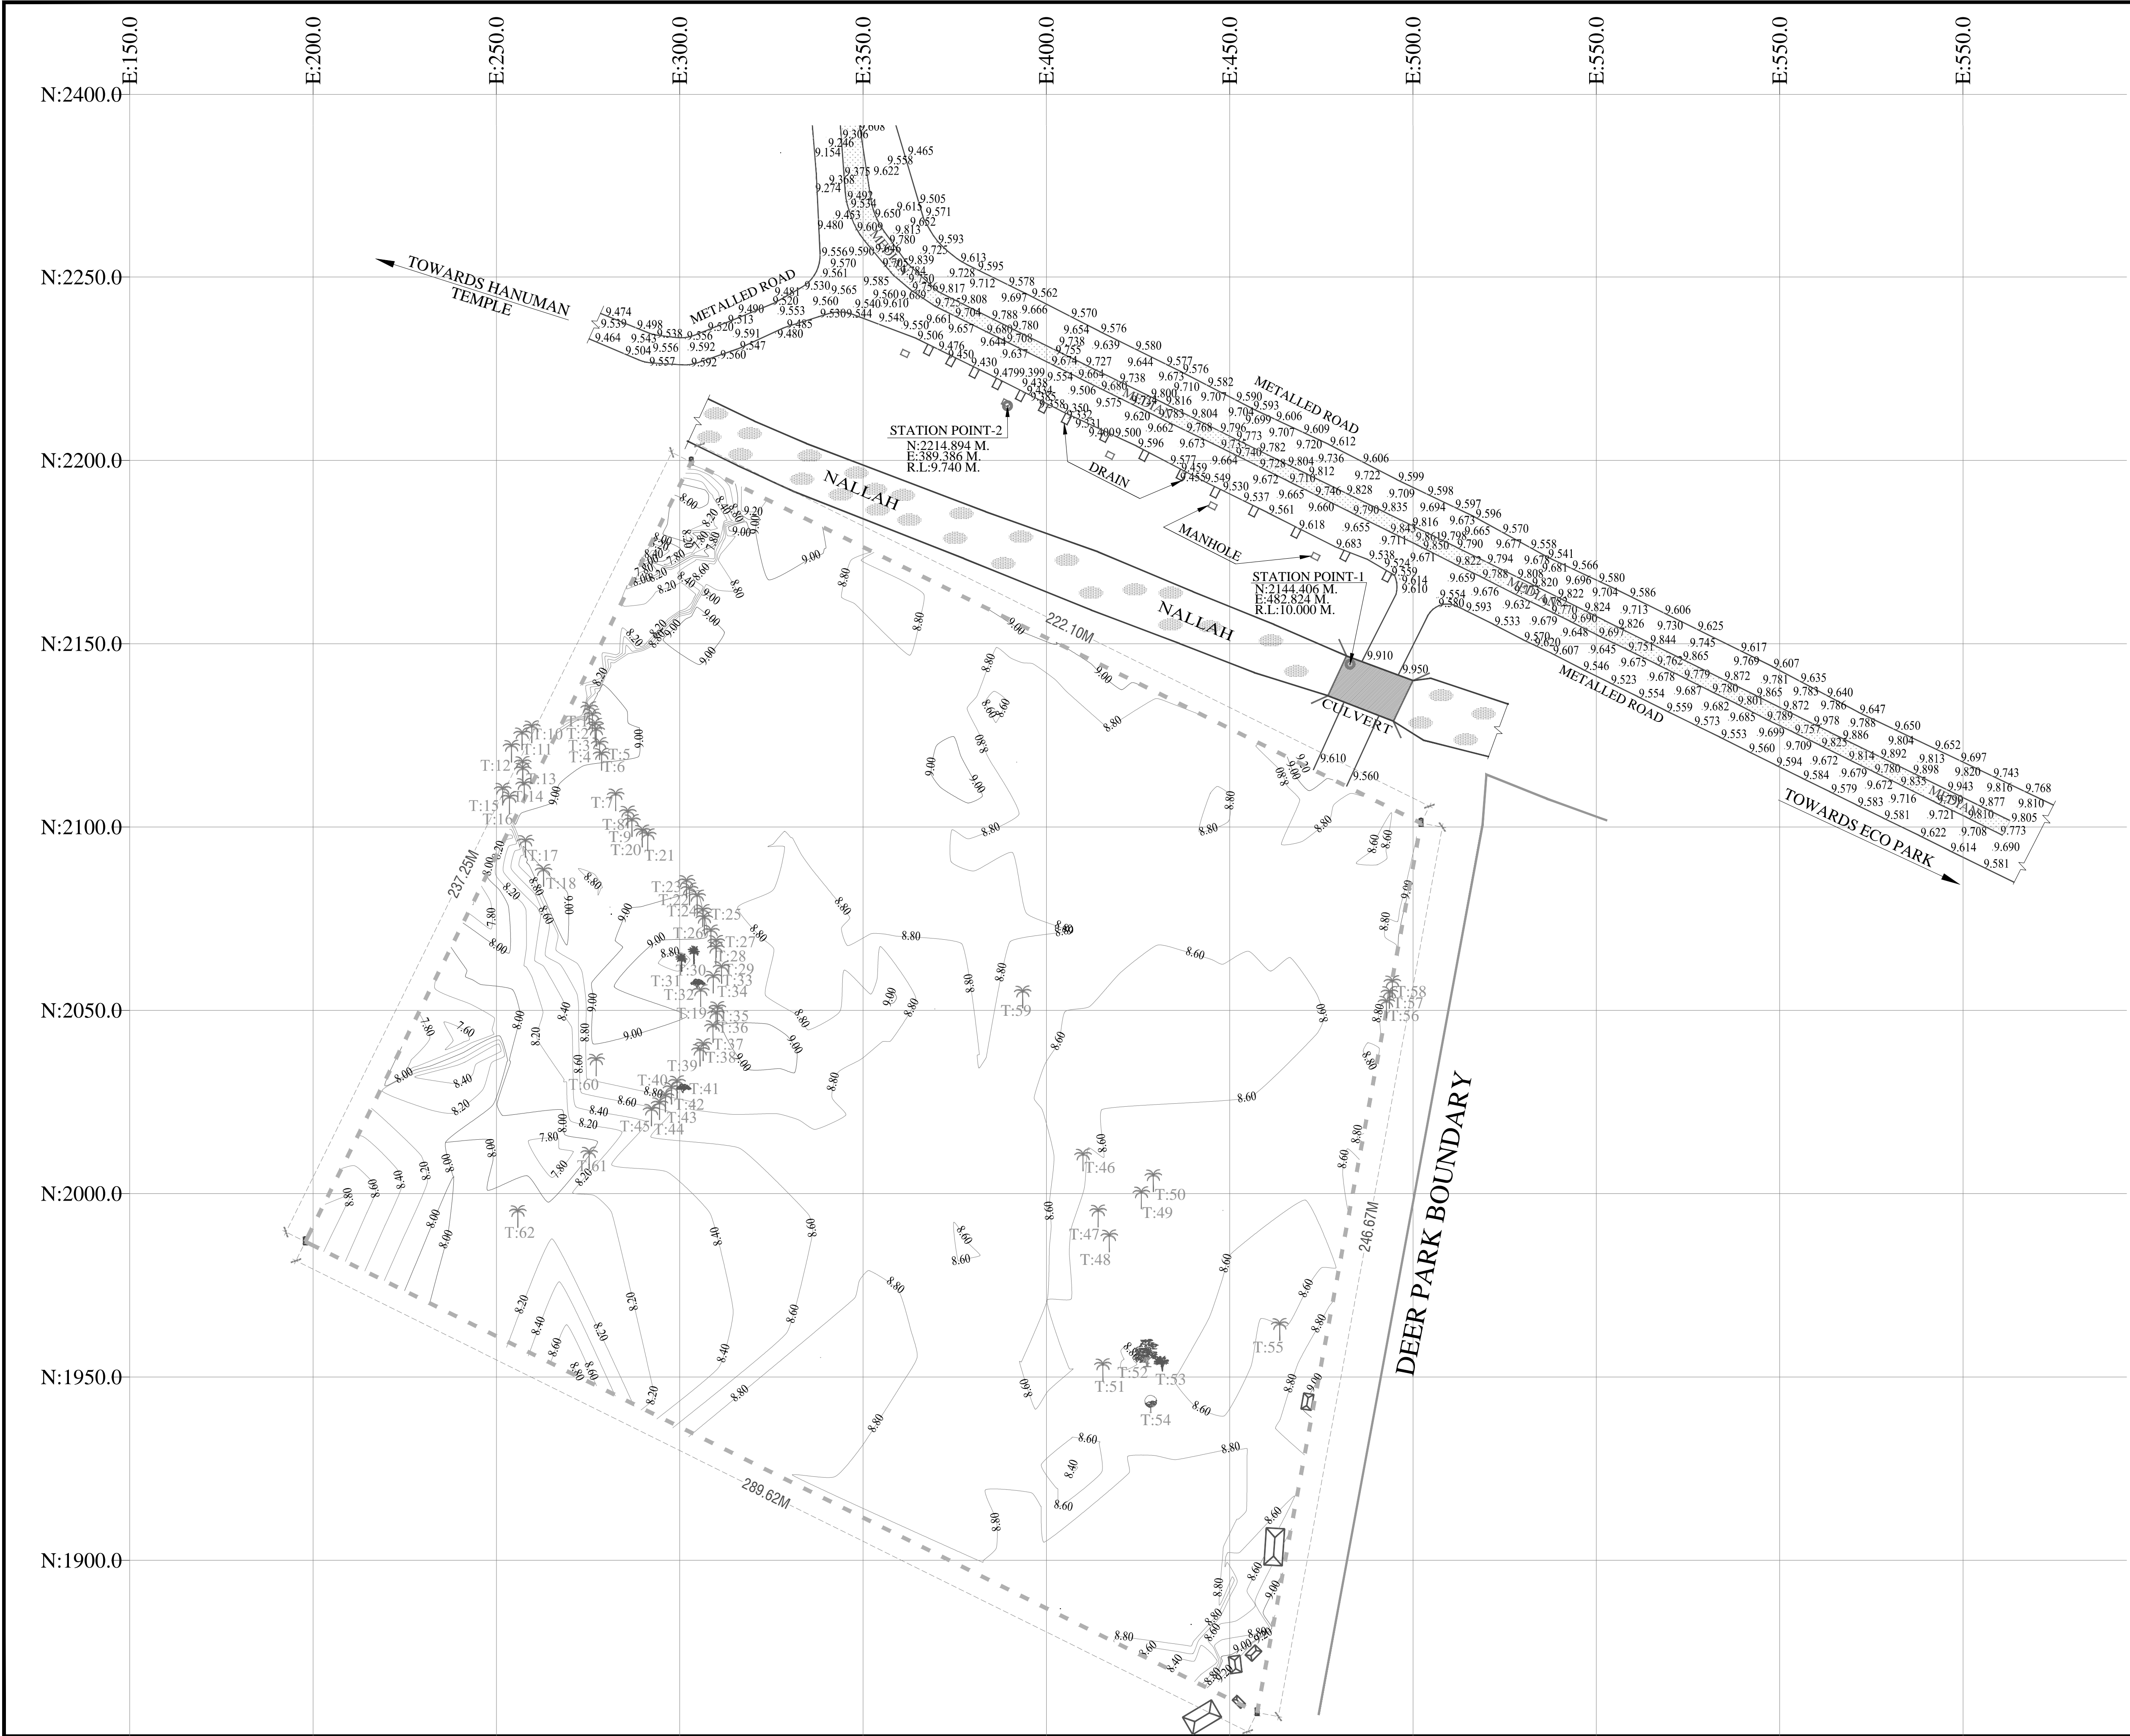

TENDER DRAWING

GENERAL NOTES

1. ALL DIMENSIONS IN MILLIMETERS AND LEVELS ARE IN METER UNLESS OTHERWISE SPECIFIED.
2. ALL DIMENSIONS ARE TO BE CHECKED AND CO-RELATED WITH THE RELEVANT ARCHITECTURAL, STRUCTURAL AND SERVICES DRAWINGS AND ANY AMBIGUITY, DISCREPANCY OR OMISSION SHALL BE BROUGHT IN TO NOTICE OF ARCHITECT PRIOR TO COMMENCEMENT OF EXECUTION.
3. DO NOT SCALE THE DRAWING, WRITTEN DIMENSION TO BE FOLLOWED.
4. THIS DRAWING TO BE READ IN CONJUNCTION WITH THE RELEVANT SERVICES AND STRUCTURAL DRAWINGS.

REVISIONS

REV	DESCRIPTION	DATE

KEY PLAN

CLIENT

ALL INDIA FOOTBALL FEDERATION

ARCHITECT

Architecture | Interiors | PMC | EPC
COLLAGE DESIGN PVT. LTD.
300 Sai Sampada, Station Rd
Vikhroli East, Mumbai - 400 083
T +91 22 2574 0844 / 45 F +91 22 2574 0846
E info@collagedesign.net
collagedesign.net

STRUCTURAL CONSULTANT

Shanghi and Associates
Consultants Pvt. Ltd.
7th Floor, Patravali Heights,
Shradhdham Road, Vile Parle (E),
Mumbai - 400057.
Tel : +91 22 2514 4832, Fax : +91
22 2817 1804

MEP CONSULTANT

MEPCON DESIGN STUDIO

PROJECT


NATIONAL CENTRE OF EXCELLENCE
IN FOOTBALL @ RAJRAHAT, KOLKATA

DRAWING TITLE

SURVEY PLAN

DWG. NO.	REV. NO.
TD.A.0.01	R0
PROJECT NO.	18-P245
SCALE	NORTH
1 st ISSUED ON	
APPROVED	
CHECKED BY	
DRAWN BY	


THIS DRAWING IS A PROPERTY OF COLLAGE DESIGN PVT. LTD. AND IS NOT TO BE REPRODUCED OR USED FOR ANY OTHER PURPOSE THAN FOR WHICH IT HAS BEEN LOANED.

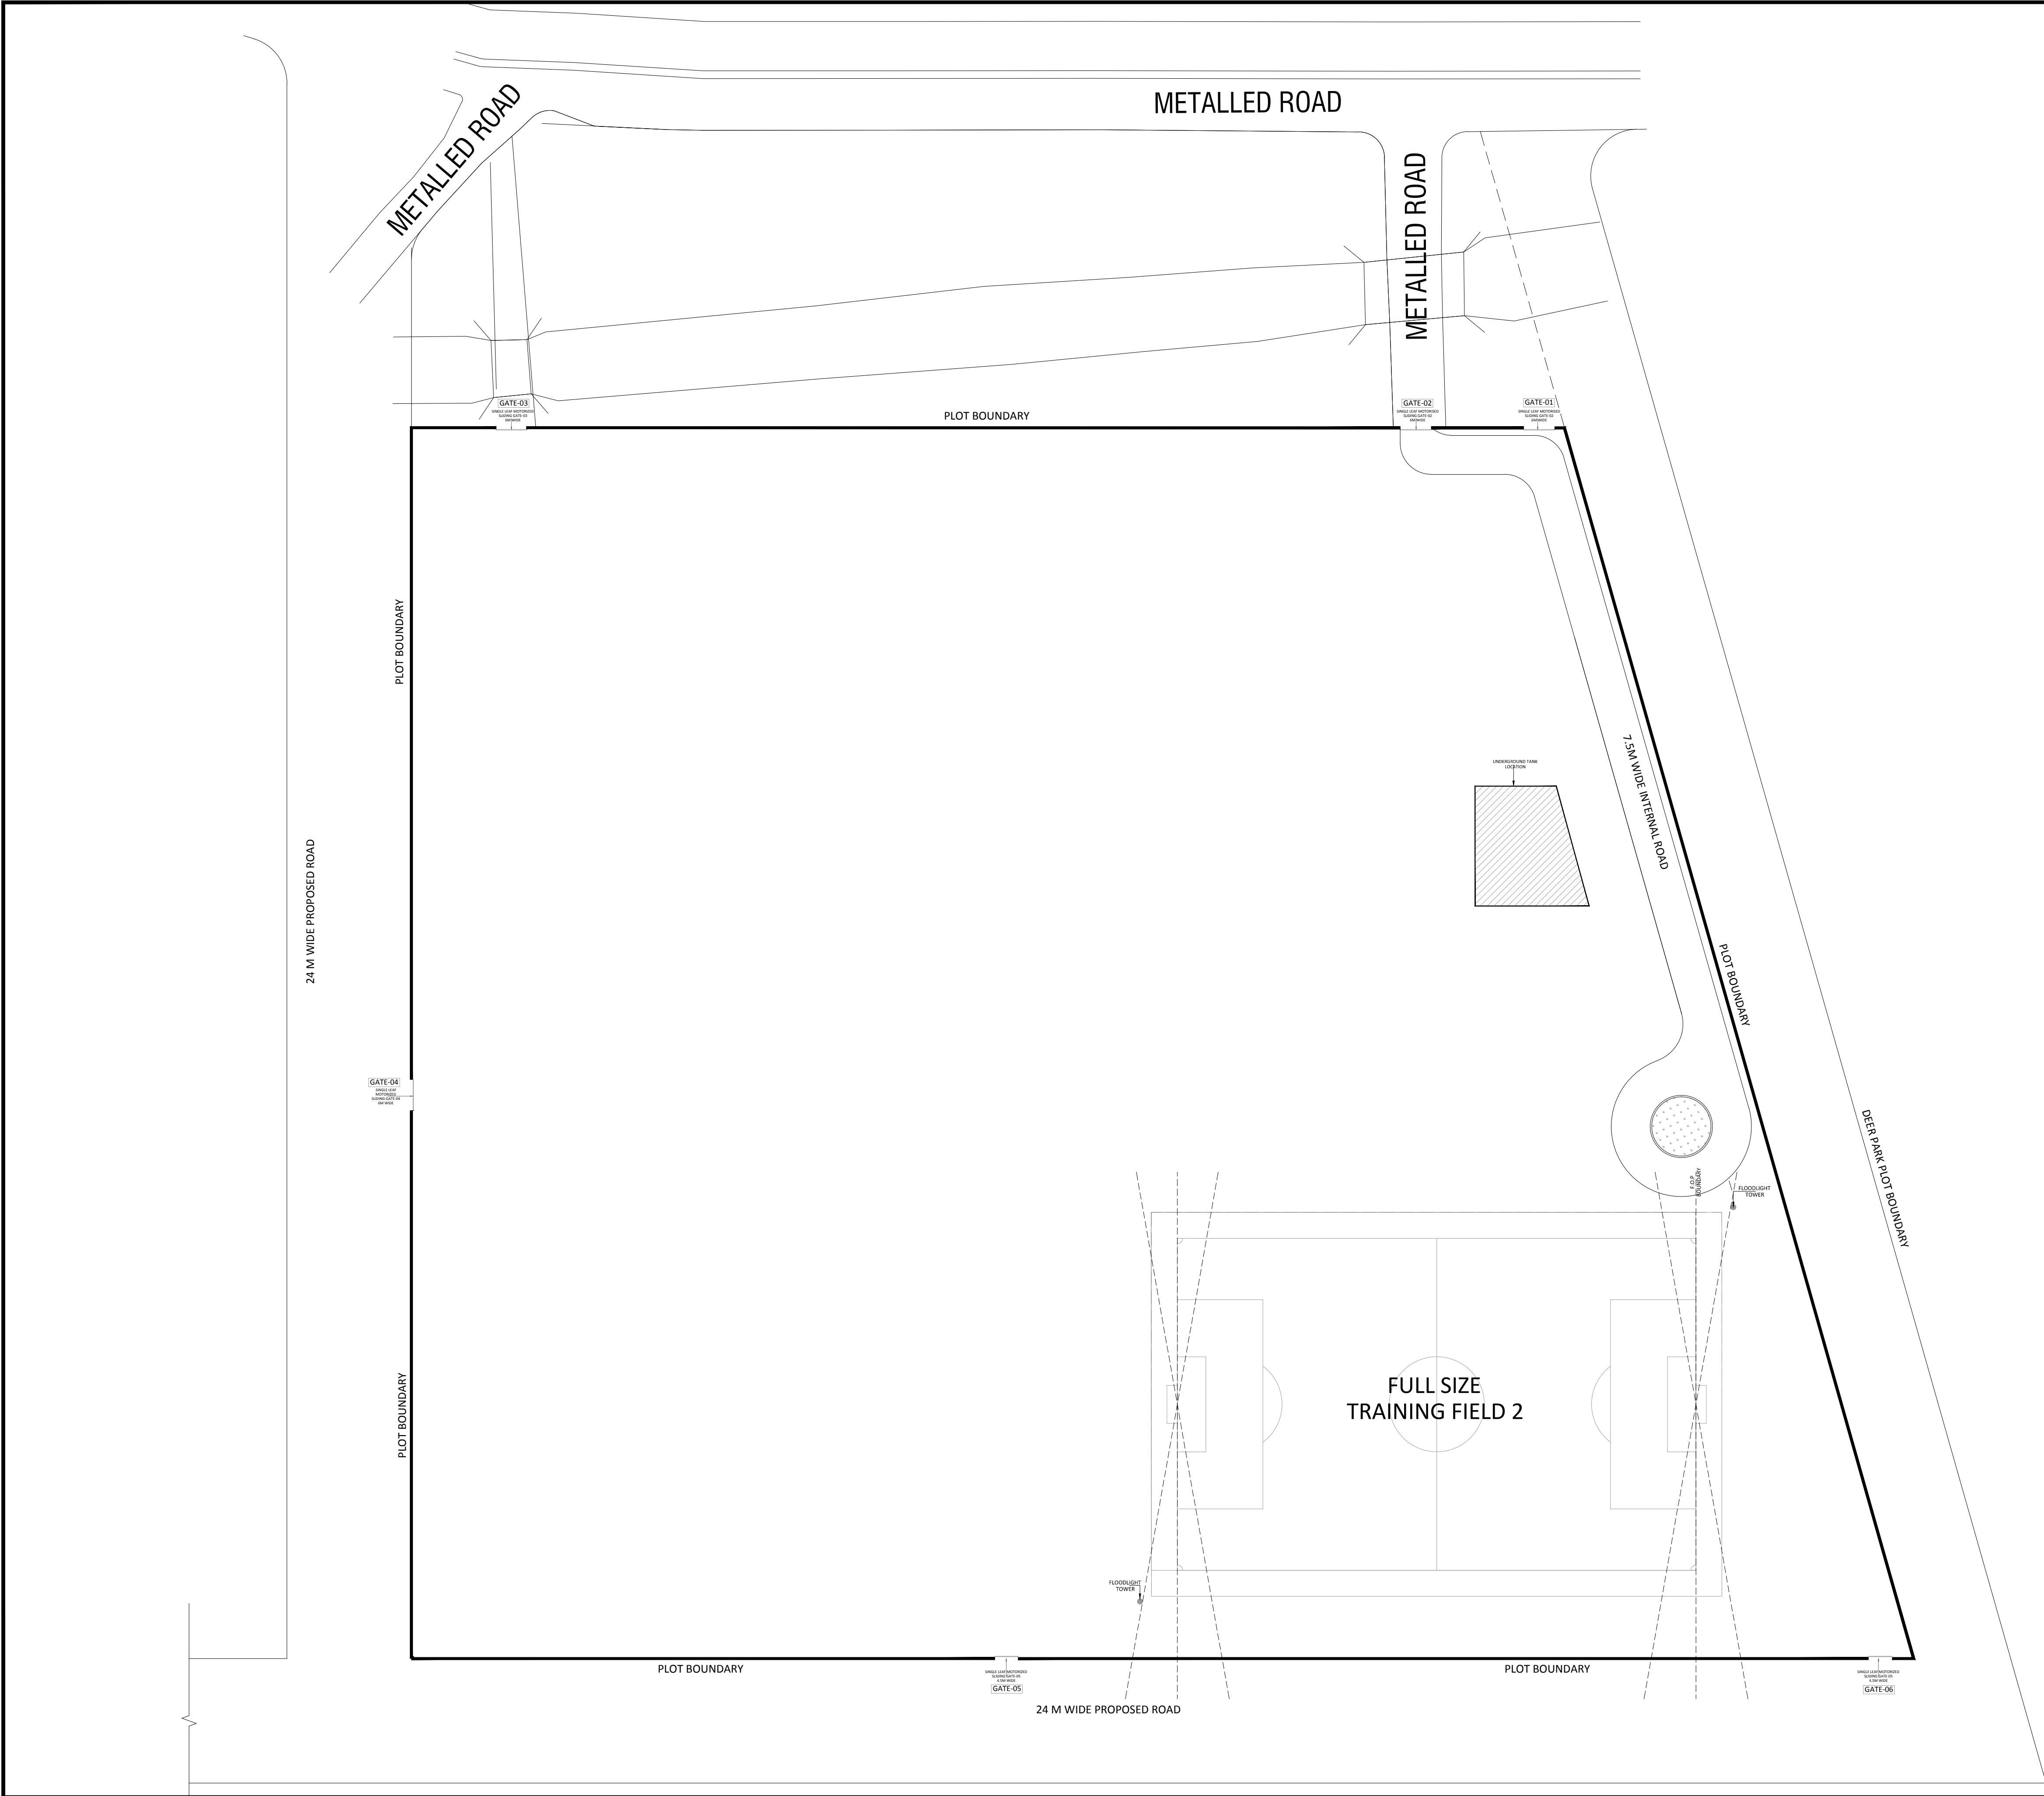

TENDER DRAWING

- GENERAL NOTES**
1. ALL DIMENSIONS IN MILLIMETERS AND LEVELS ARE IN METER UNLESS OTHERWISE SPECIFIED.
 2. ALL DIMENSIONS ARE TO BE CHECKED AND CO-RELATED WITH THE RELEVANT ARCHITECTURAL, STRUCTURAL AND SERVICES DRAWINGS AND ANY AMBIGUITY, DISCREPANCY OR OMISSION SHALL BE BROUGHT IN TO NOTICE OF ARCHITECT PRIOR TO COMMENCEMENT OF EXECUTION.
 3. DO NOT SCALE THE DRAWING, WRITTEN DIMENSION TO BE FOLLOWED.
 4. THIS DRAWING TO BE READ IN CONJUNCTION WITH THE RELEVANT SERVICES AND STRUCTURAL DRAWINGS.

REVISIONS		
REV	DESCRIPTION	DATE

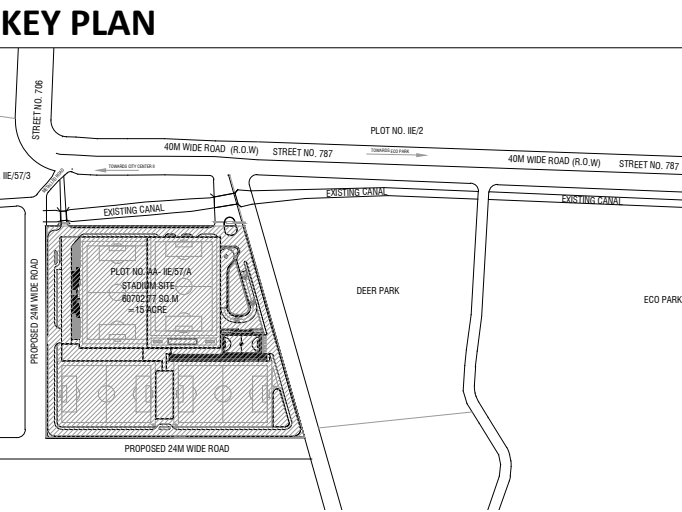

CLIENT

ALL INDIA FOOTBALL FEDERATION

ARCHITECT

Architecture | Interiors | PMC | EPC

COLLAGE DESIGN PVT. LTD.
300 Sai Chingappa, Station Rd
Vikhroli East, Mumbai - 400 083
T +91 22 2574 0844 / 45 F +91 22 2574 0846
E info@collagedesign.net
collagedesign.net

STRUCTURAL CONSULTANT

SACPL

Shanghvi and Associates
Consultants Pvt. Ltd.
7th Floor, Patmavati Heights,
Shradhdham Road, Vile Parle (E),
Mumbai - 400057.
Tel - +91 22 2614 4832, Fax - +91
22 2617 1804

MEP CONSULTANT

MEPCON DESIGN STUDIO


PROJECT

NATIONAL CENTRE OF EXCELLENCE
IN FOOTBALL @ RAJRAHAT, KOLKATA

DRAWING TITLE

**SITE DEVELOPMENT LAYOUT
PHASE-1**


DWG. NO.		REV. NO.
TD.A.0.02		R0
PROJECT NO.	18-P245	NORTH
SCALE		
1 st ISSUED ON	28-09-2018	
APPROVED	RS	
CHECKED BY		BD
DRAWN BY		

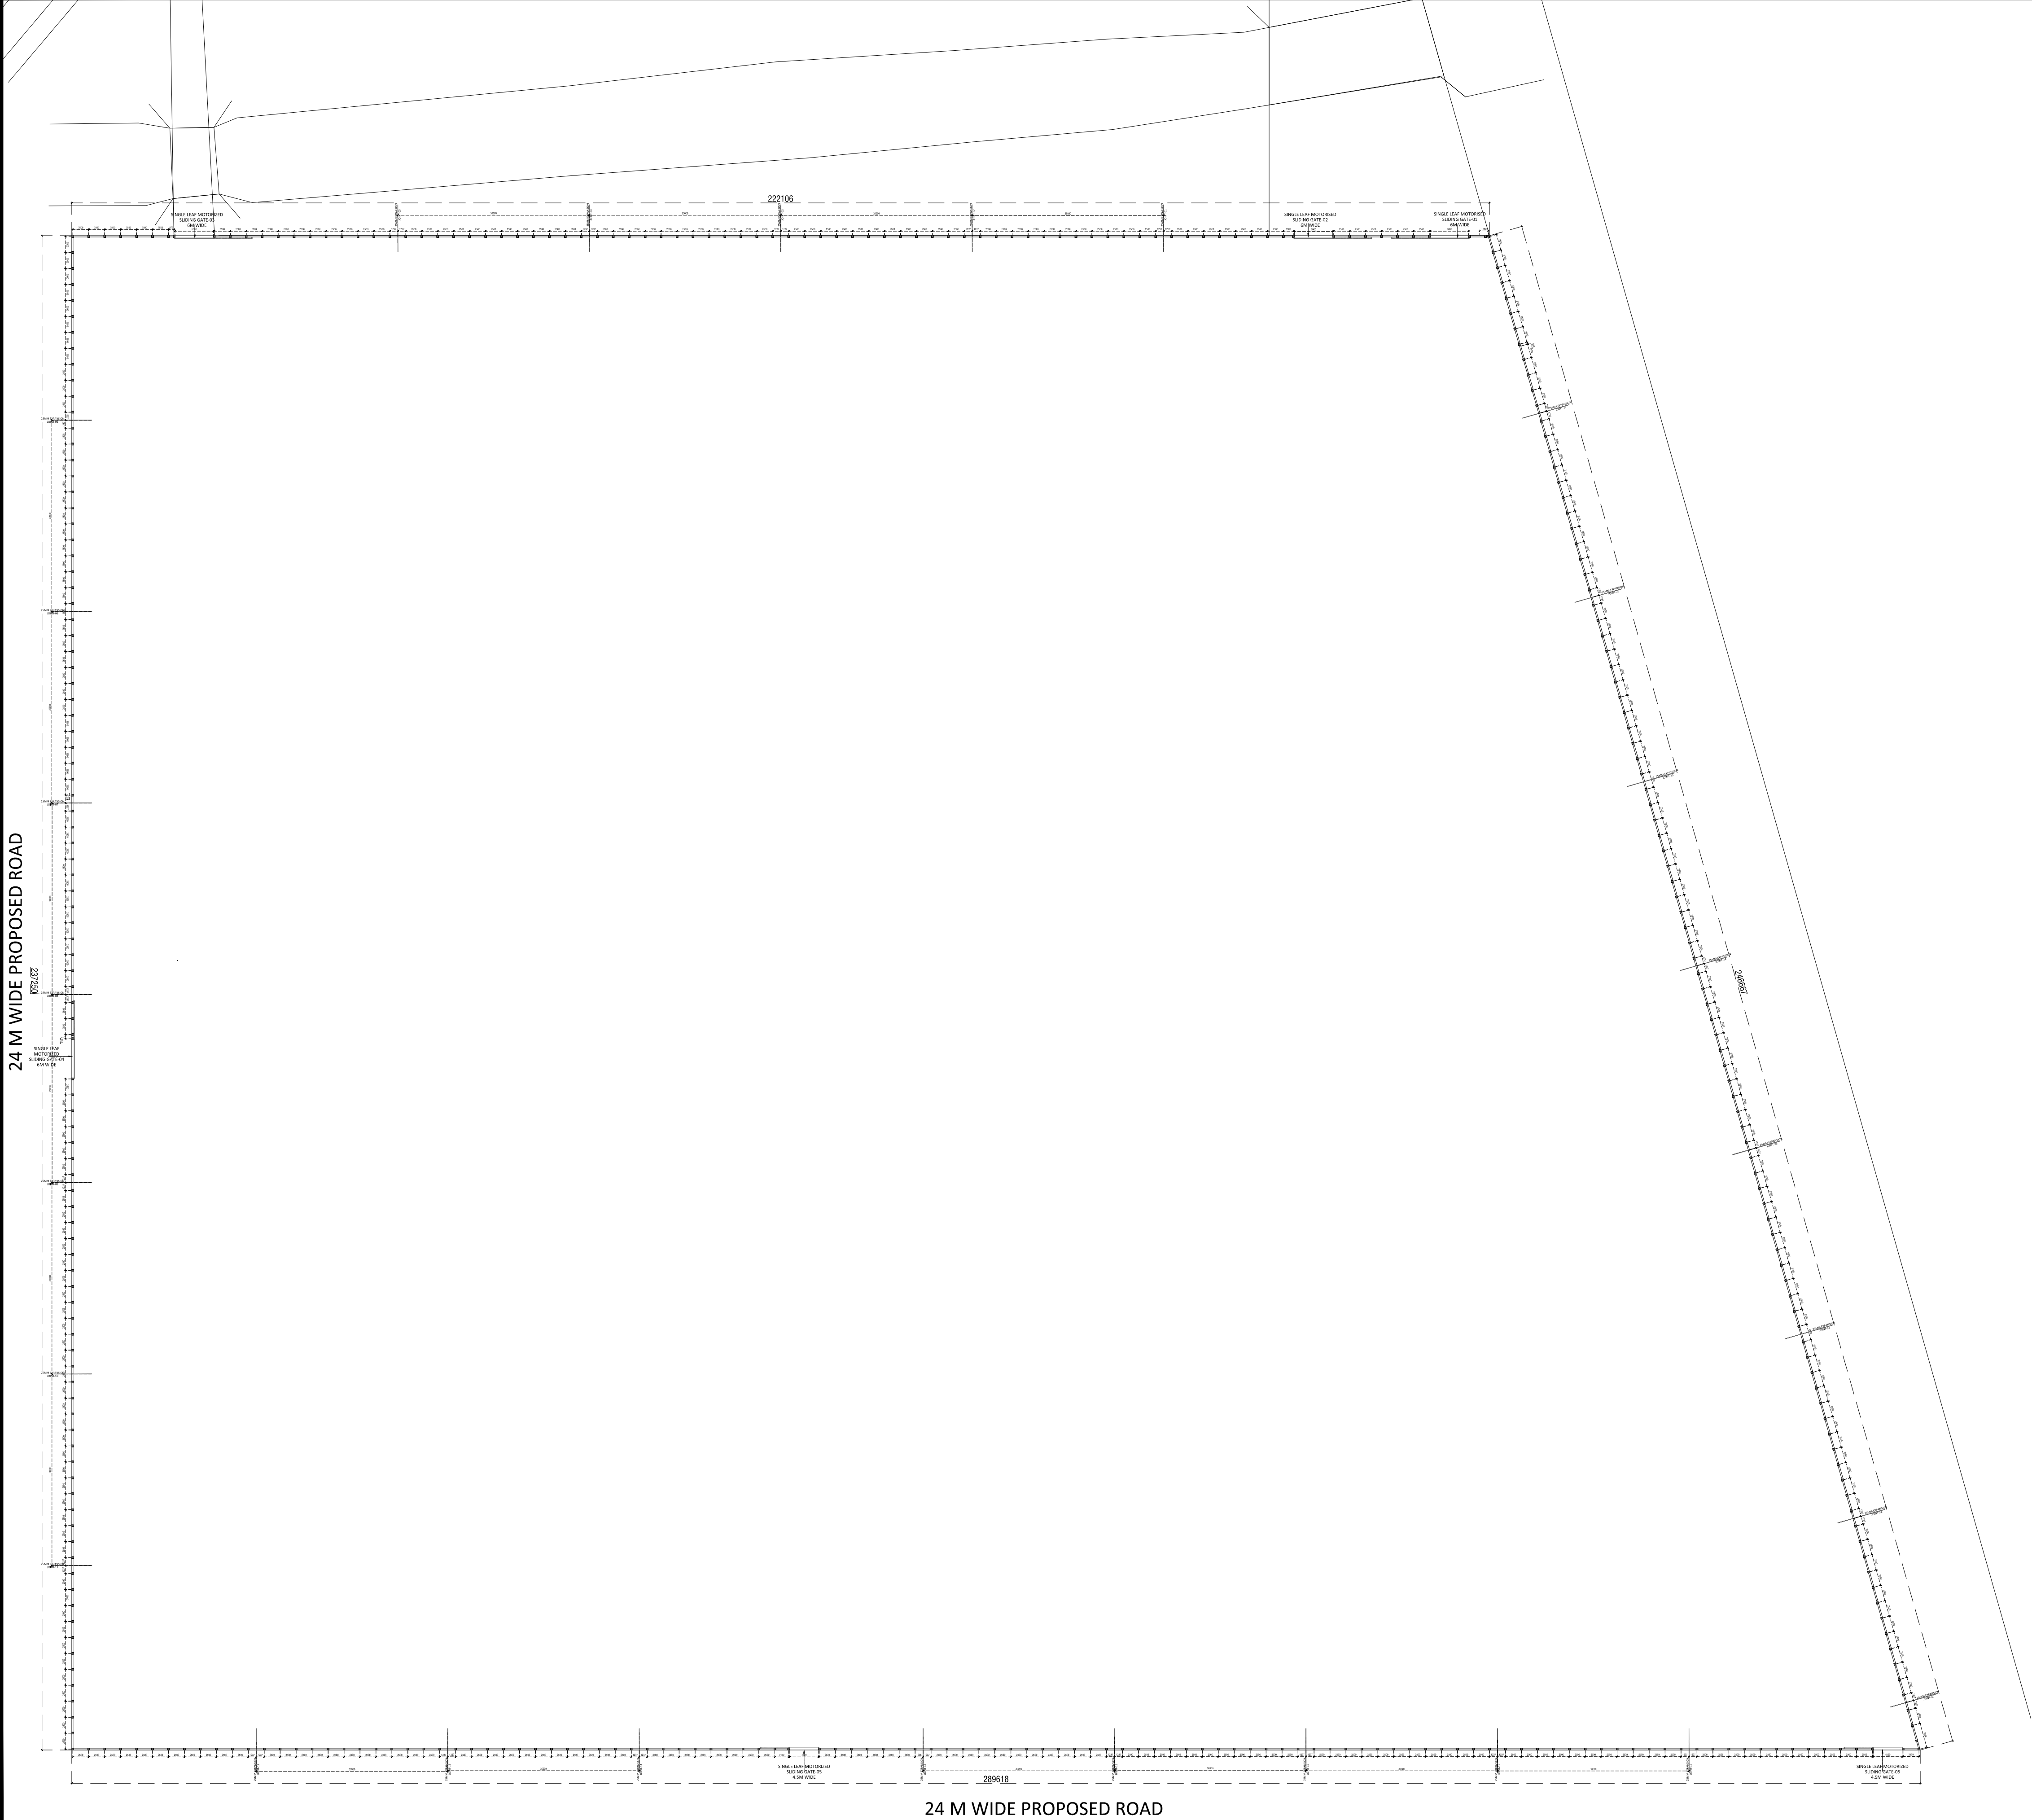

TENDER DRAWING

- GENERAL NOTES**
1. ALL DIMENSIONS IN MILLIMETERS AND LEVELS ARE IN METER UNLESS OTHERWISE SPECIFIED.
 2. ALL DIMENSIONS ARE TO BE CHECKED AND CO-RELATED WITH THE RELEVANT ARCHITECTURAL, STRUCTURAL AND SERVICES DRAWINGS AND ANY AMBIGUITY, DISCREPANCY OR OMISSION SHALL BE BROUGHT IN TO NOTICE OF ARCHITECT PRIOR TO COMMENCEMENT OF EXECUTION.
 3. DO NOT SCALE THE DRAWING, WRITTEN DIMENSION TO BE FOLLOWED.
 4. THIS DRAWING TO BE READ IN CONJUNCTION WITH THE RELEVANT SERVICES AND STRUCTURAL DRAWINGS.

REVISIONS		
REV	DESCRIPTION	DATE

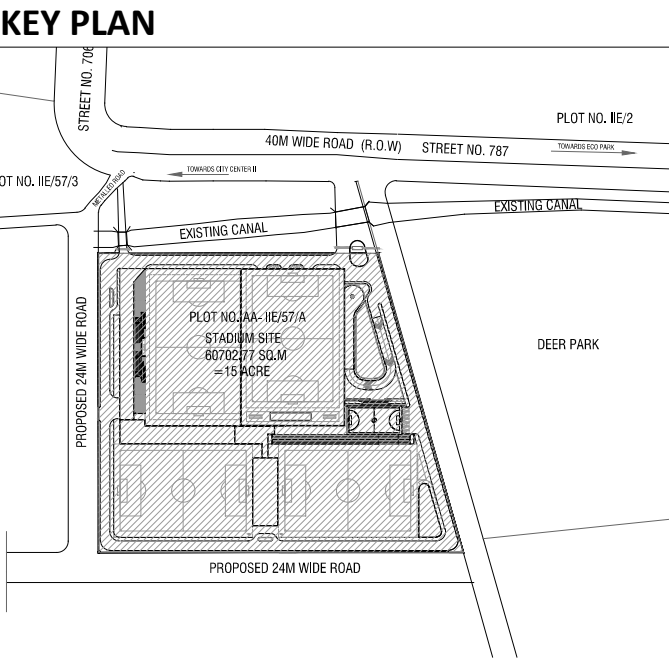

CLIENT

ALL INDIA FOOTBALL FEDERATION

ARCHITECT

Architecture | Interiors | PMC | EPC

COLLAGE DESIGN PVT. LTD.
300 Sai Sangeeta, Station Rd
Vikhroli East, Mumbai - 400 083
T +91 22 2574 0844 / 45 F +91 22 2574 0846
E info@collagedesign.net
collagedesign.net

STRUCTURAL CONSULTANT

Shanghi and Associates Consultants Pvt. Ltd.
7th Floor, Patravali Heights,
Shradhamand Road, Vile Parle (E),
Mumbai - 400057.
Tel. + 91 22 2514 4832, Fax + 91 22 2817 1804

MEP CONSULTANT

MEPCON DESIGN STUDIO


PROJECT

NATIONAL CENTRE OF EXCELLENCE
IN FOOTBALL @ RAJRAHAT, KOLKATA


DRAWING TITLE

COMPOUND WALL-
SITE PLAN

DWG. NO.		REV. NO.
TD.A.3.01		R0
PROJECT NO.	18-P245	
SCALE	1:500	
1 st ISSUED ON	28-09-2018	
APPROVED	RS	NORTH
CHECKED BY		
DRAWN BY	BD	

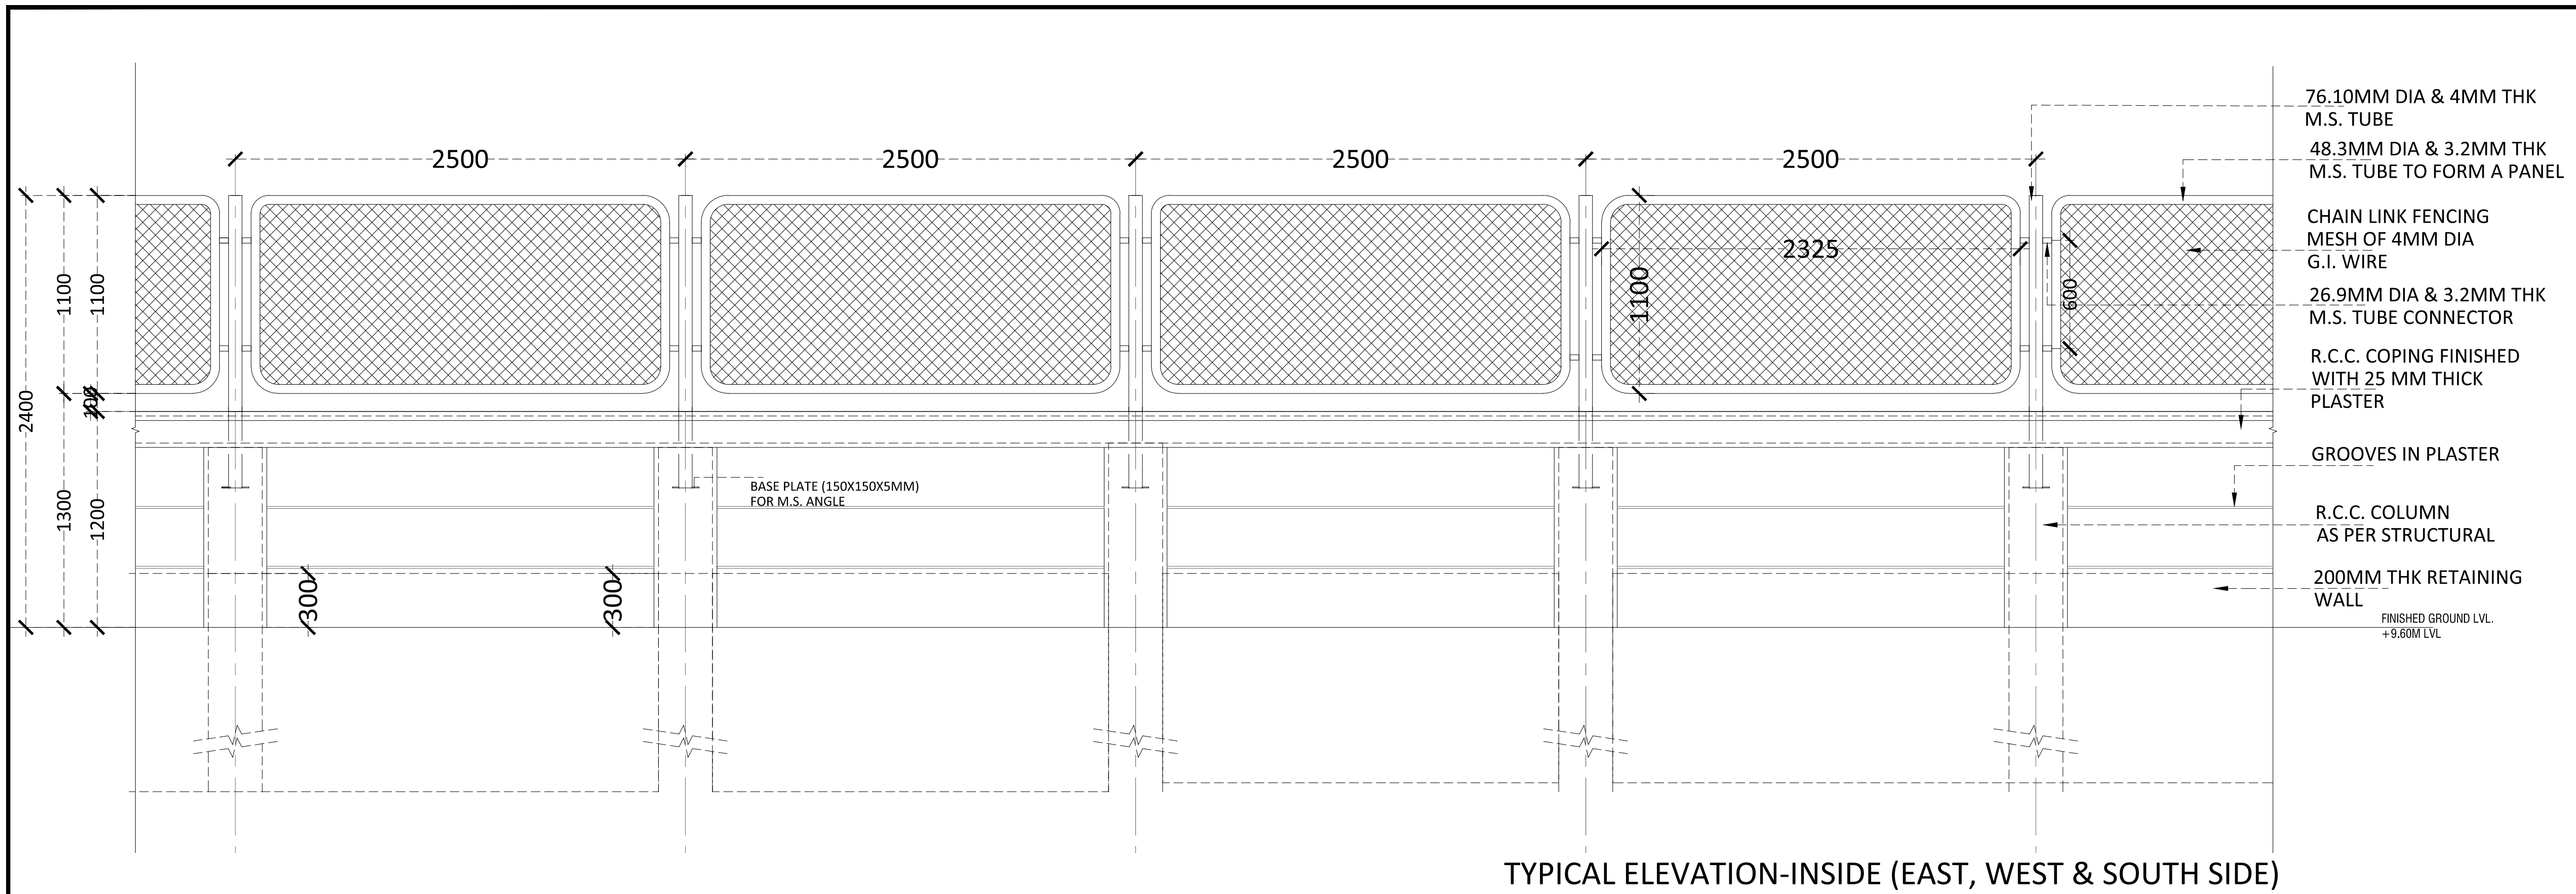


TYPICAL ELEVATION-INSIDE (EAST, WEST & SOUTH SIDE)

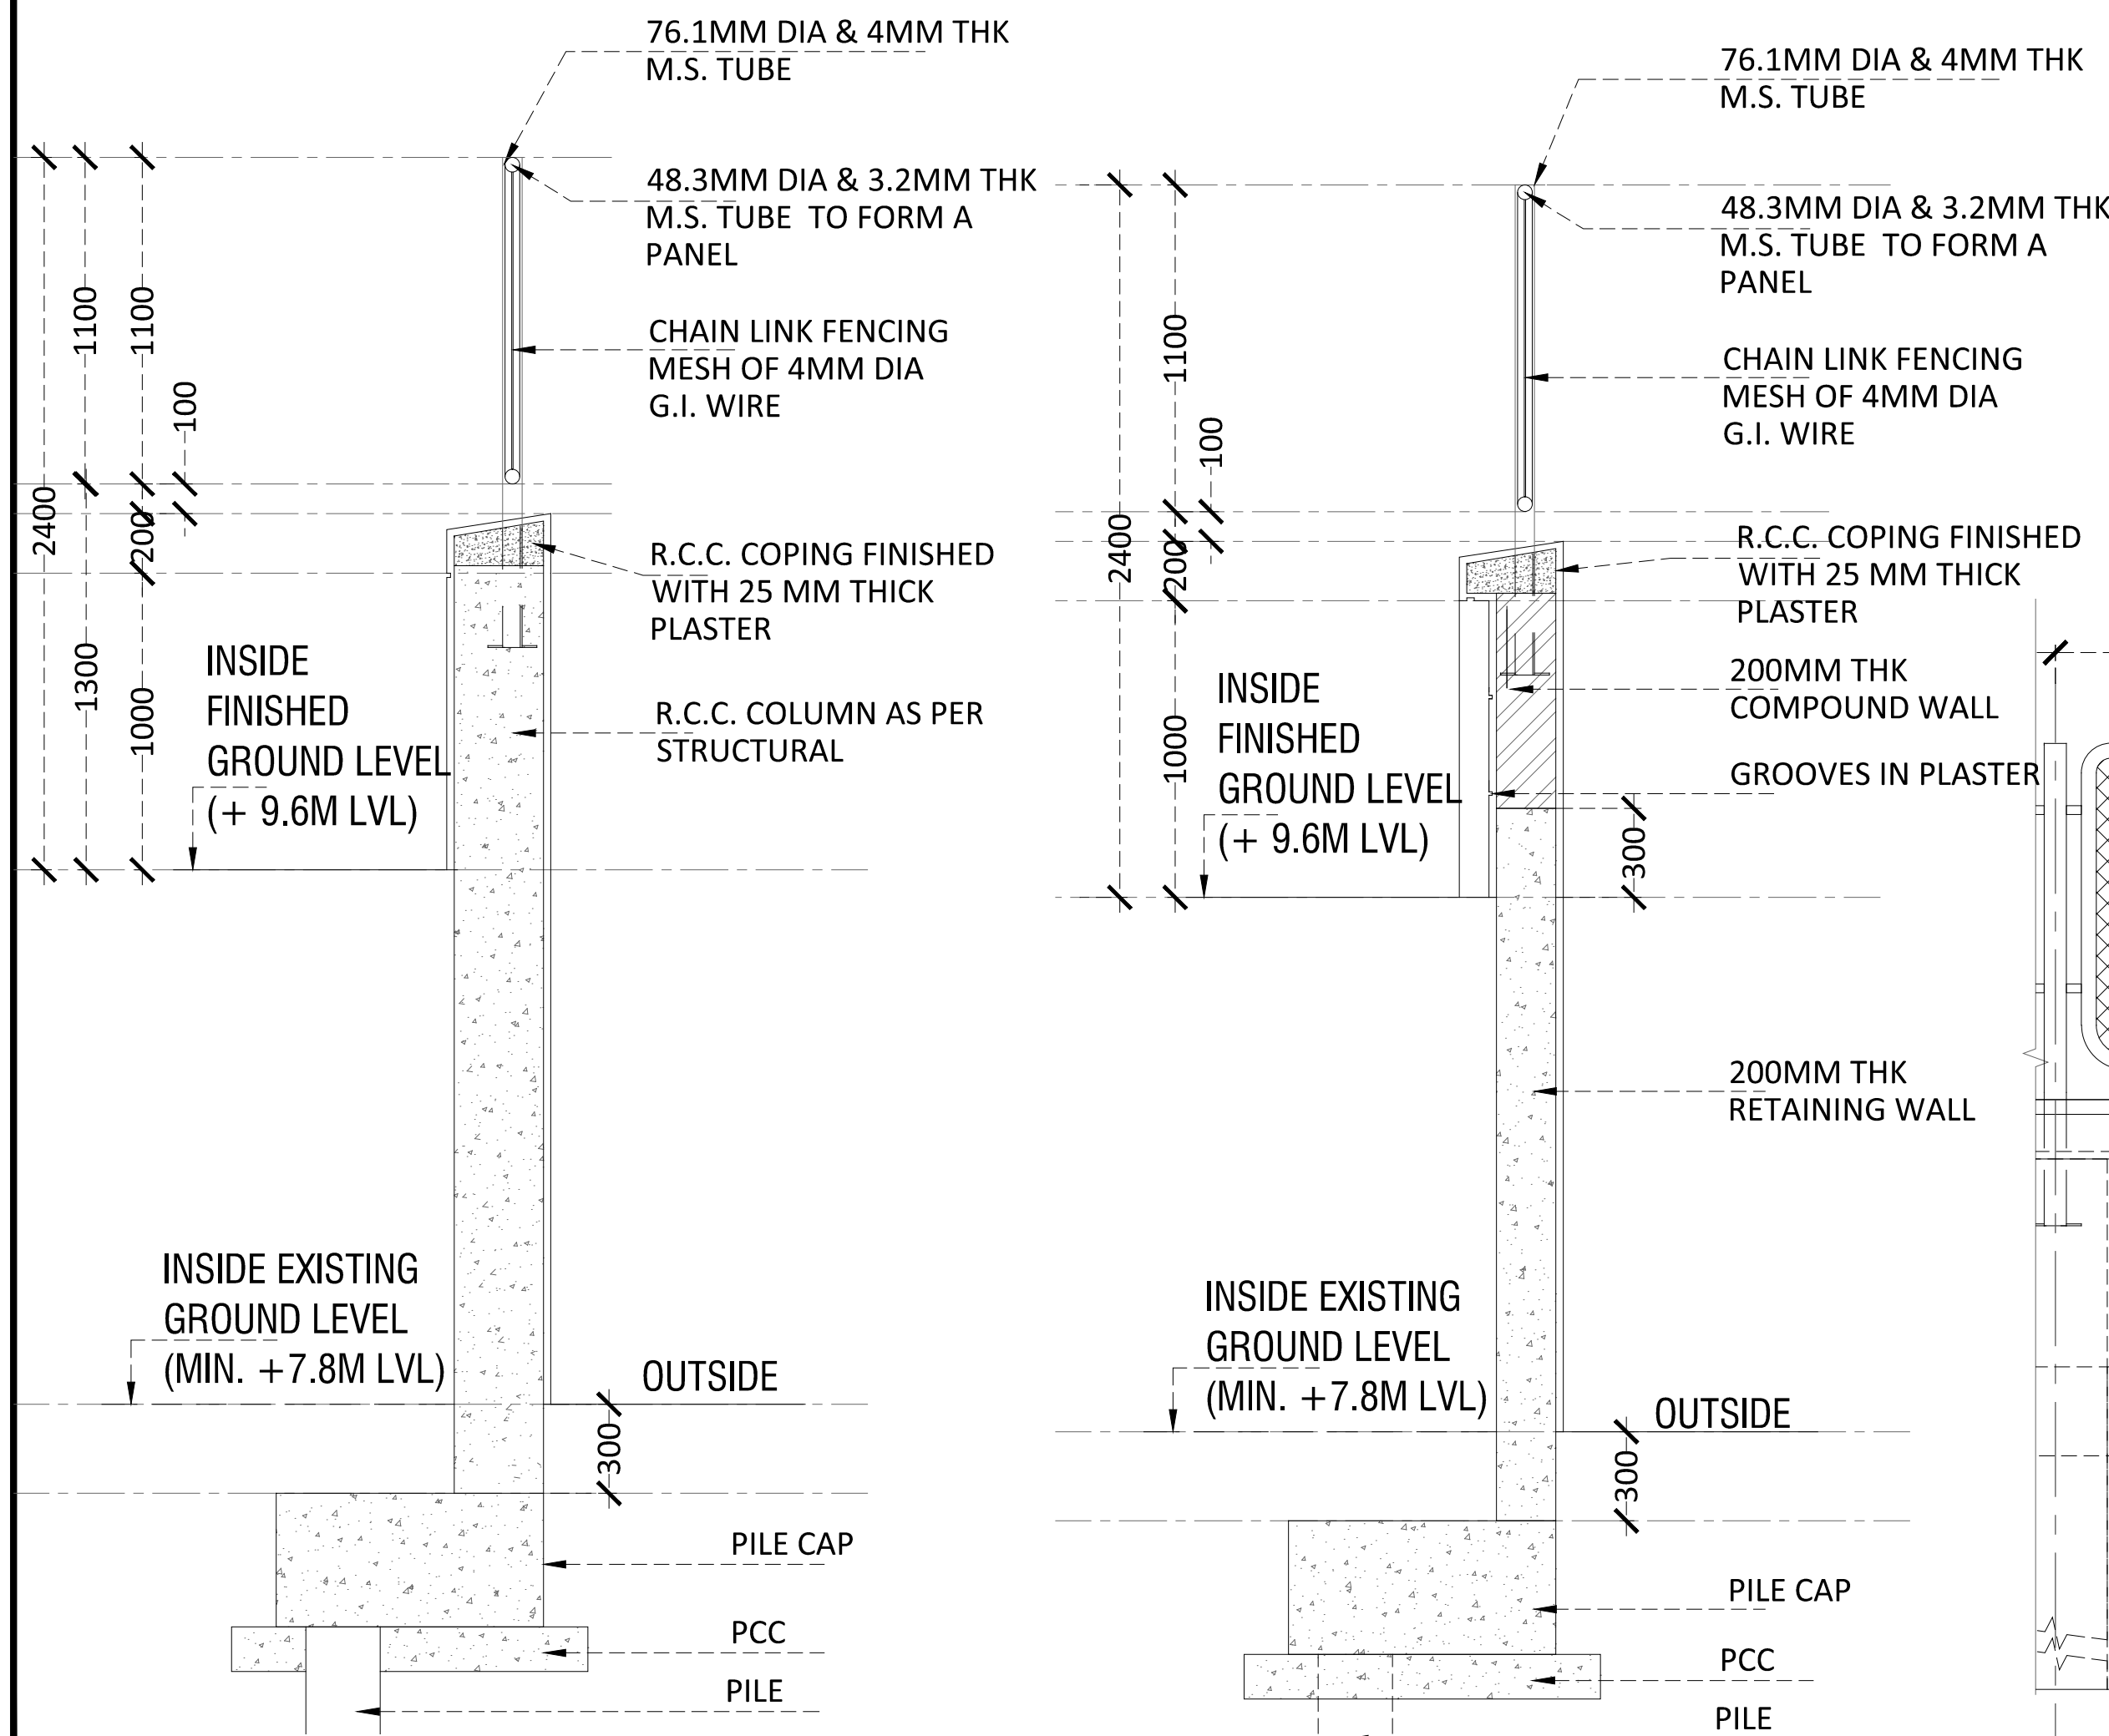

TYPICAL SECTION THROUGH COLUMN

TYPICAL SECTION THROUGH COMPOUND WALL

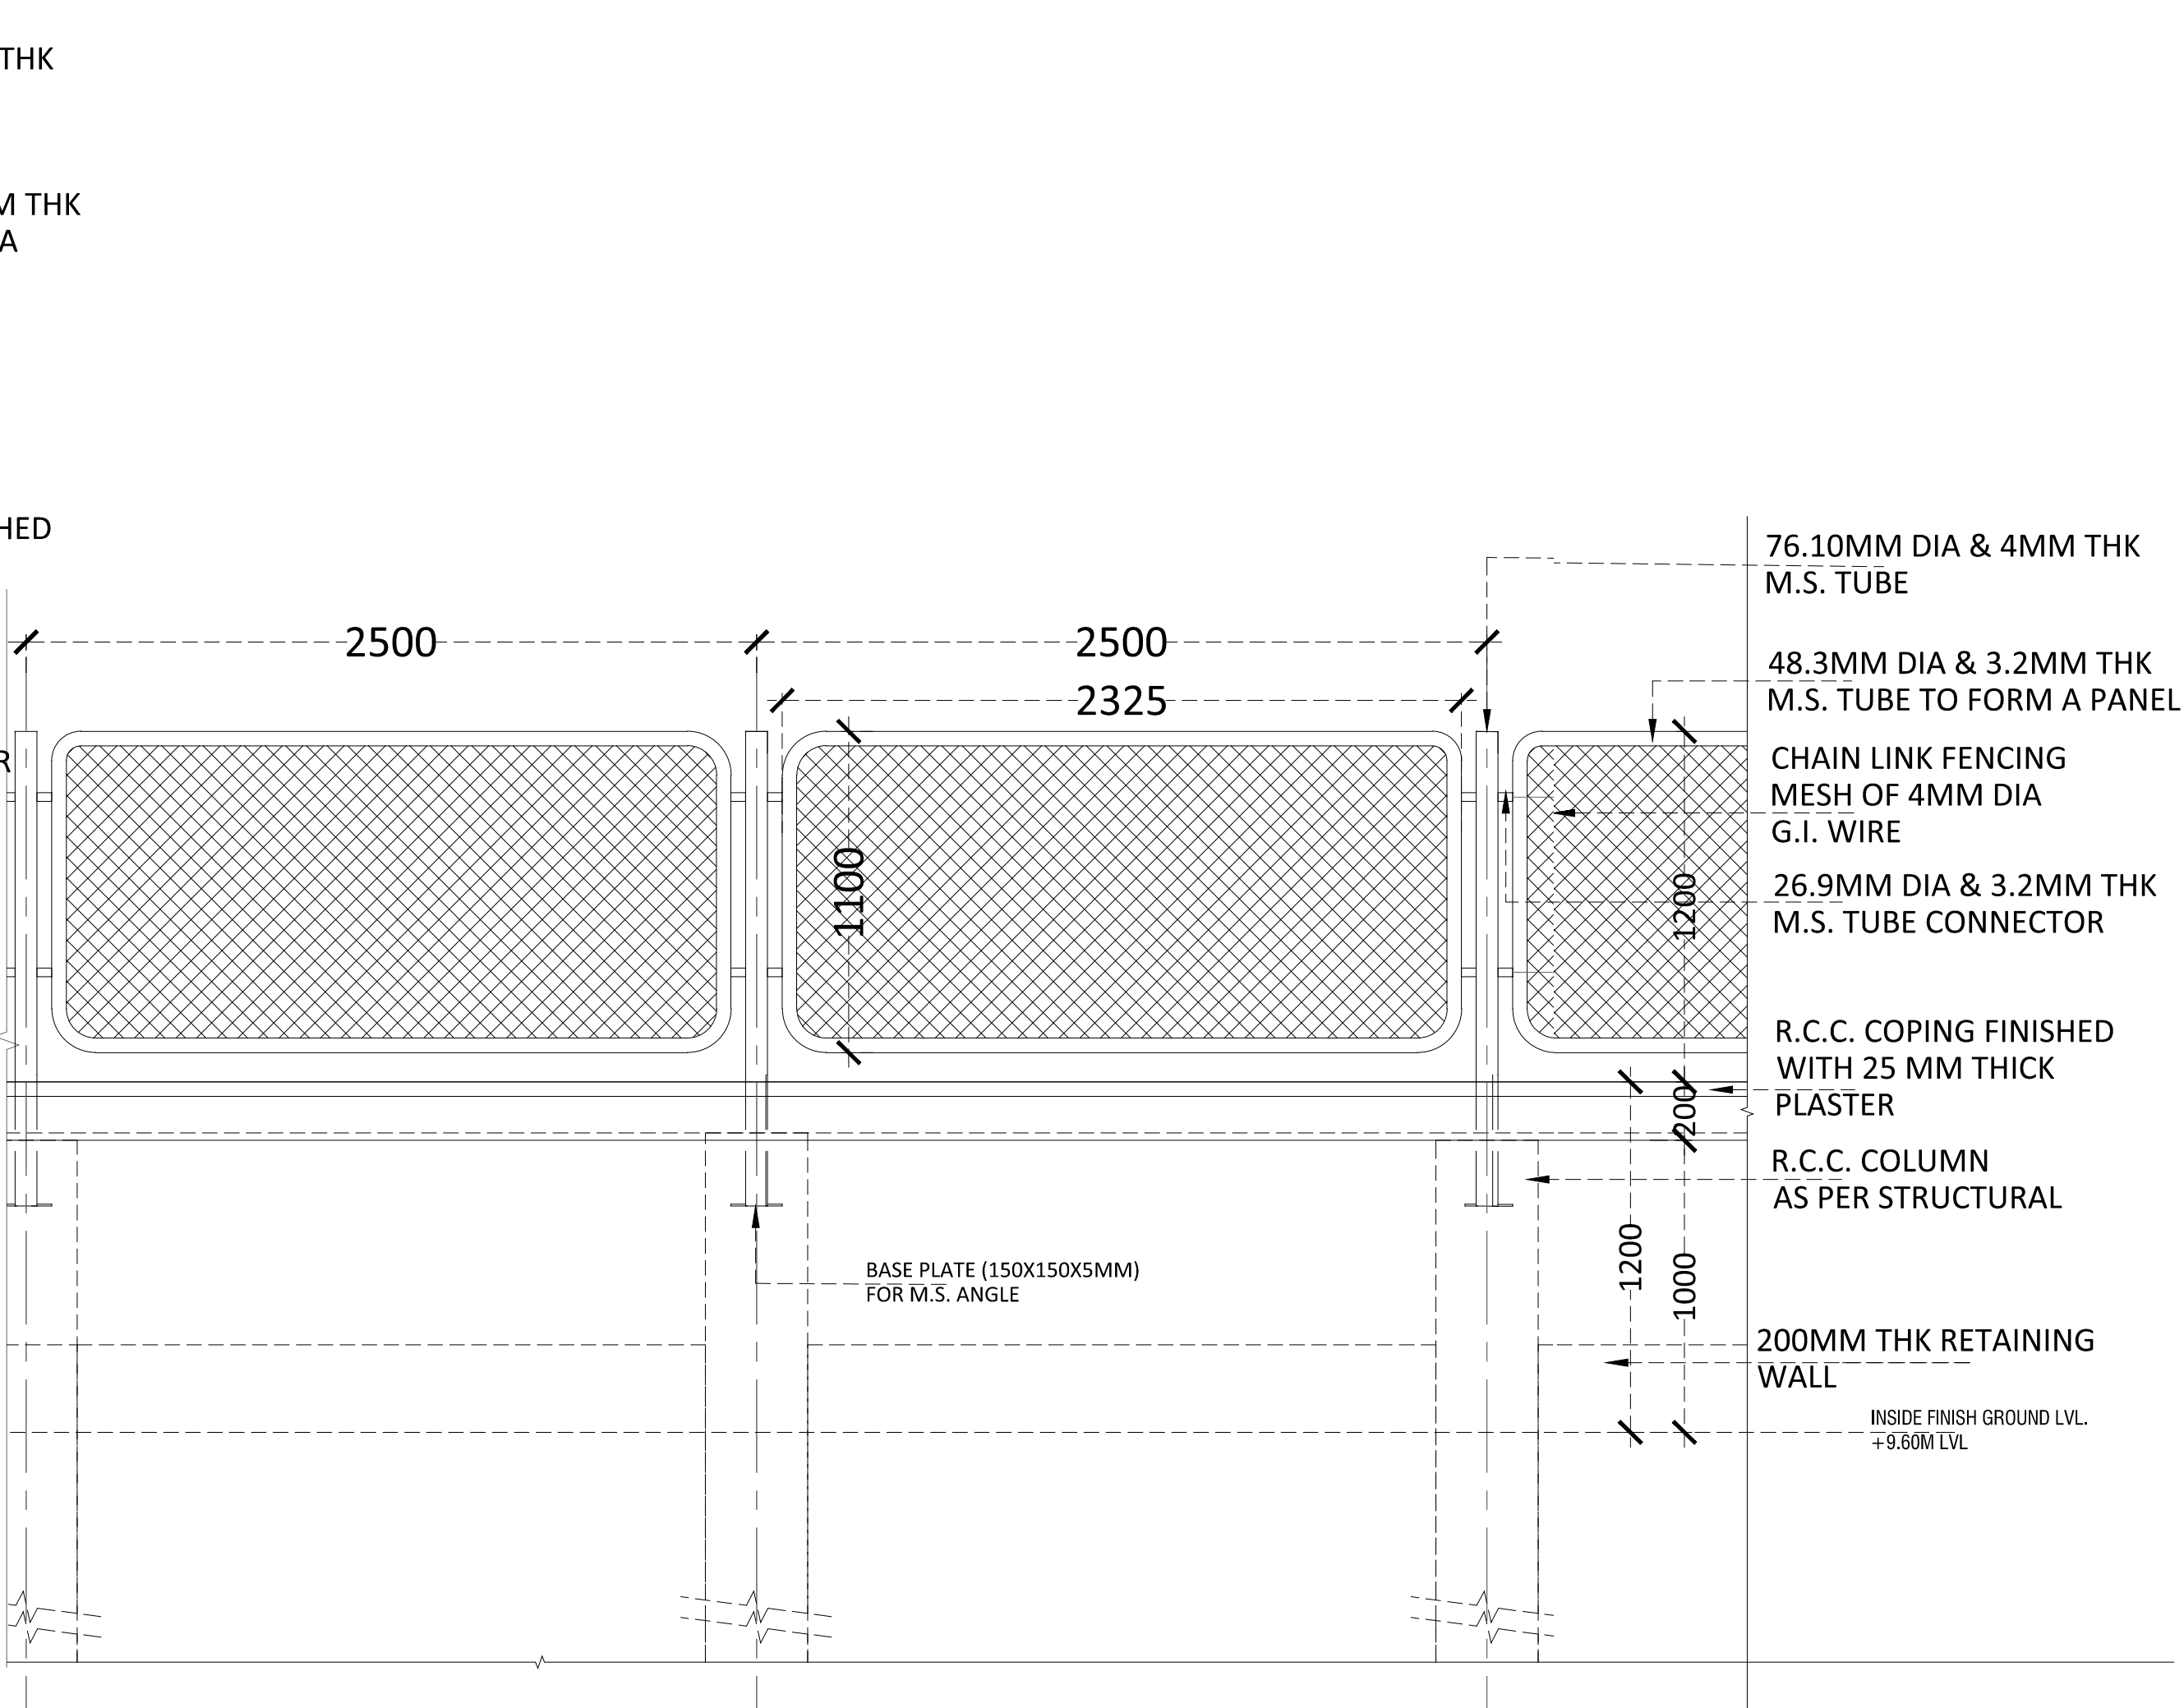

TYPICAL ELEVATION-OUTSIDE (EAST, WEST & SOUTH SIDE)

TENDER DRAWING

GENERAL NOTES

1. ALL DIMENSIONS IN MILLIMETERS AND LEVELS ARE IN METER UNLESS OTHERWISE SPECIFIED.
2. ALL DIMENSIONS ARE TO BE CHECKED AND CO-RELATED WITH THE RELEVANT ARCHITECTURAL, STRUCTURAL AND SERVICES DRAWINGS AND ANY AMBIGUITY, DISCREPANCY OR OMISSION SHALL BE BROUGHT IN TO NOTICE OF ARCHITECT PRIOR TO COMMENCEMENT OF EXECUTION.
3. DO NOT SCALE THE DRAWING, WRITTEN DIMENSION TO BE FOLLOWED.
4. THIS DRAWING TO BE READ IN CONJUNCTION WITH THE RELEVANT SERVICES AND STRUCTURAL DRAWINGS.

REVISIONS

REV	DESCRIPTION	DATE

KEY PLAN

CLIENT

ALL INDIA FOOTBALL FEDERATION

ARCHITECT

Architecture | Interiors | PMC | EPC
COLLAGE DESIGN PVT. LTD.
300 Sai Sangeeta, Station Rd
Vikhroli East, Mumbai - 400 083
T: +91 22 2574 0844 / 45 F: +91 22 2574 0846
E: info@collagedesign.net
collagedesign.net

STRUCTURAL CONSULTANT

Shanghvi and Associates
Consultants Pvt. Ltd.
7th Floor, Patravadi Heights,
Shradhdham Road, Vile Parle (E),
Mumbai - 400 057.
Tel: +91 22 2614 4832, Fax: +91
22 2817 1804

MEP CONSULTANT

PROJECT

NATIONAL CENTRE OF EXCELLENCE
IN FOOTBALL @ RAJRAHAT, KOLKATA

DRAWING TITLE

COMPOUND WALL-
TYPICAL SECTION & ELEVATION
(FOR SOUTH, EAST & WEST SIDE)

DWG. NO.

TD.A.3.02

REV. NO.

R0

PROJECT NO.

18-P245

SCALE

1:20

1st ISSUED ON

28-09-2018

APPROVED

RS


CHECKED BY



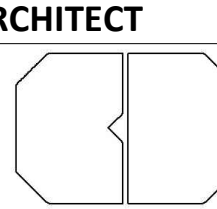

DRAWN BY



BD

NORTH

THIS DRAWING IS A PROPERTY OF COLLAGE DESIGN PVT. LTD. AND IS NOT TO BE REPRODUCED OR USED FOR ANY OTHER PURPOSE THAN FOR WHICH IT HAS BEEN LOANED.

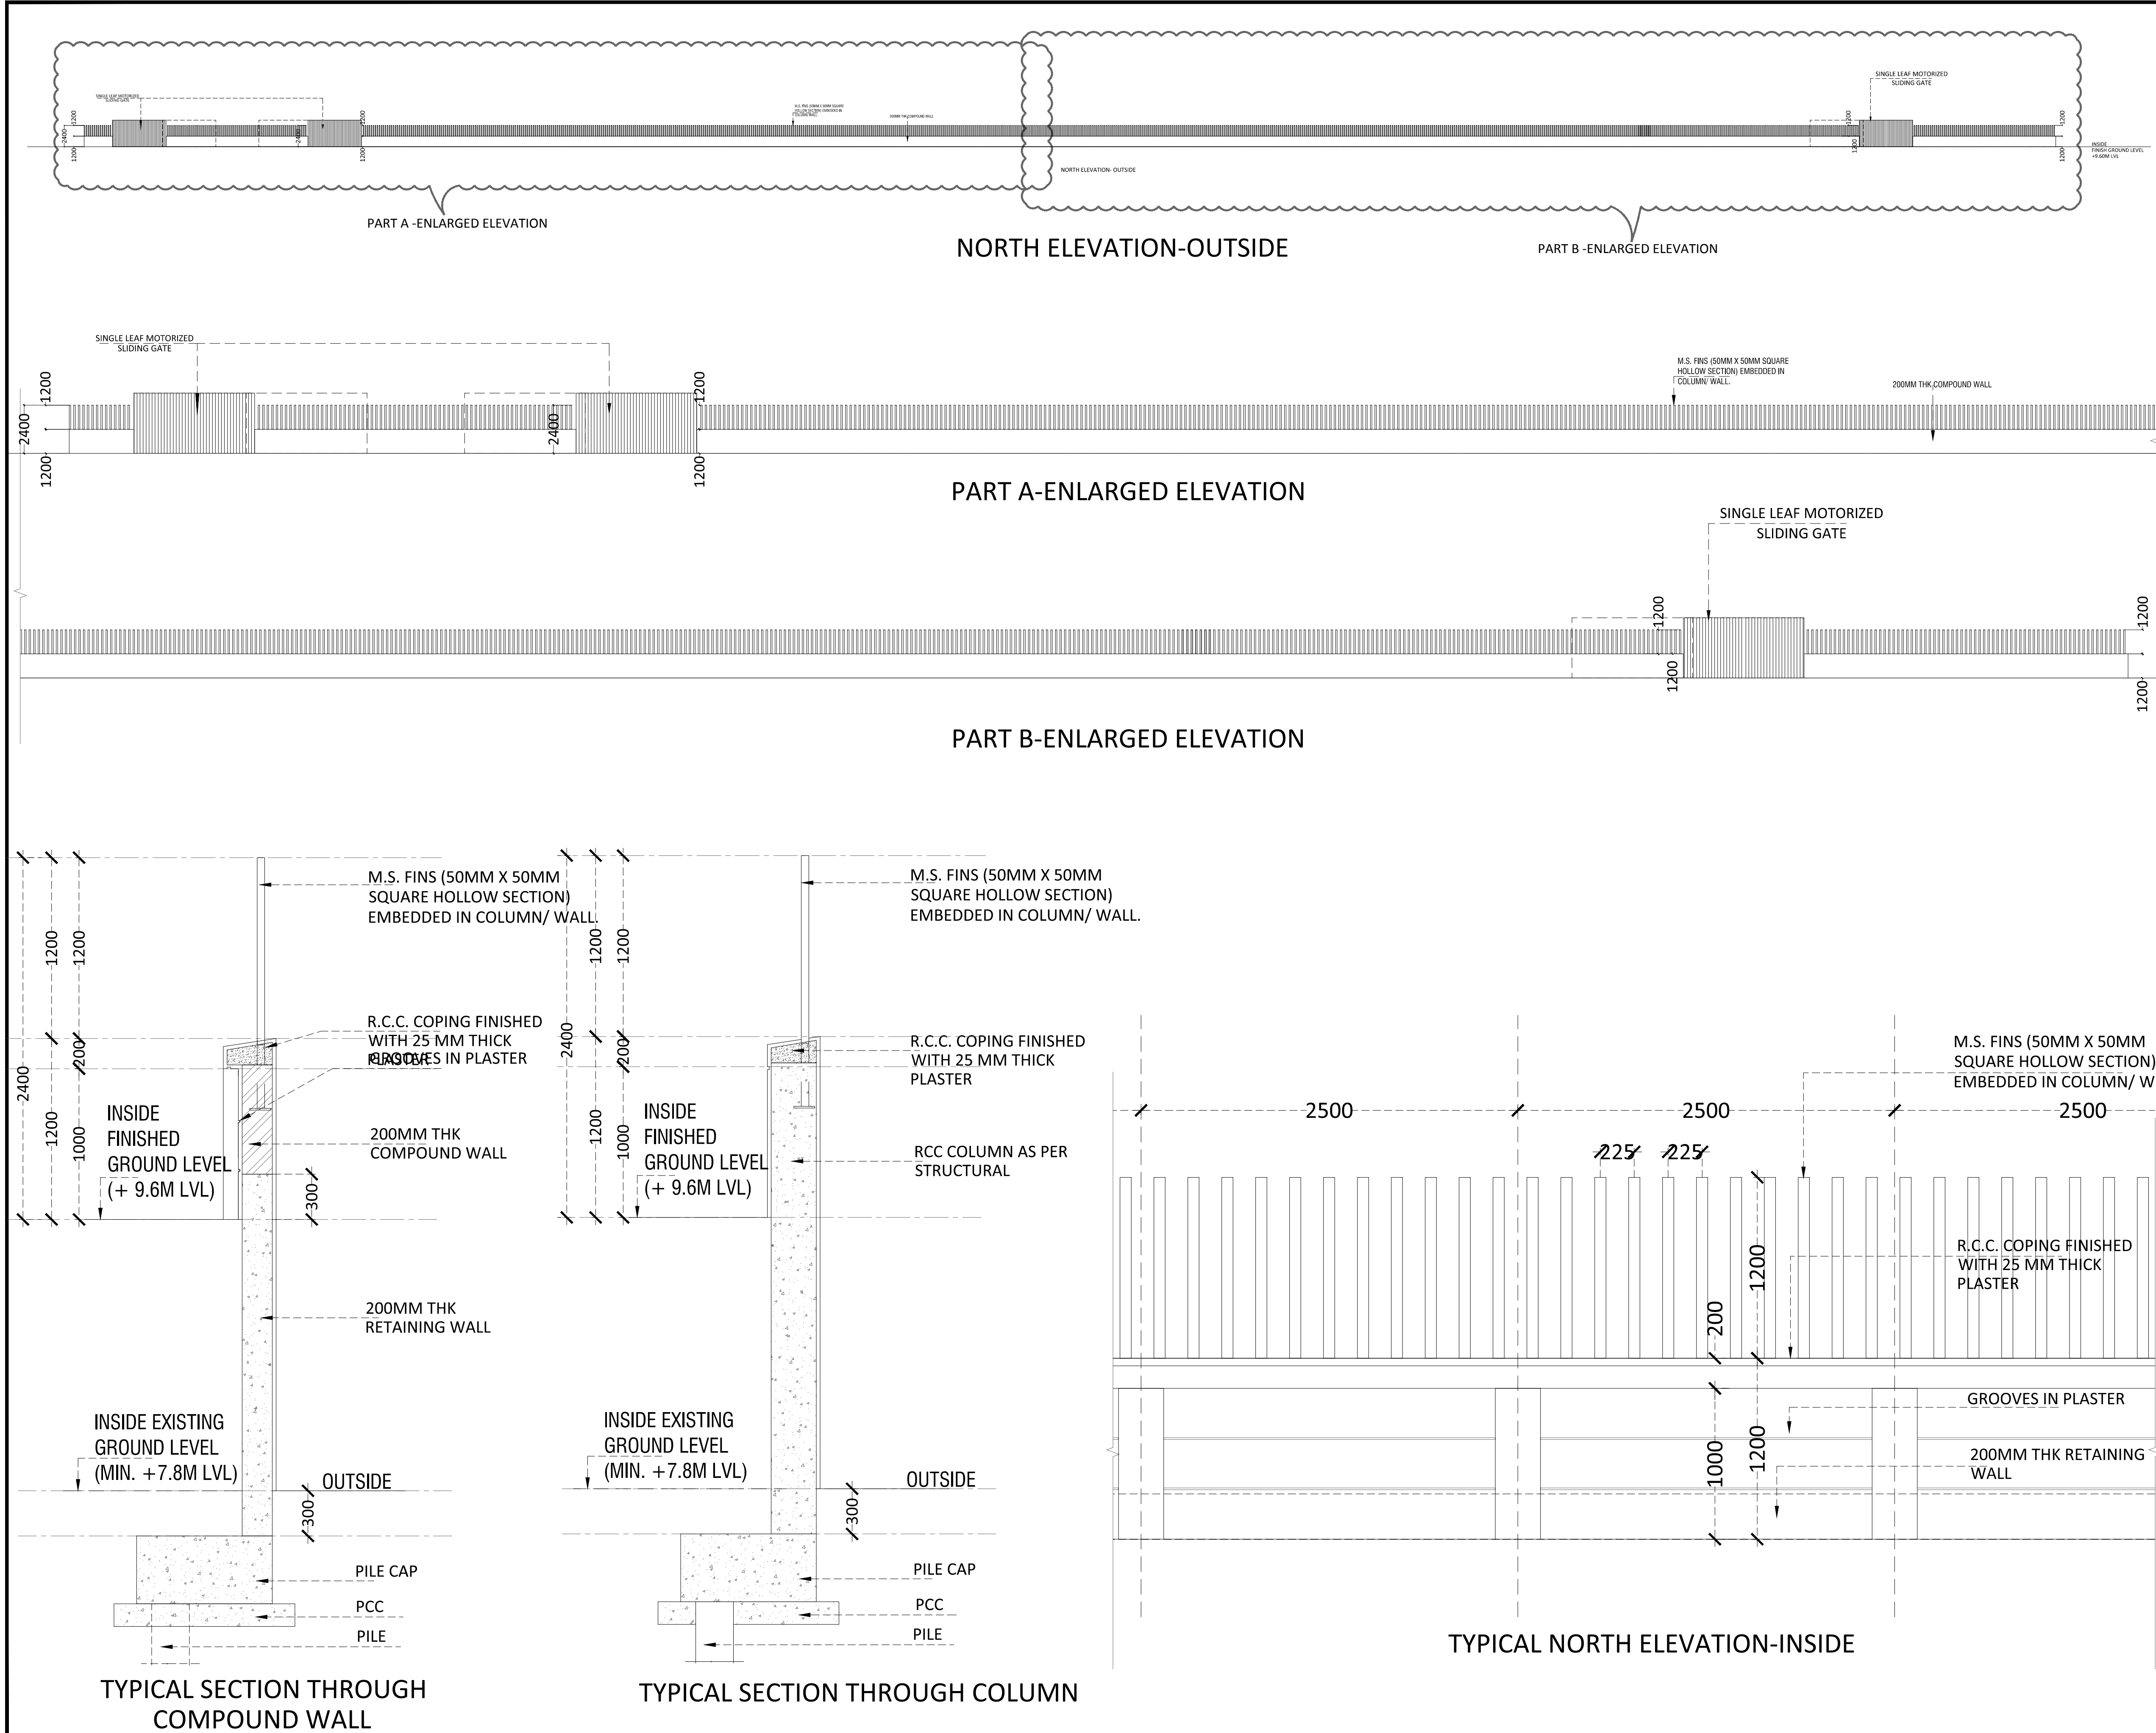

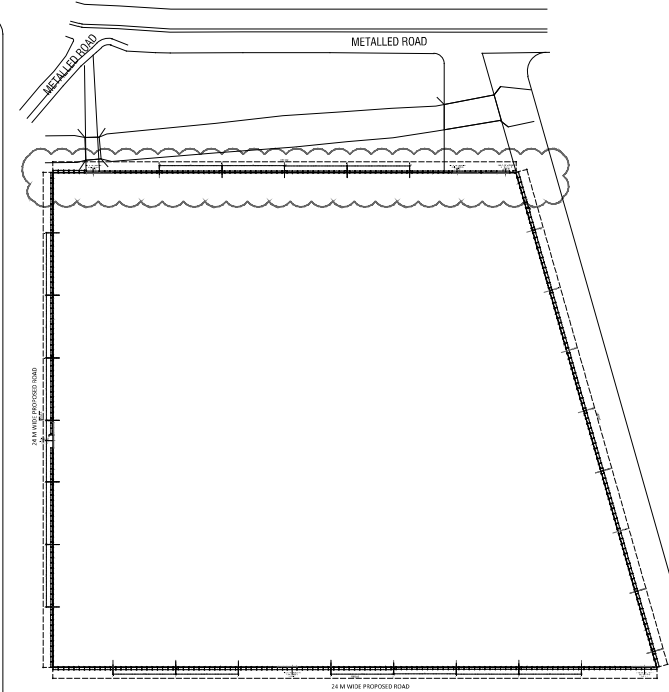TENDER DRAWING		
GENERAL NOTES		
1. ALL DIMENSIONS IN MILLIMETERS AND LEVELS ARE IN METER UNLESS OTHERWISE SPECIFIED.		
2. ALL DIMENSIONS ARE TO BE CHECKED AND CO-RELATED WITH THE RELEVANT ARCHITECTURAL, STRUCTURAL AND SERVICES DRAWINGS AND ANY AMBIGUITY, DISCREPANCY OR OMISSION SHALL BE BROUGHT IN TO NOTICE OF ARCHITECT PRIOR TO COMMENCEMENT OF EXECUTION.		
3. DO NOT SCALE THE DRAWING, WRITTEN DIMENSION TO BE FOLLOWED.		
4. THIS DRAWING TO BE READ IN CONJUNCTION WITH THE RELEVANT SERVICES AND STRUCTURAL DRAWINGS.		
REVISIONS		
REV	DESCRIPTION	DATE
KEY PLAN		
		
COMPOUND WALL		
CLIENT		
ALL INDIA FOOTBALL FEDERATION		
ARCHITECT		
	Architecture Interiors PMC EPC COLLAGE DESIGN PVT. LTD. 300 Sai Changanika, Station Rd Winkhori East, Mumbai - 400 083 T: +91 22 2574 0844 / 45 F: +91 22 2574 0846 E: info@collagedesign.net collagedesign.net	
STRUCTURAL CONSULTANT		
	Shanghvi and Associates Consultants Pvt. Ltd. 7th Floor, Patravali Heights, Shradhdham Road, Vile Parle (E), Mumbai - 400057 Tel: +91 22 2614 4832, Fax: +91 22 2817 1804	
MEP CONSULTANT		
MEPCON DESIGN STUDIO		
PROJECT		
NATIONAL CENTRE OF EXCELLENCE IN FOOTBALL @ RAJRAHAT, KOLKATA		
DRAWING TITLE		
COMPOUND WALL- TYPICAL SECTION & ELEVATION (NORTH SIDE)		
DWG. NO. TD.A.3.03	REV. NO. R0	NORTH
PROJECT NO. 18-P245	SCALE 1:20	
1 st ISSUED ON 28-09-2018	APPROVED RS	
CHECKED BY	DRAWN BY BD	

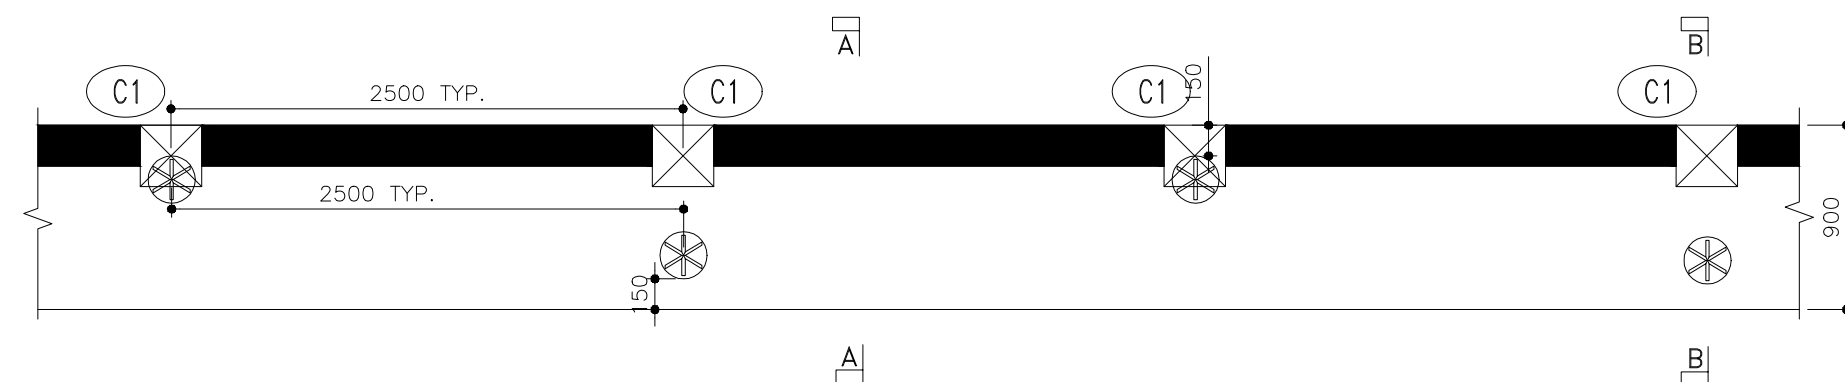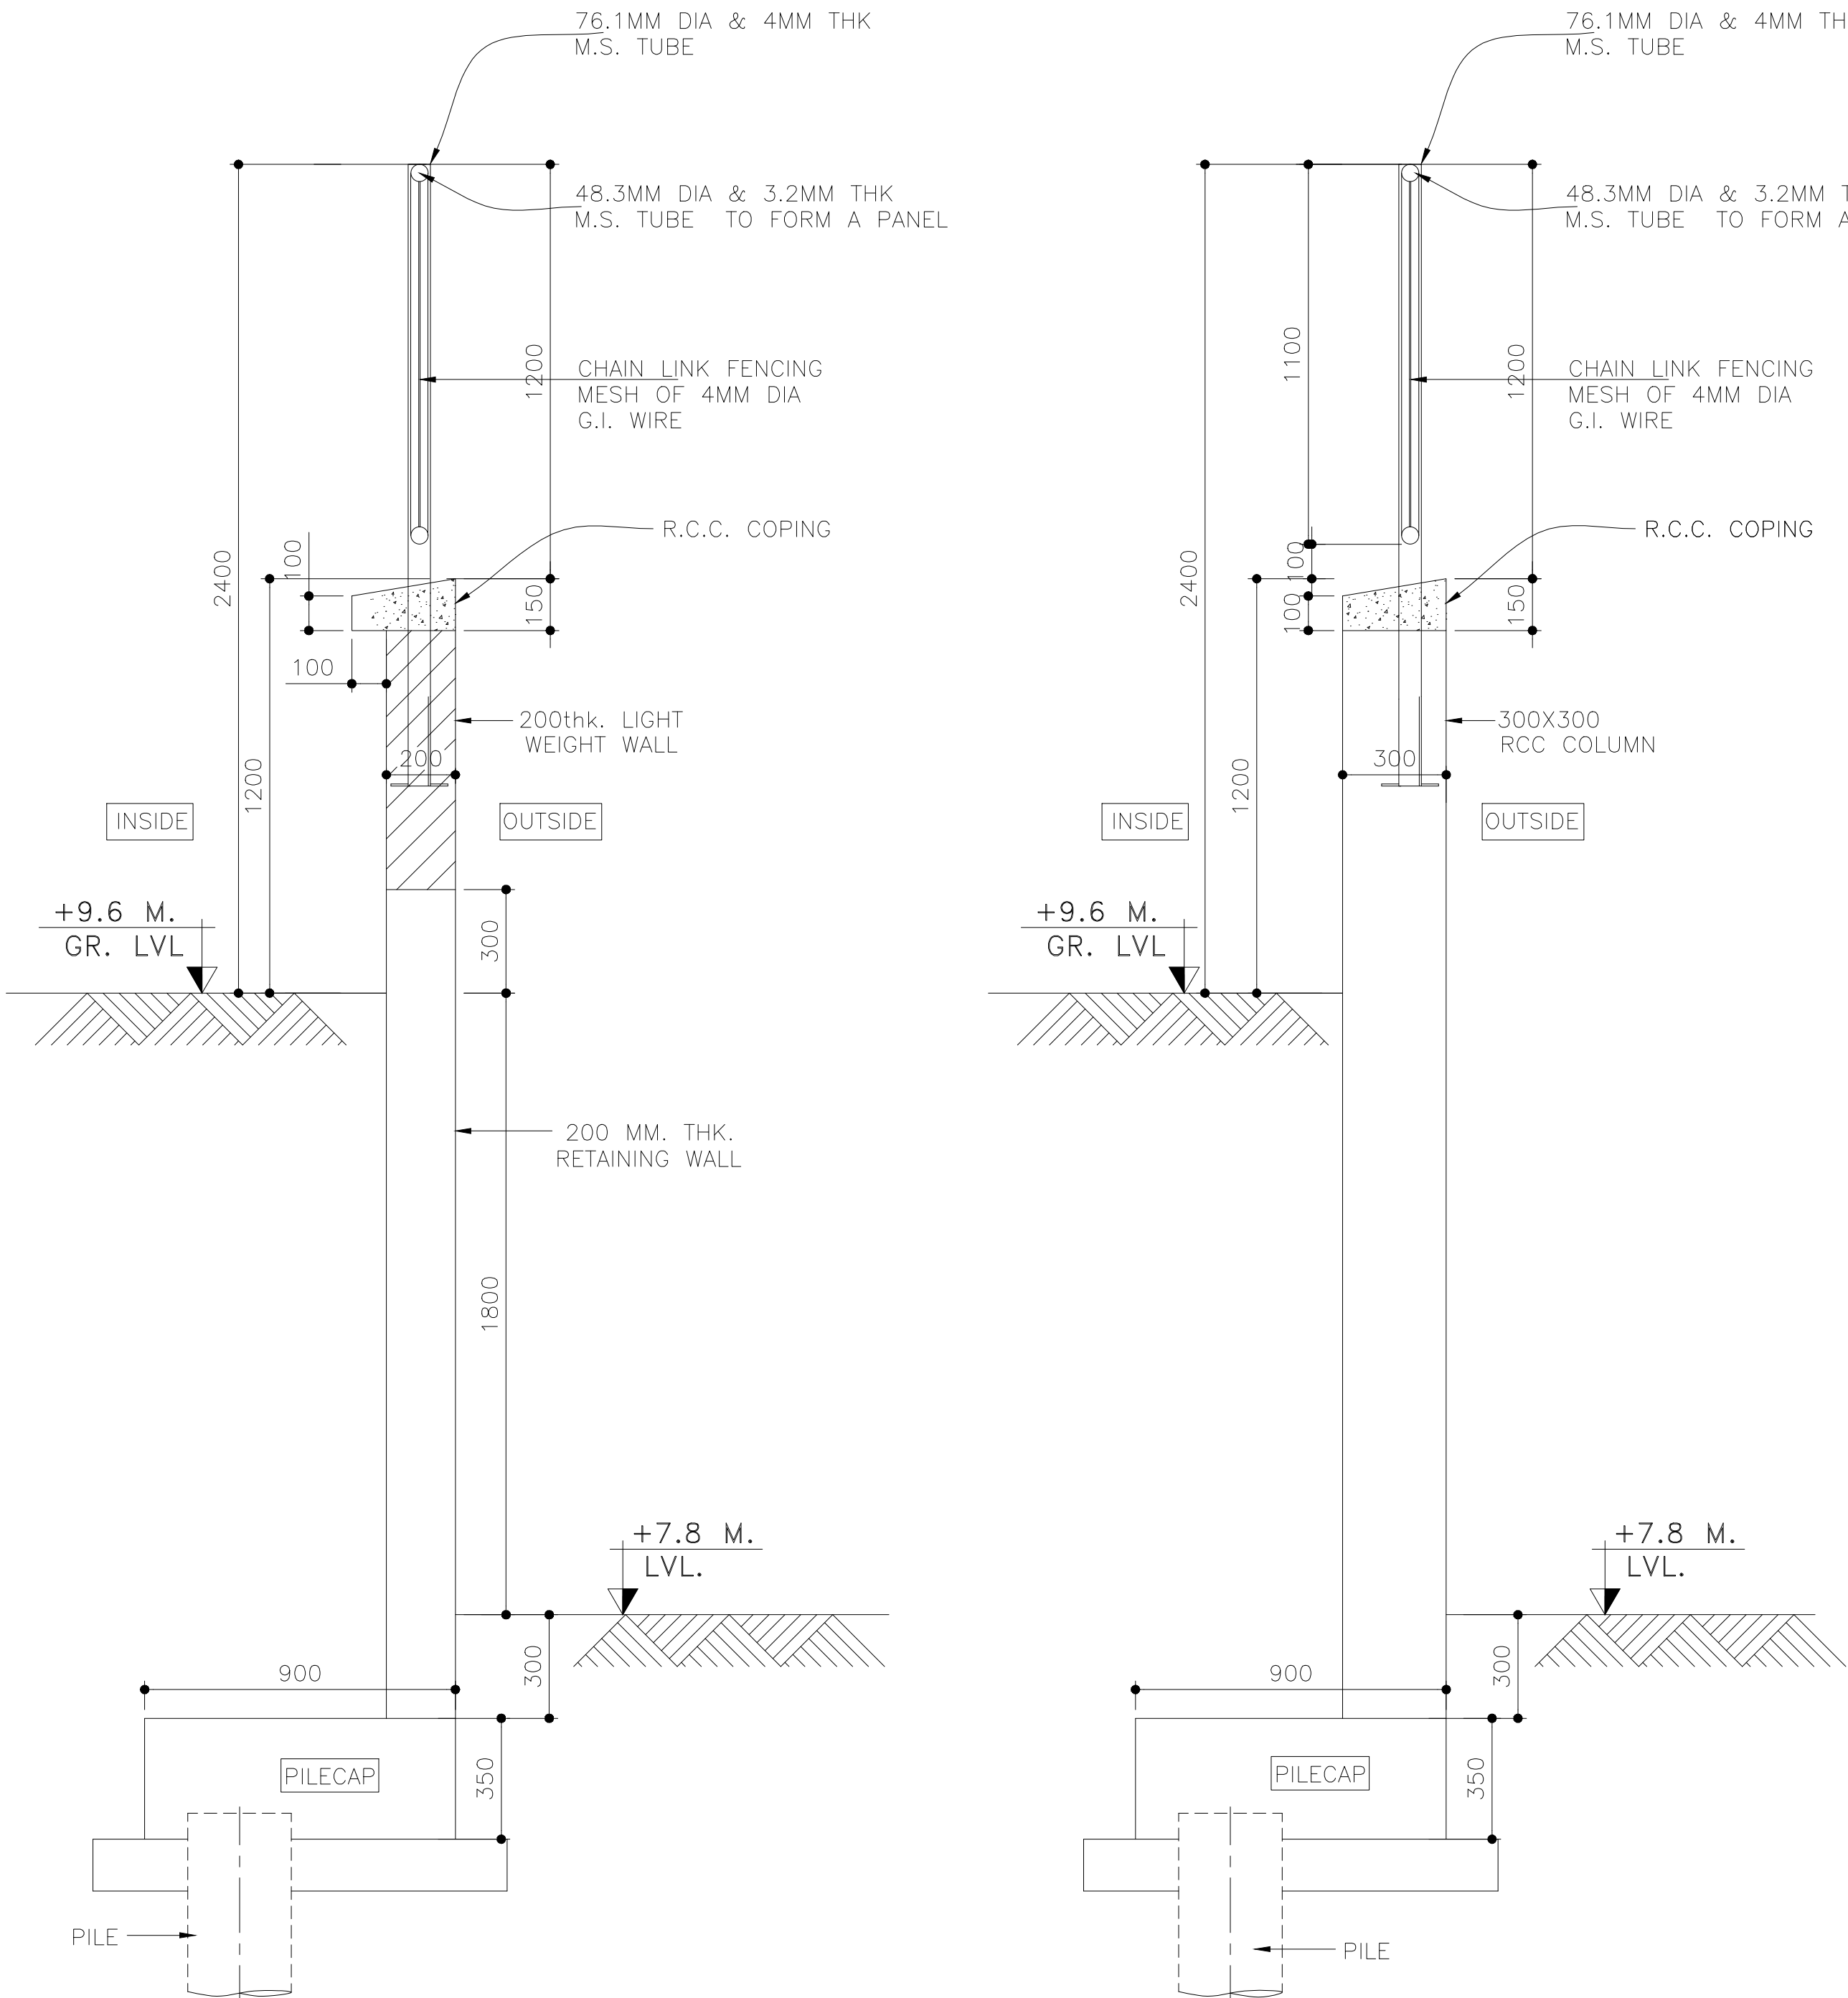




PART PLAN @ PILE FOUNDATION LAYOUT

PILE SCHEDULE:-

DIA OF PILES	NOS. OF VERT. BARS	LEGEND	SAFE WORKING LOAD OF PILE	GRADE	SPIRALS/HOOPS	NO. OF PILE	PILE LENGTH
230ø	5-10T		8 T	M25	8T@200c/c	400	2.5 M.

LEGEND

	COLUMN CONTINUOUS
	RETAINING WALL
	PILE

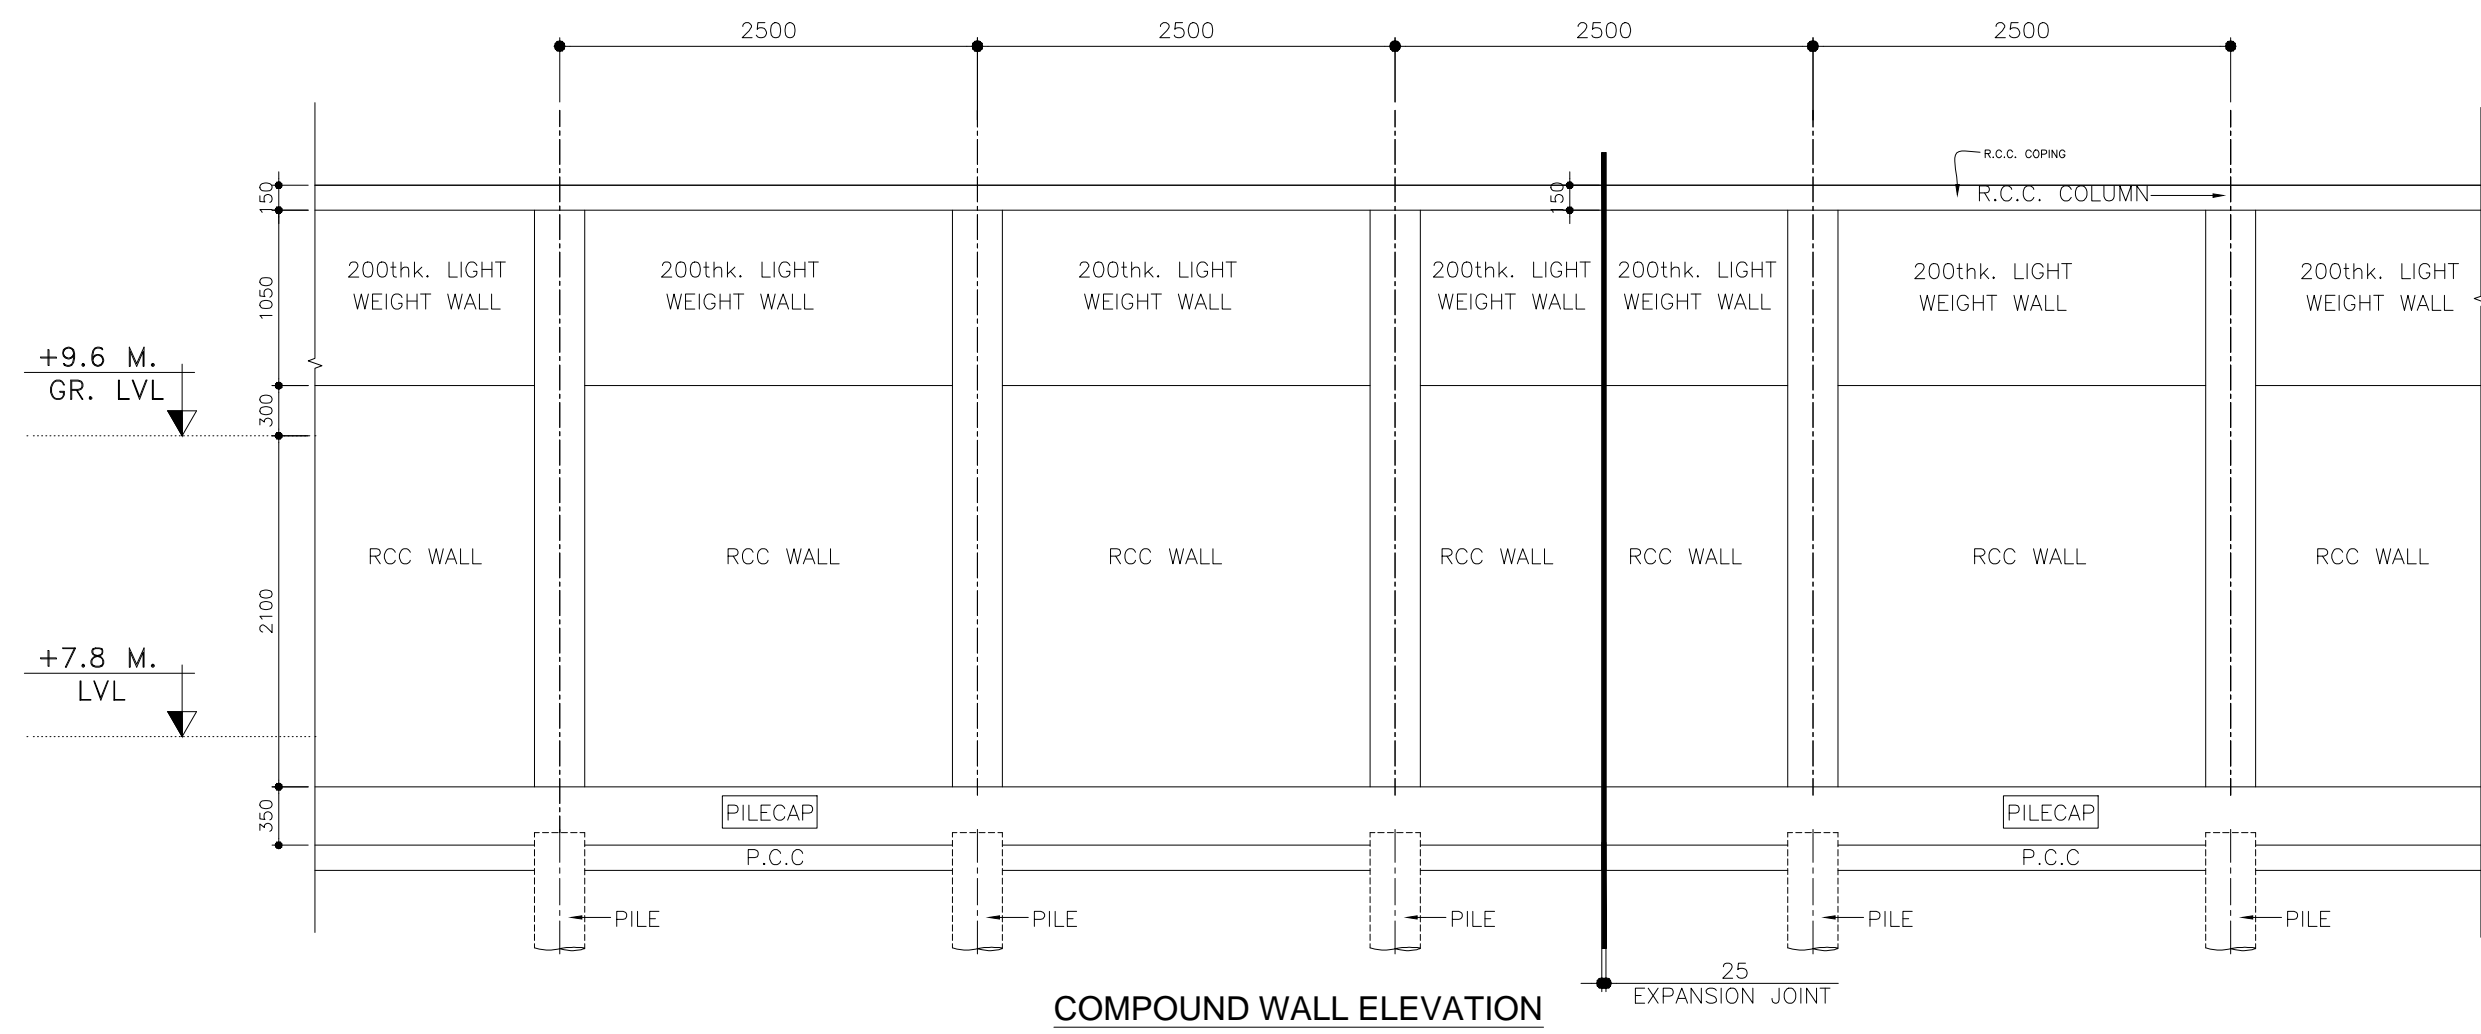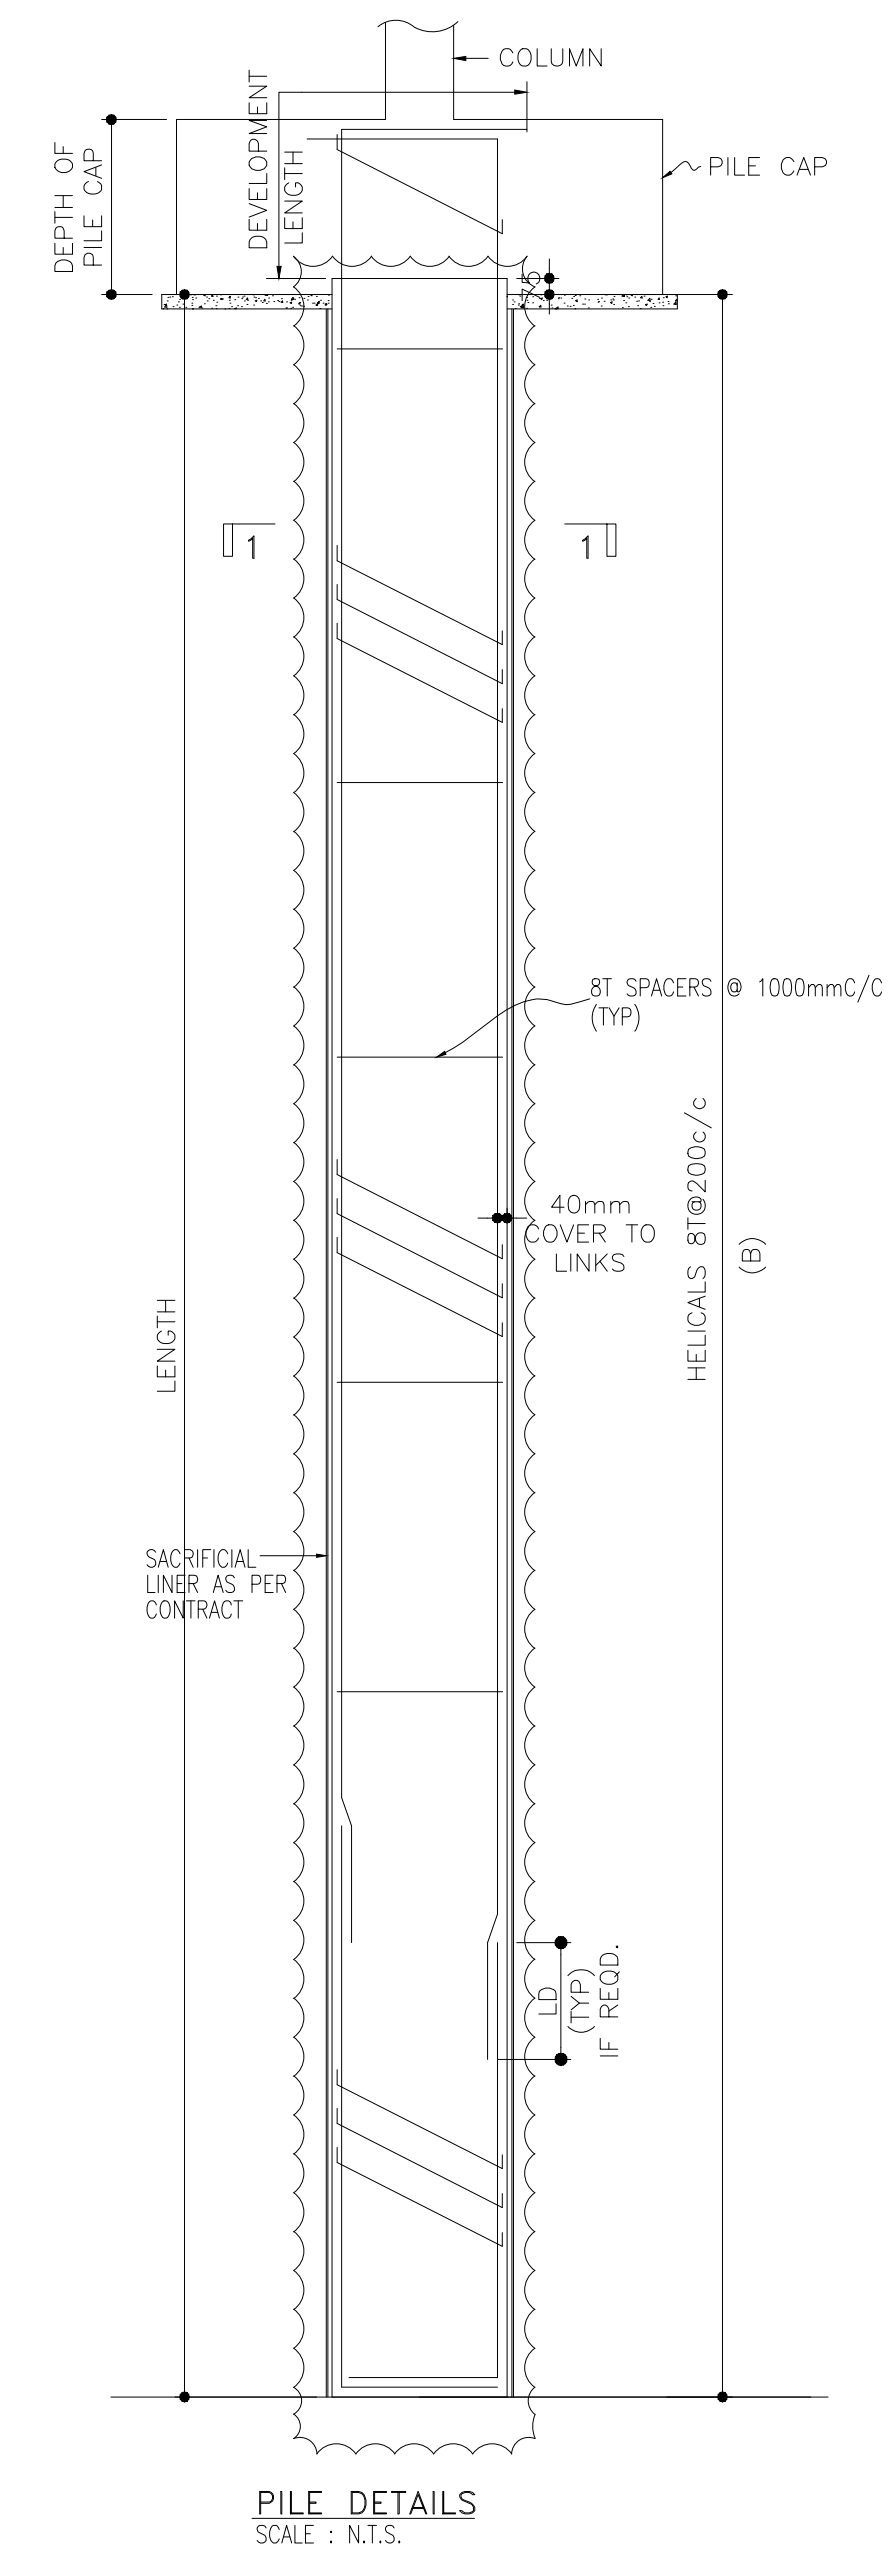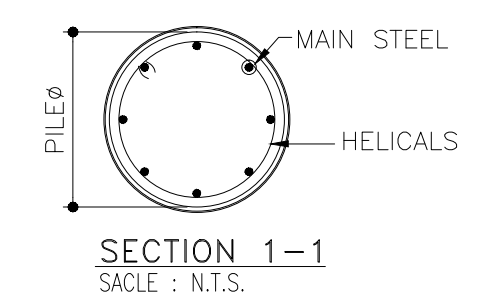

TENDER DRAWING

- GENERAL NOTES**
1. ALL DIMENSIONS IN MILLIMETERS AND LEVELS ARE IN METER UNLESS OTHERWISE SPECIFIED.
 2. ALL DIMENSIONS ARE TO BE CHECKED AND CO-RELATED WITH THE RELEVANT ARCHITECTURAL, STRUCTURAL AND SERVICES DRAWINGS AND ANY AMBIGUITY, DISCREPANCY OR OMISSION SHALL BE BROUGHT IN TO NOTICE OF ARCHITECT PRIOR TO COMMENCEMENT OF EXECUTION.
 3. DO NOT SCALE THE DRAWING, WRITTEN DIMENSION TO BE FOLLOWED.
 4. THIS DRAWING TO BE READ IN CONJUNCTION WITH THE RELEVANT SERVICES AND STRUCTURAL DRAWINGS.

REV	DESCRIPTION	DATE

KEY PLAN

CLIENT

ALL INDIA FOOTBALL FEDERATION

ARCHITECT

Architecture | Interiors | PMC | EPC
COLLAGE DESIGN PVT. LTD.
300 Sai Sampada, Station Rd
Vikhroli East, Mumbai - 400 083
T +91 22 2574 0844 / 45 F +91 22 2574 0846
E info@collagedesign.net
collagedesign.net

STRUCTURAL CONSULTANT

Shanghvi and Associates
Consultants Pvt.Ltd.
7th Floor, Patravadi Heights,
Shradhdham Road,Vile Parle (E),
Mumbai - 400057.
Tel. +91 22 2514 4832, Fax. +91
22 2817 1804

MEP CONSULTANT

MEPCON DESIGN STUDIO


PROJECT

NATIONAL CENTRE OF EXCELLENCE
IN FOOTBALL @ RAJRAHAT, KOLKATA

DRAWING TITLE

COMPOUND WALL-
STRUCTURAL DETAILS

DWG. NO.	REV. NO.
TD.S.3.01	R0
PROJECT NO.	18-P245
SCALE	NORTH
1 st ISSUED ON	28-09-2018
APPROVED	
CHECKED BY	
DRAWN BY	

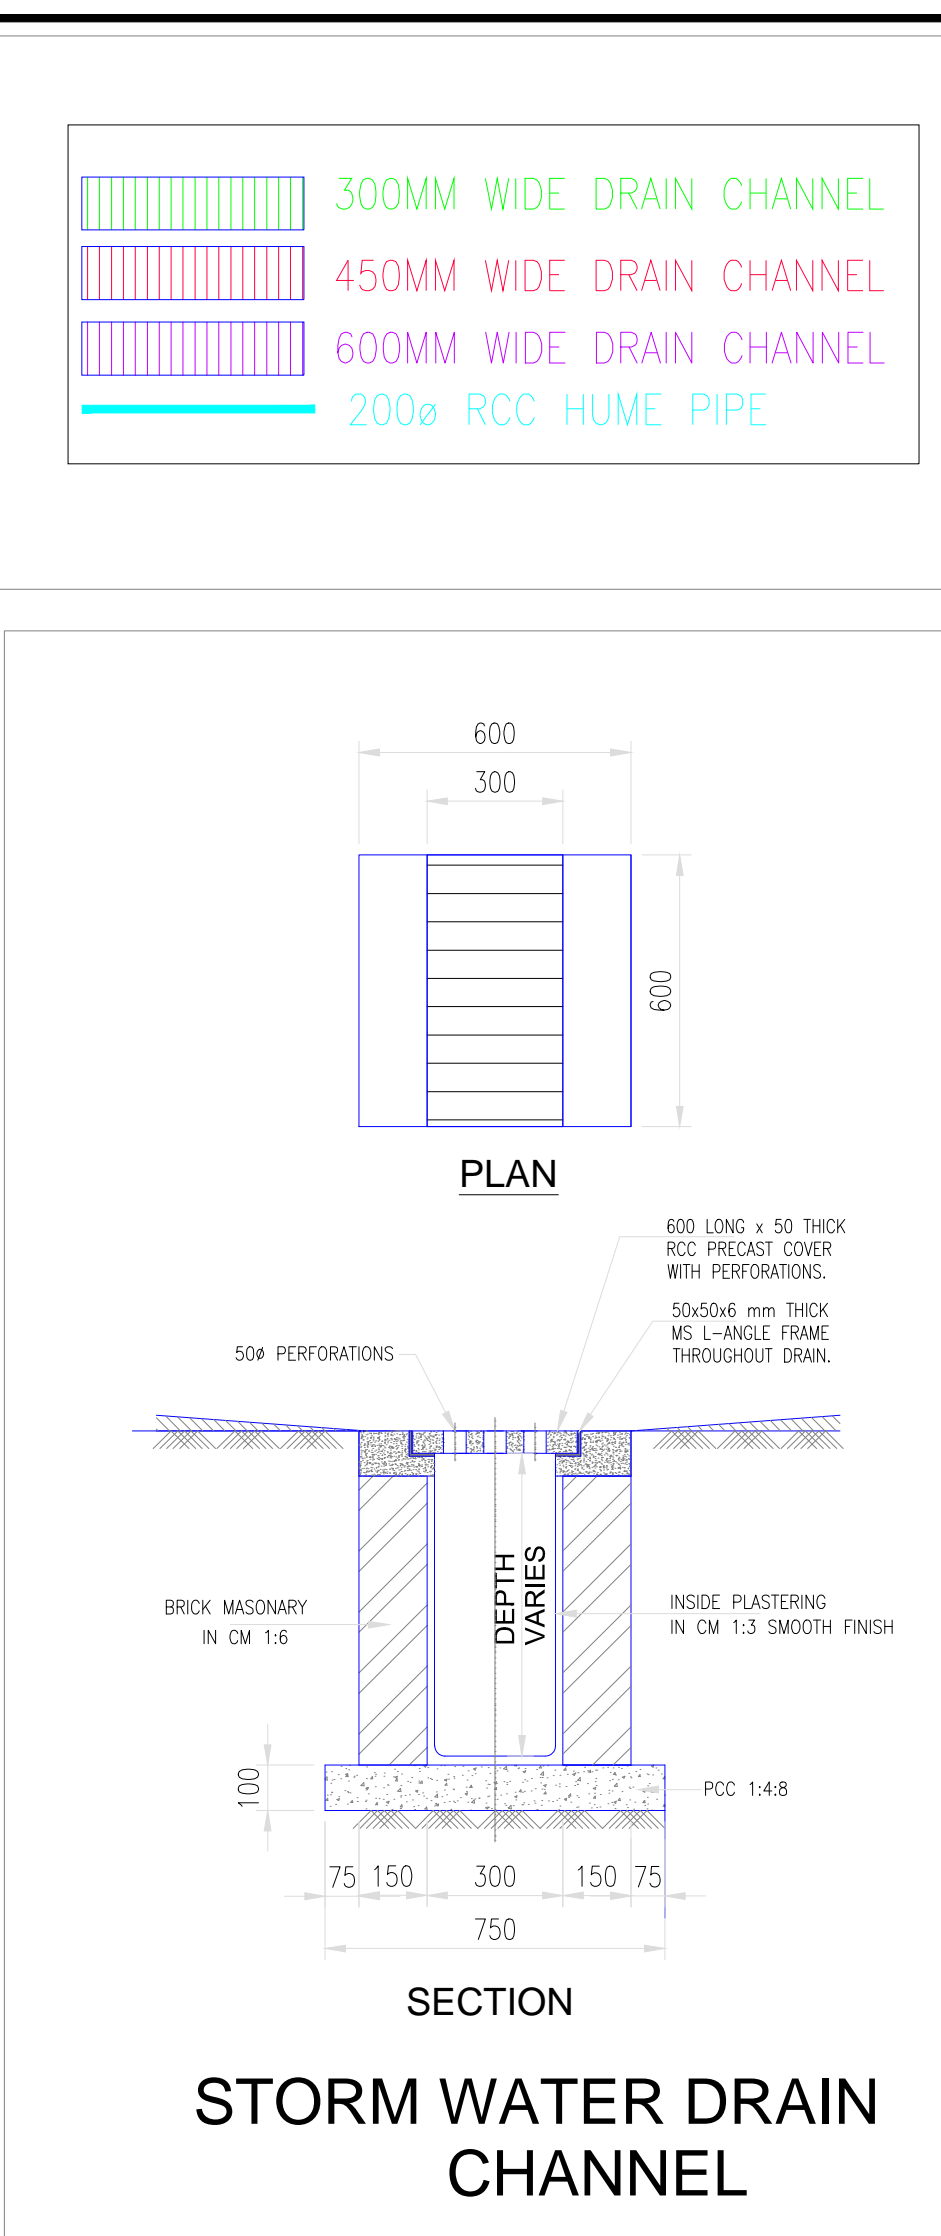[illegible]