




NATIONAL CENTRE OF EXCELLENCE IN FOOTBALL @RAJRAHAT, KOLKATA

TENDER DRAWINGS-PHASE 1

- ARCHITECTURAL
- STRUCTURE
- MEP

TENDER DRAWINGS LIST-02		
SR. NO.	DRAWINGS	DRAWING NO
ARCHITECTURAL PACKAGE		
SR. NO.	DRAWINGS	DRAWING NO
SITE		
1	SITE SURVEY PLAN	TD.A.0.01
2	SITE DEVELOPMENT LAYOUT	TD.A.0.02
3	U.G.TANK DETAILS	TD.P.4.01
STRUCTURAL PACKAGE		
4	U.G.TANK DETAILS	TD.S.4.02
5	U.G.TANK DETAILS	TD.S.4.02-A

CLIENT :	ARCHITECT :
	

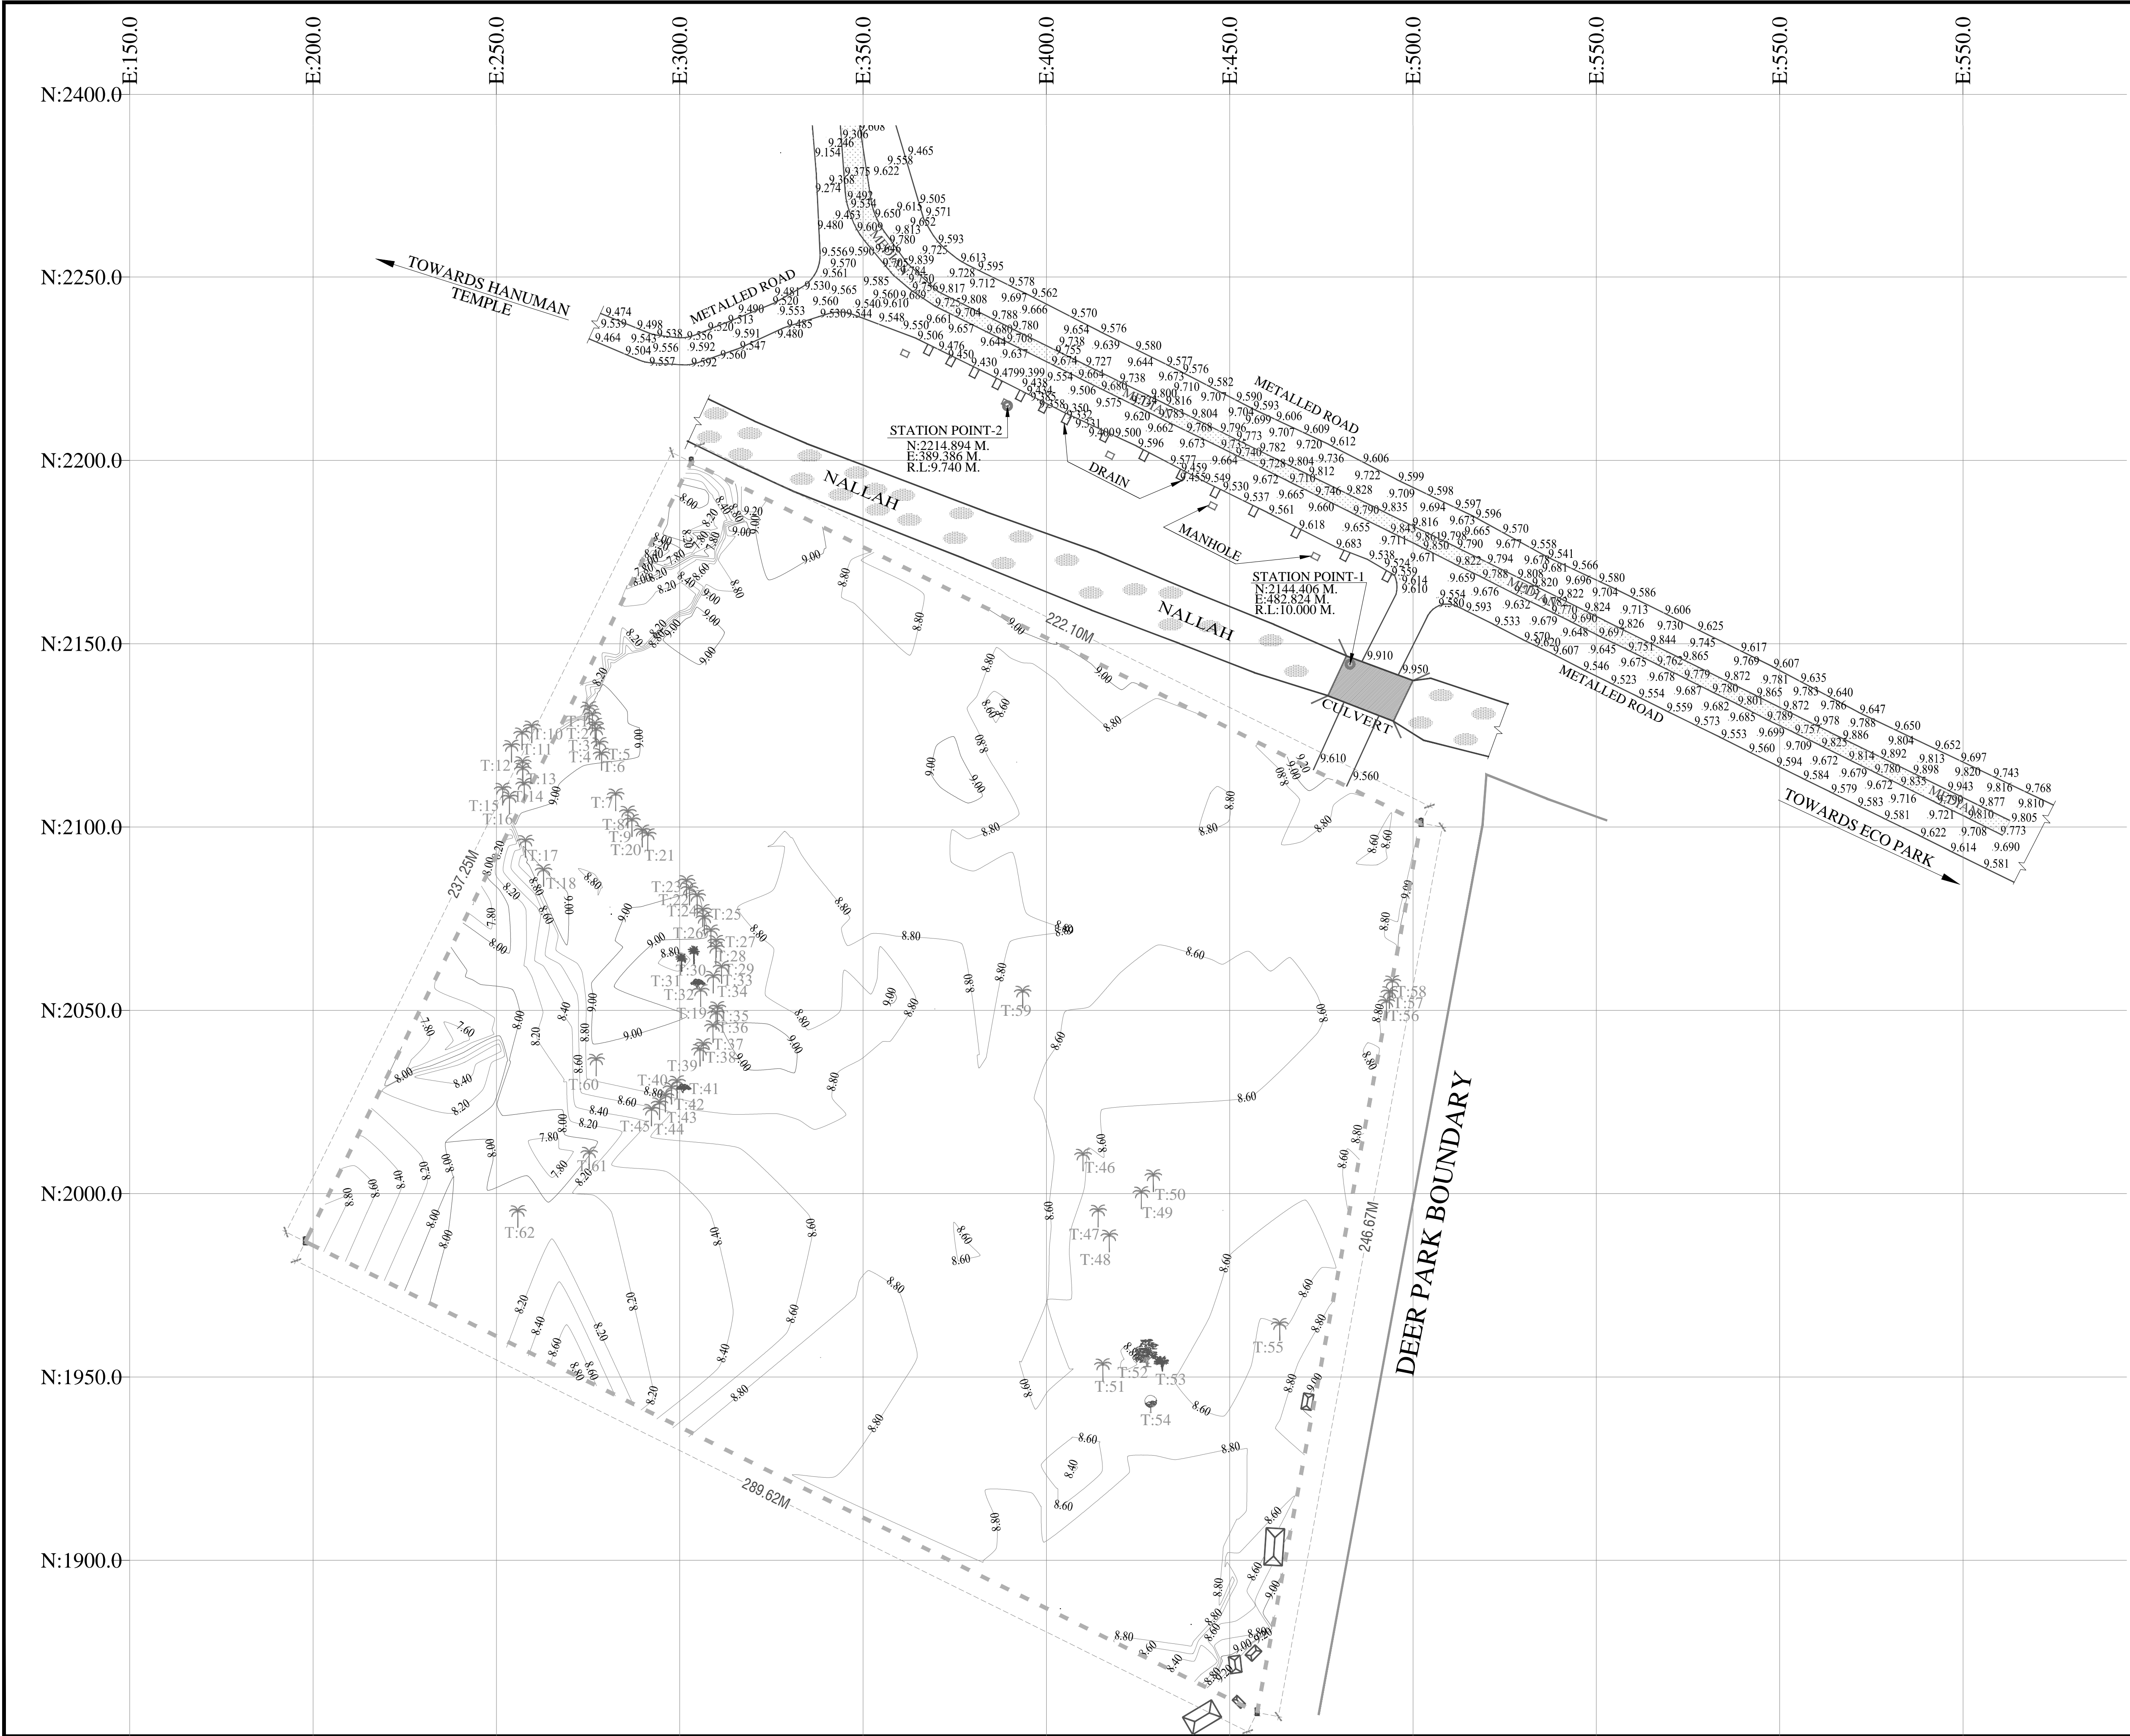

TENDER DRAWING

GENERAL NOTES

1. ALL DIMENSIONS IN MILLIMETERS AND LEVELS ARE IN METER UNLESS OTHERWISE SPECIFIED.
2. ALL DIMENSIONS ARE TO BE CHECKED AND CO-RELATED WITH THE RELEVANT ARCHITECTURAL, STRUCTURAL AND SERVICES DRAWINGS AND ANY AMBIGUITY, DISCREPANCY OR OMISSION SHALL BE BROUGHT IN TO NOTICE OF ARCHITECT PRIOR TO COMMENCEMENT OF EXECUTION.
3. DO NOT SCALE THE DRAWING, WRITTEN DIMENSION TO BE FOLLOWED.
4. THIS DRAWING TO BE READ IN CONJUNCTION WITH THE RELEVANT SERVICES AND STRUCTURAL DRAWINGS.

REVISIONS

REV	DESCRIPTION	DATE

KEY PLAN

CLIENT

ALL INDIA FOOTBALL FEDERATION

ARCHITECT

Architecture | Interiors | PMC | EPC
COLLAGE DESIGN PVT. LTD.
300 Sai Sampada, Station Rd
Vikhroli East, Mumbai - 400 083
T +91 22 2574 0844 / 45 F +91 22 2574 0846
E info@collagedesign.net
collagedesign.net

STRUCTURAL CONSULTANT

Shanghvi and Associates
Consultants Pvt. Ltd.
7th Floor, Patravali Heights,
Shradhdham Road, Vile Parle (E),
Mumbai - 400057.
Tel : +91 22 2514 4832, Fax : +91
22 2817 1804

MEP CONSULTANT

MEPCON DESIGN STUDIO

PROJECT


NATIONAL CENTRE OF EXCELLENCE
IN FOOTBALL @ RAJRAHAT, KOLKATA

DRAWING TITLE

SURVEY PLAN

DWG. NO.	REV. NO.
TD.A.0.01	R0
PROJECT NO.	
SCALE	
1"=ISSUED ON	
APPROVED	
CHECKED BY	
DRAWN BY	


THIS DRAWING IS A PROPERTY OF COLLAGE DESIGN PVT. LTD. AND IS NOT TO BE REPRODUCED OR USED FOR ANY OTHER PURPOSE THAN FOR WHICH IT HAS BEEN LOANED.

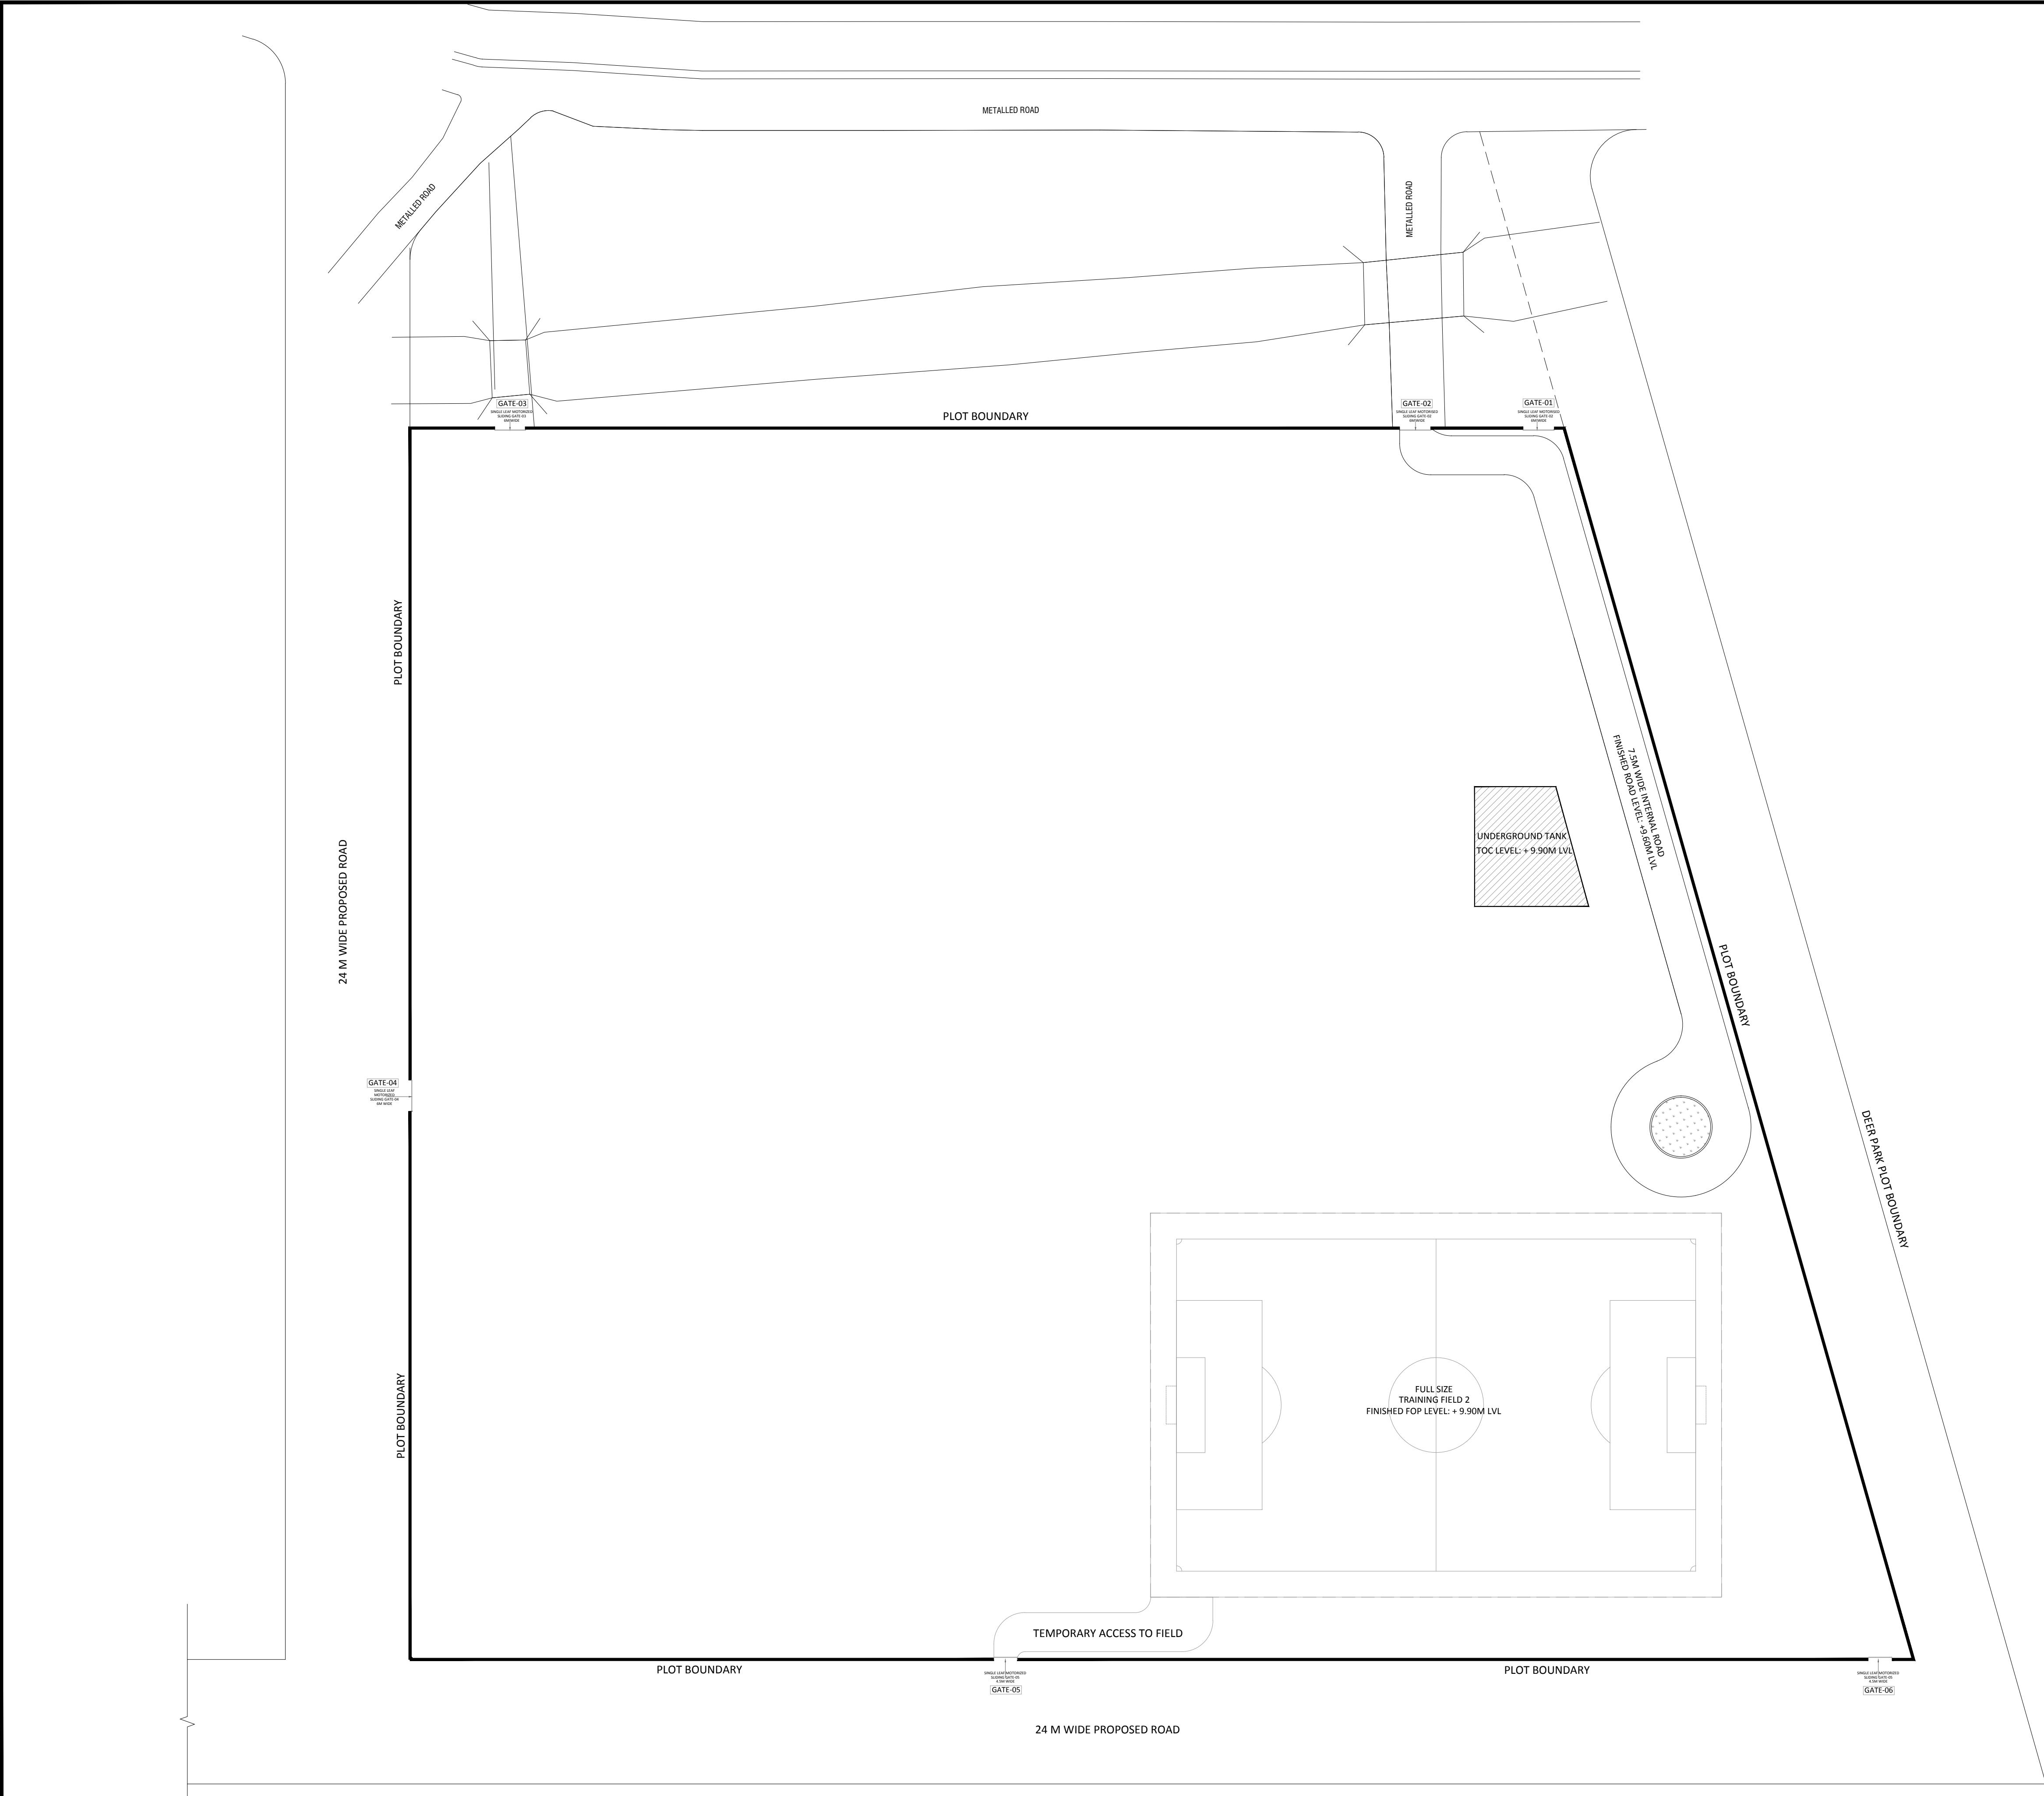

TENDER DRAWING

- GENERAL NOTES**
1. ALL DIMENSIONS ARE IN MILLIMETERS AND LEVELS ARE IN METER UNLESS OTHERWISE SPECIFIED.
 2. ALL DIMENSIONS ARE TO BE CHECKED AND CO-RELATED WITH THE RELEVANT ARCHITECTURAL, STRUCTURAL AND SERVICES DRAWINGS AND ANY AMBIGUITY, DISCREPANCY OR OMISSION SHALL BE BROUGHT IN TO NOTICE OF ARCHITECT PRIOR TO COMMENCEMENT OF EXECUTION.
 3. DO NOT SCALE THE DRAWING, WRITTEN DIMENSION TO BE FOLLOWED.
 4. THIS DRAWING TO BE READ IN CONJUNCTION WITH THE RELEVANT SERVICES AND STRUCTURAL DRAWINGS.

REVISIONS		
REV	DESCRIPTION	DATE

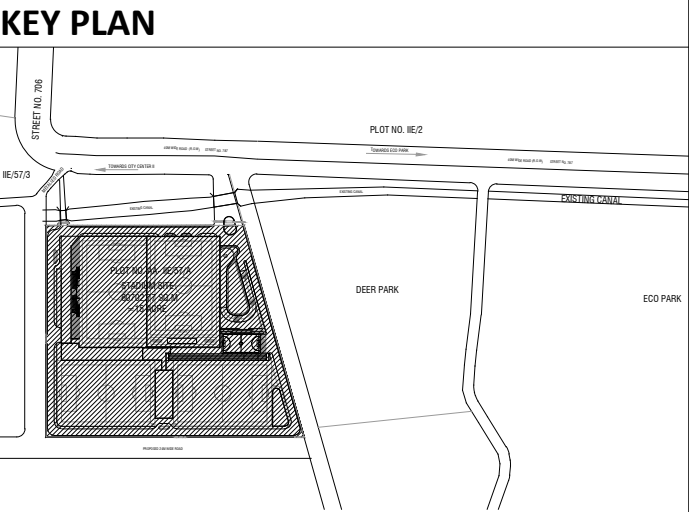

CLIENT

 **ALL INDIA FOOTBALL FEDERATION**
Football House, Sector 19, Phase 1,
Dwarka, New Delhi: 110075
Tel- 91-11-25308200/ 201
Fax- 91-11-25308234/ 25308236
Email- aiff@the-aiff.com

ARCHITECT

 **collage design**
ARCHITECTURE | INTERIORS | PMC
COLLAGE DESIGN PVT. LTD
300, Sai Sampanna, Station Rd
Vikhroli East, Mumbai 400 083
+91 22 2574 0842 / 43 / 44 / 45
www.collagedesign.net

STRUCTURAL CONSULTANT

 
 **SACPL**
Shanghvi and Associates Consultants Pvt.Ltd.
7th Floor, Padmavati Heights,
Shradhdhanand Road,Vile Parle (E),
Mumbai - 400057.
Tel - +91 22 2614 4832, Fax - +91 22 2617 1804







PROJECT

NATIONAL CENTRE OF EXCELLENCE
IN FOOTBALL @ RAJRAHAT, KOLKATA

DRAWING TITLE

**SITE DEVELOPMENT LAYOUT
PHASE-1**

DWG. NO.		REV. NO.
TD.A.0.02		R0
PROJECT NO.	18-P245	
SCALE		NORTH
1 ST ISSUED ON	28-09-2018	
APPROVED	RS	
CHECKED BY		
DRAWN BY	BD	

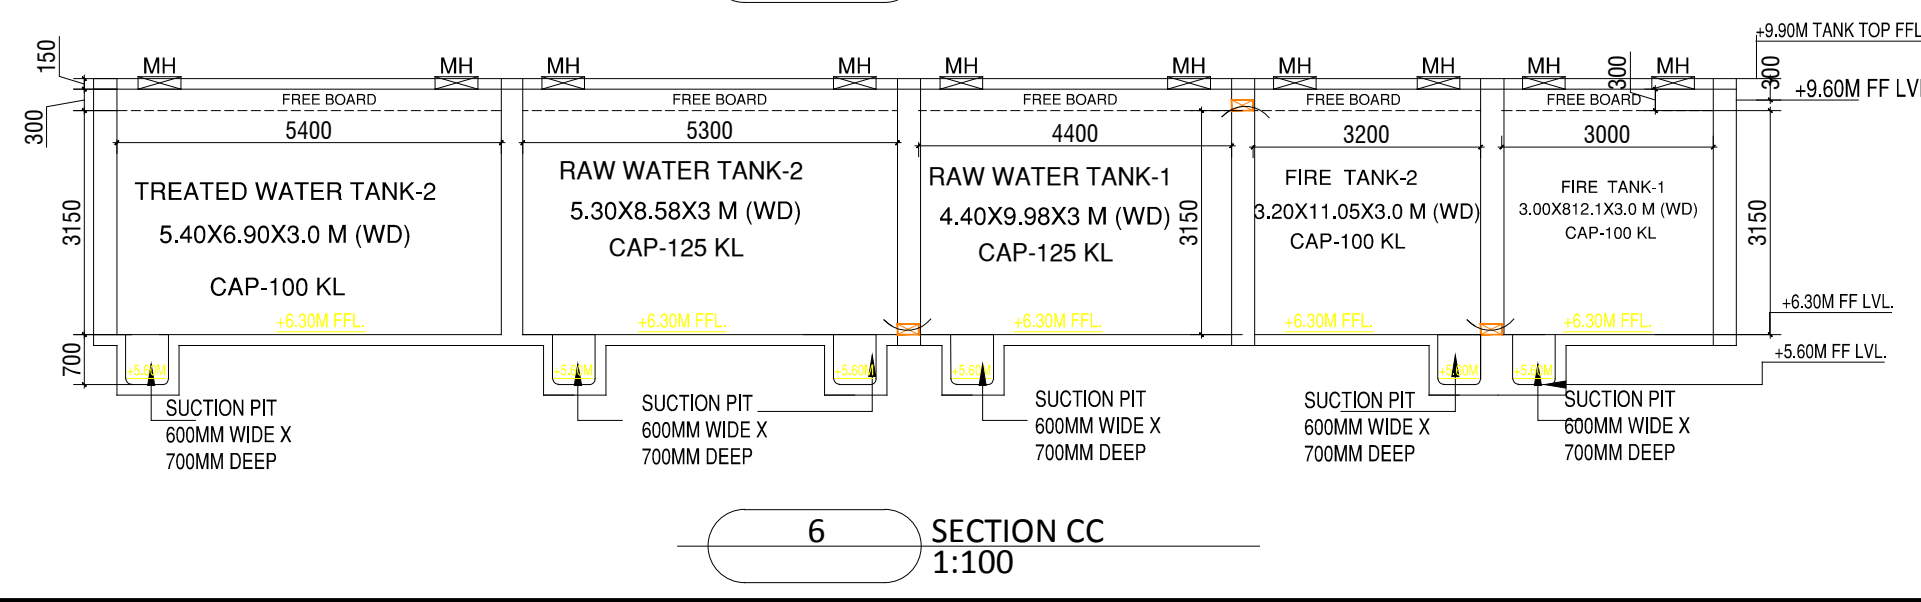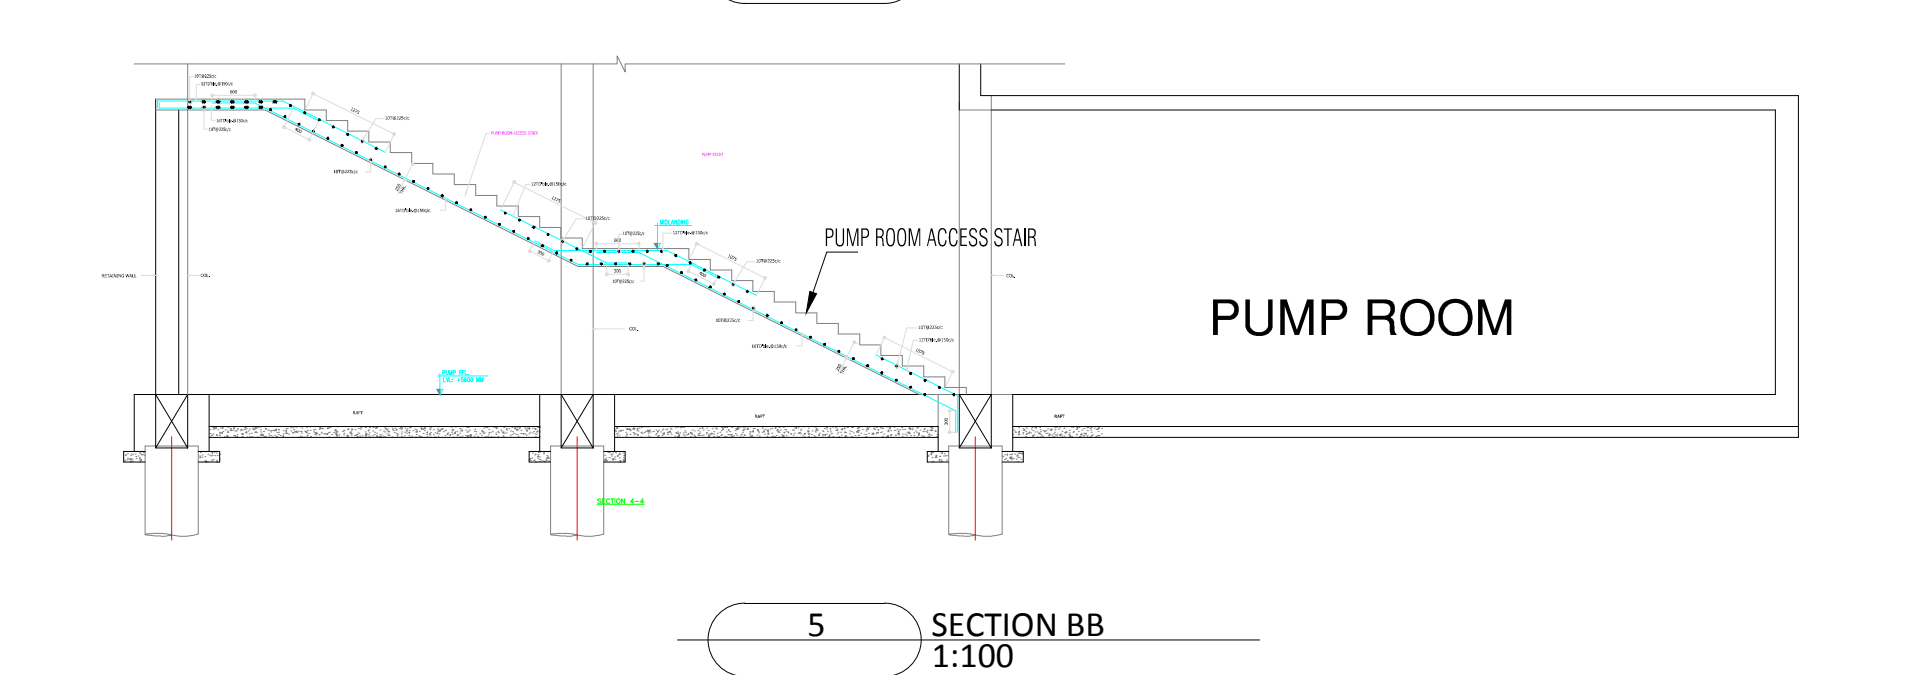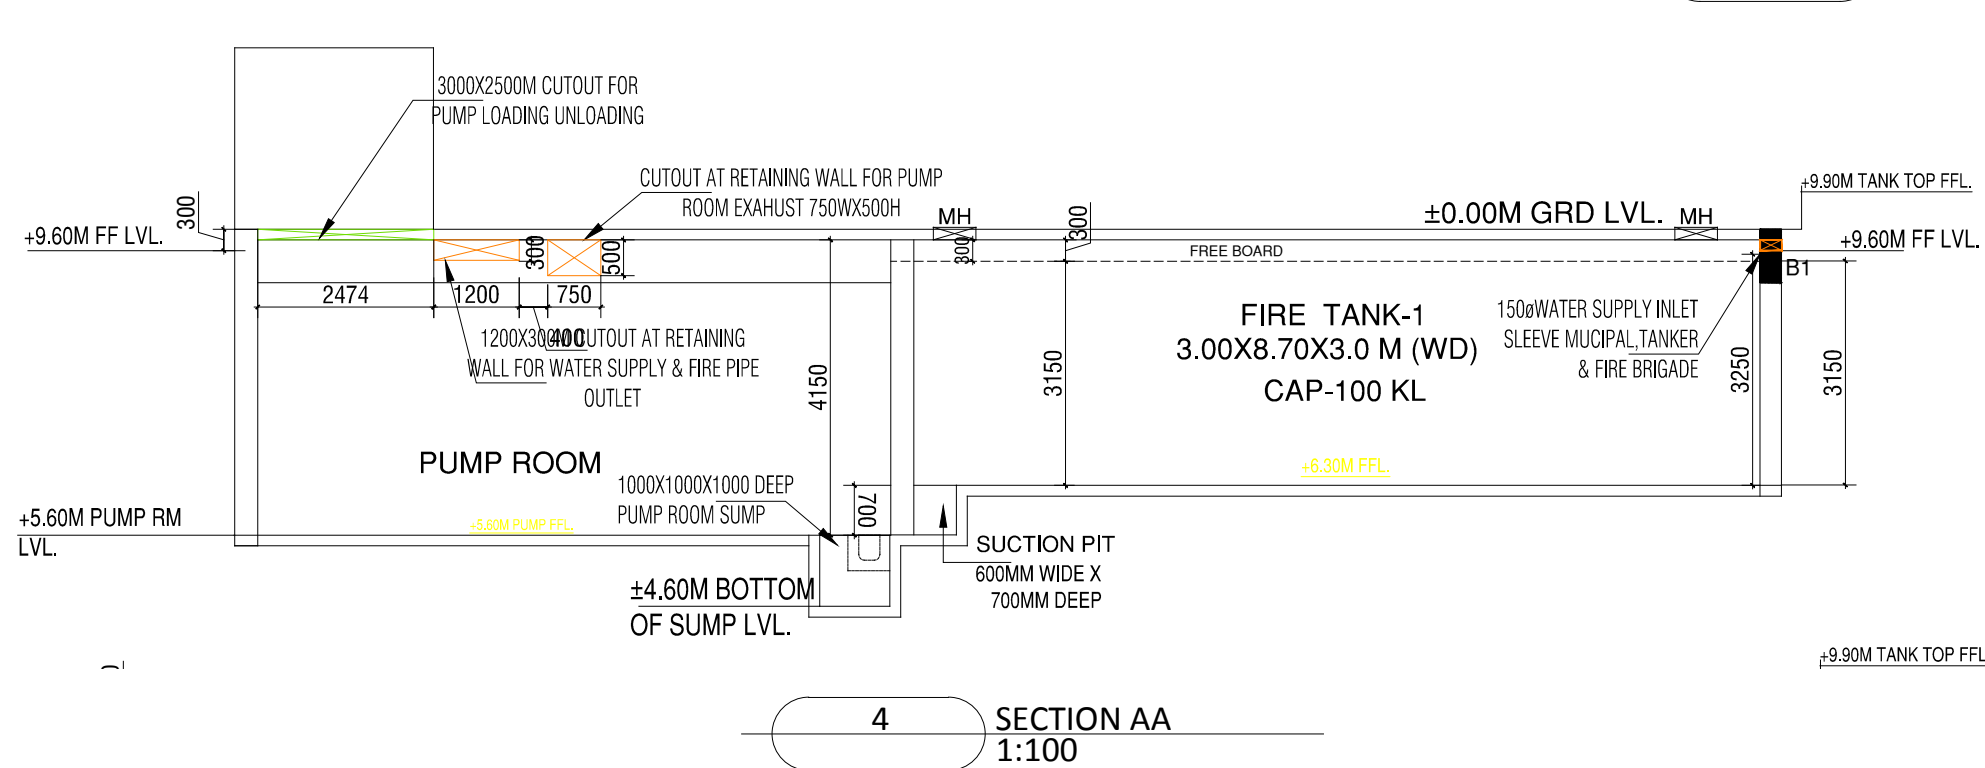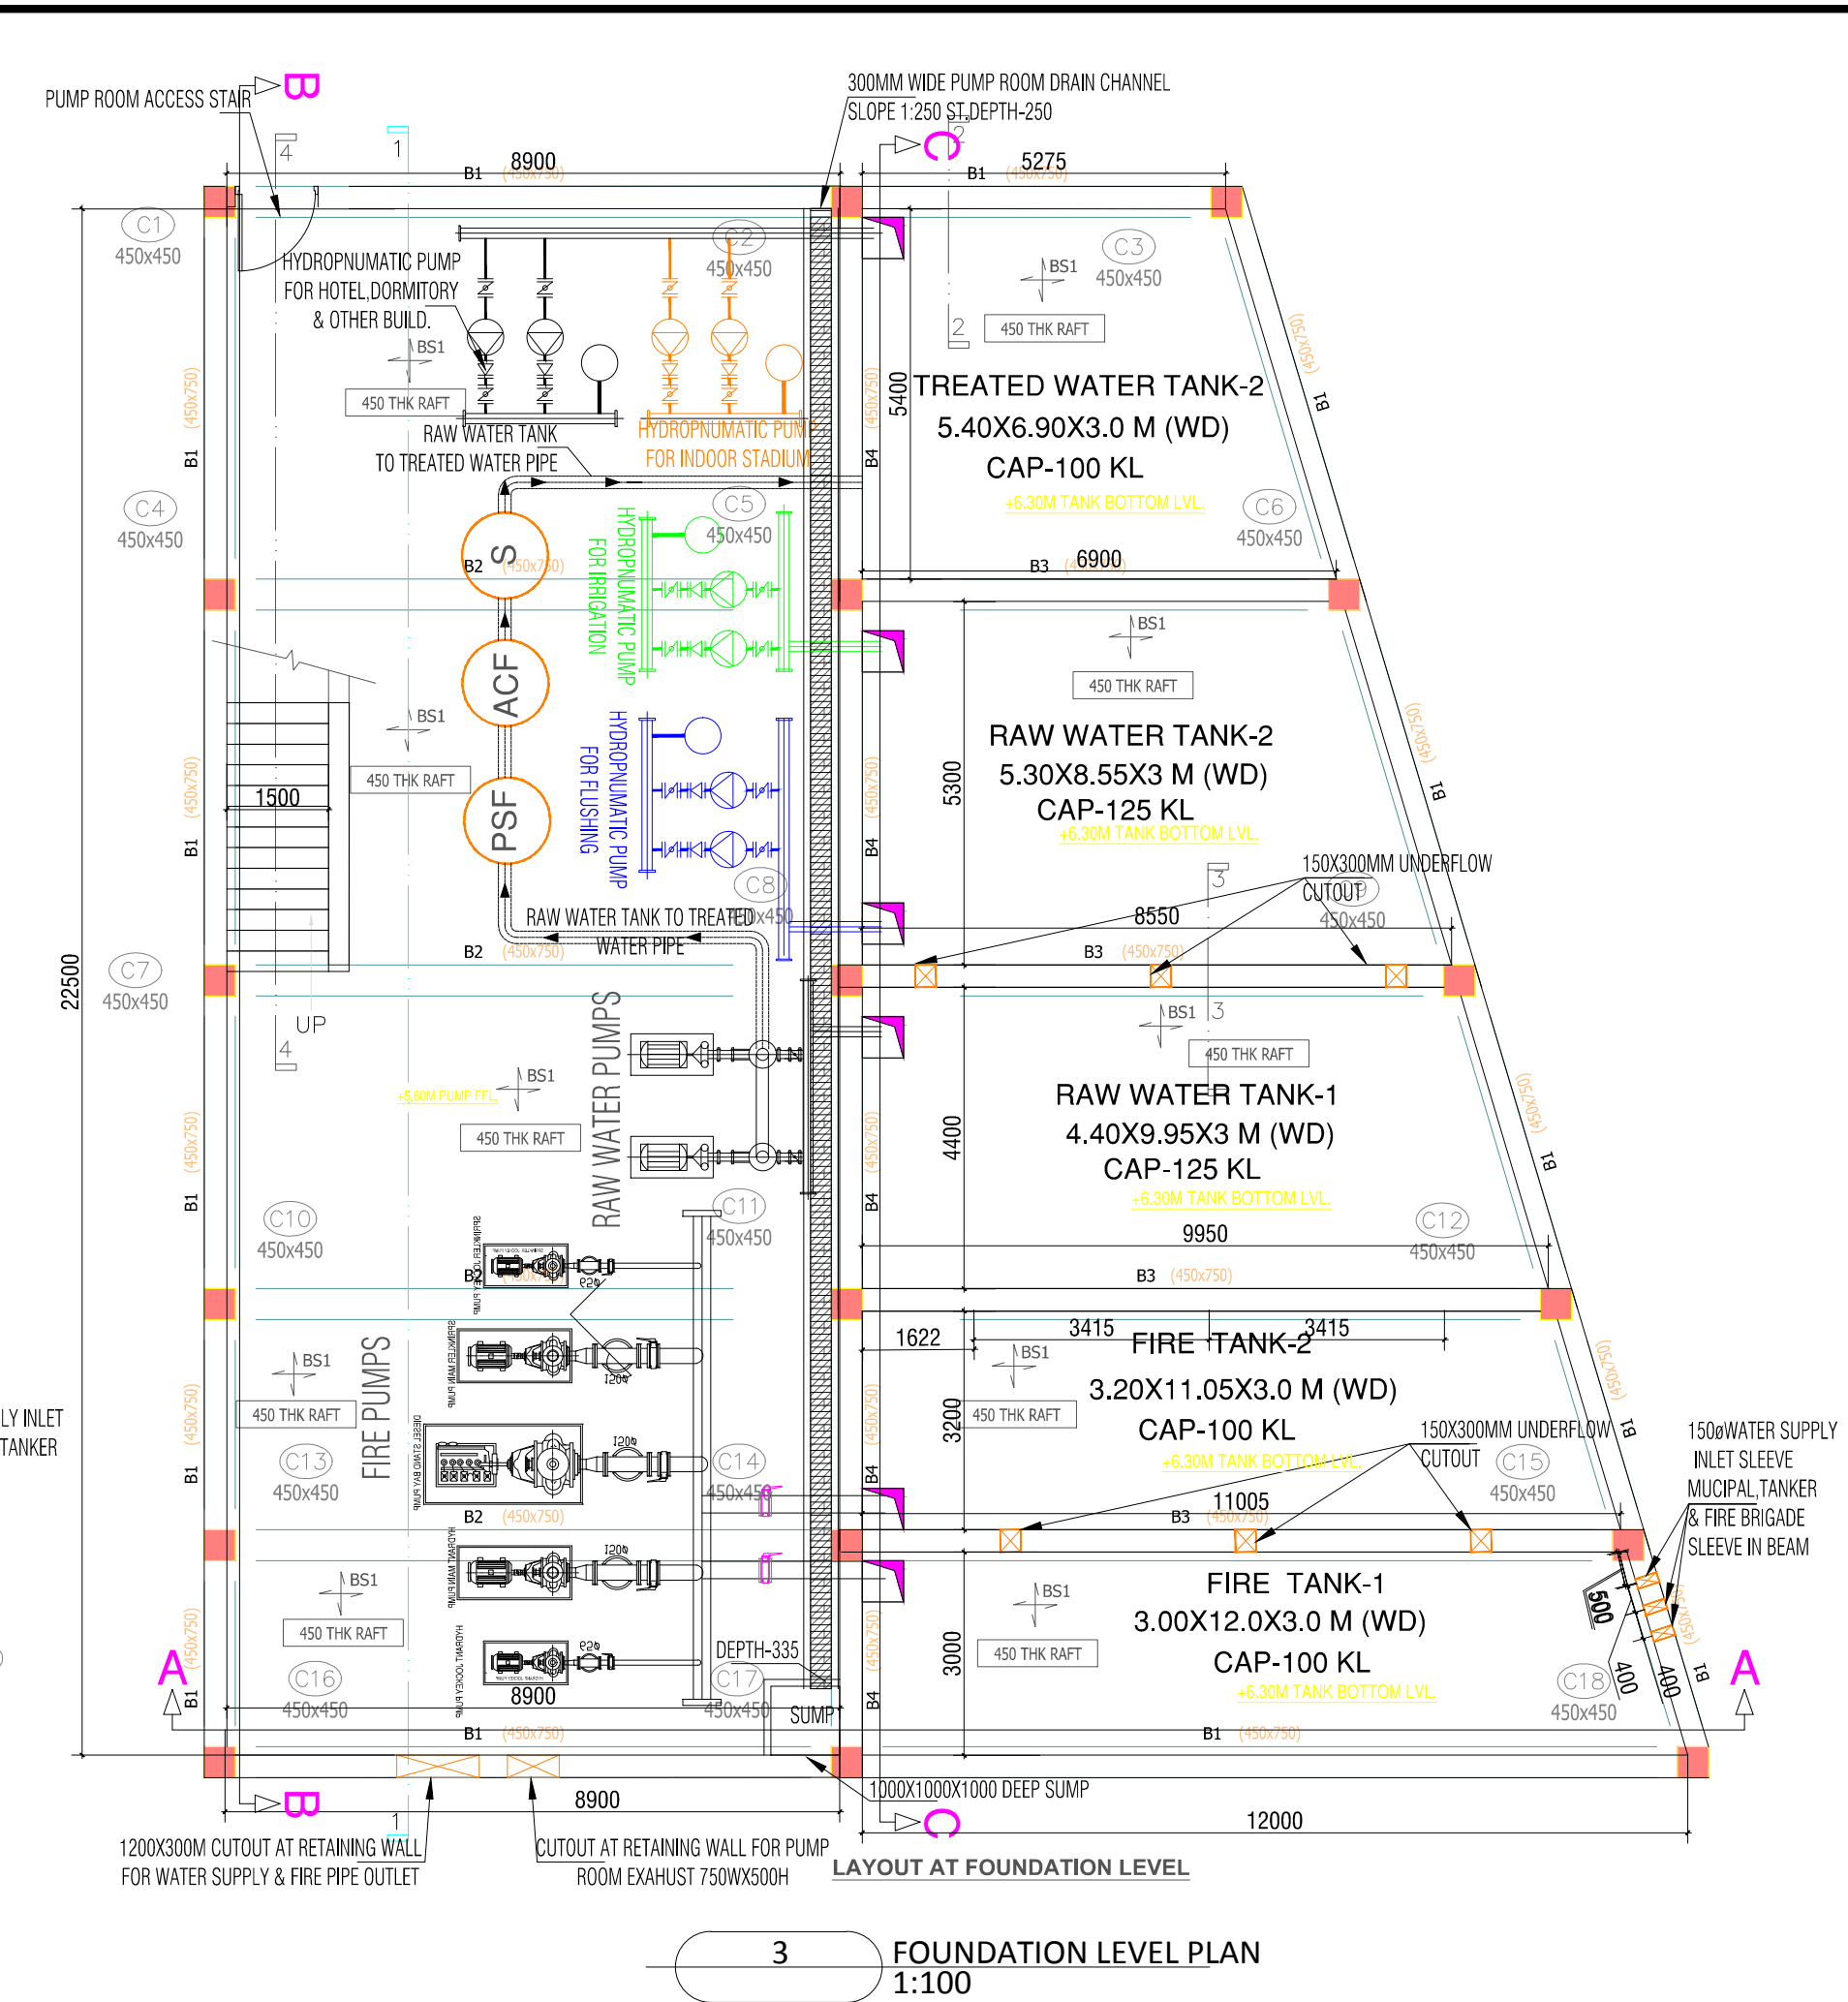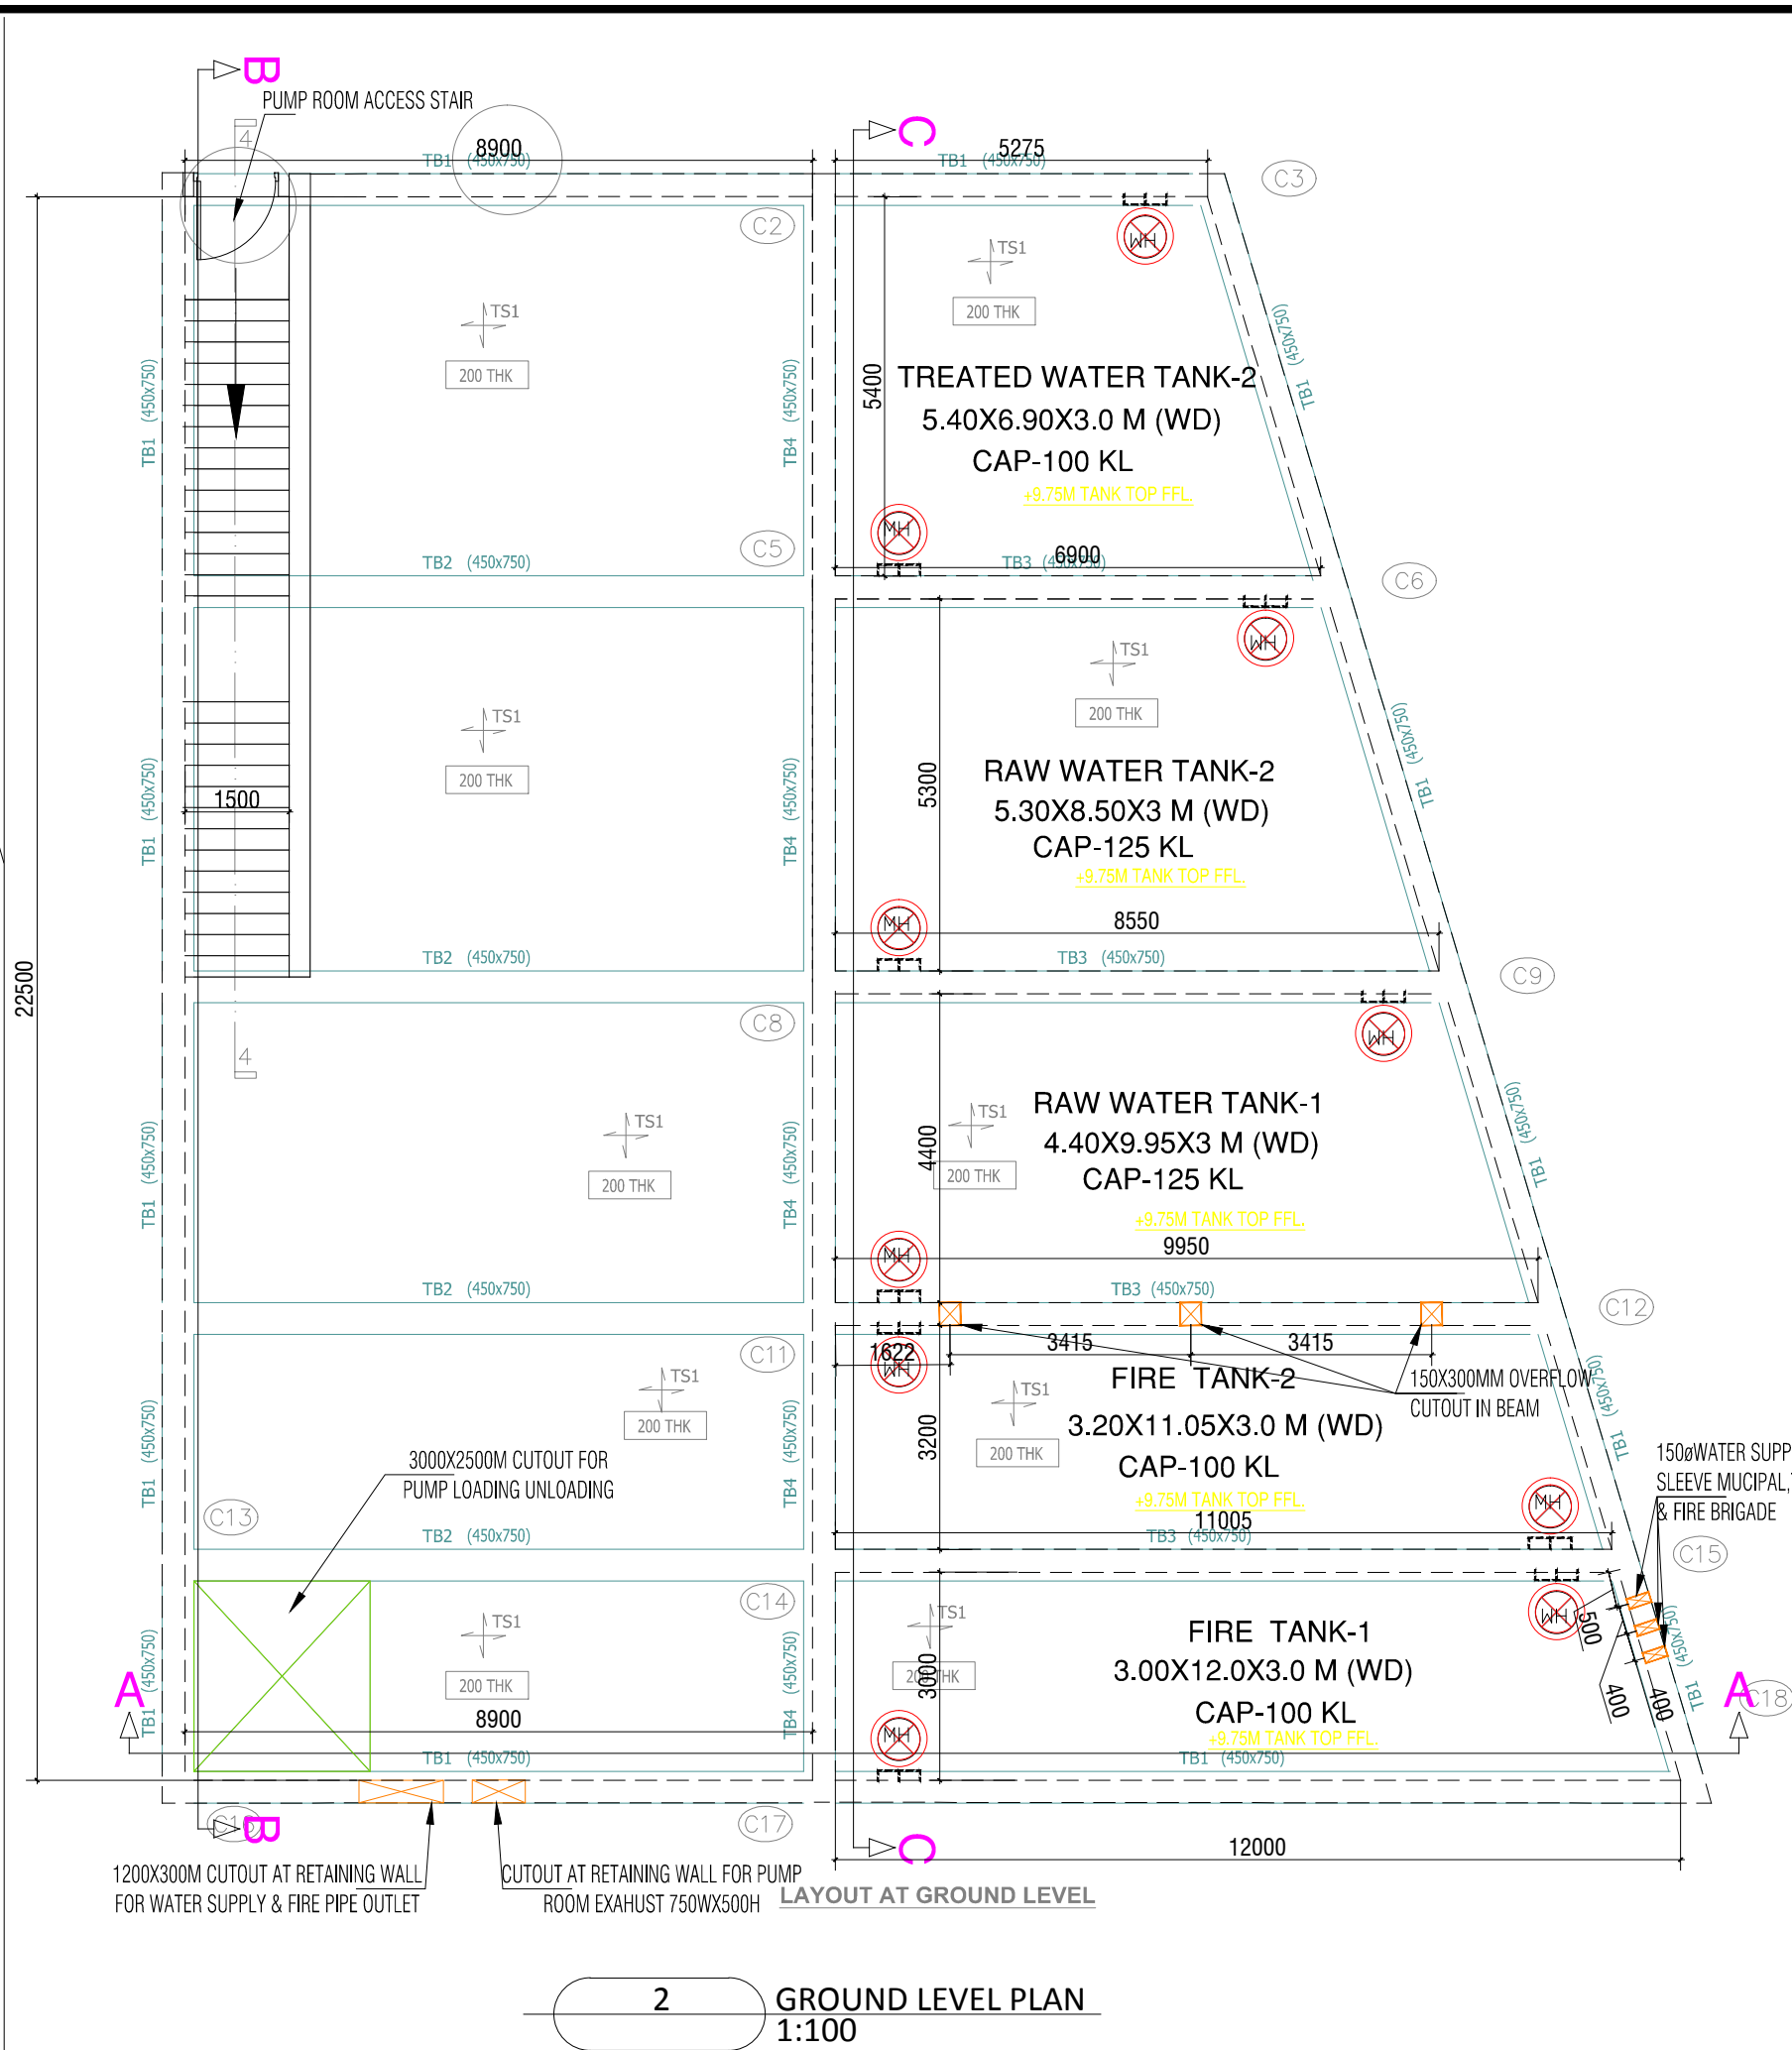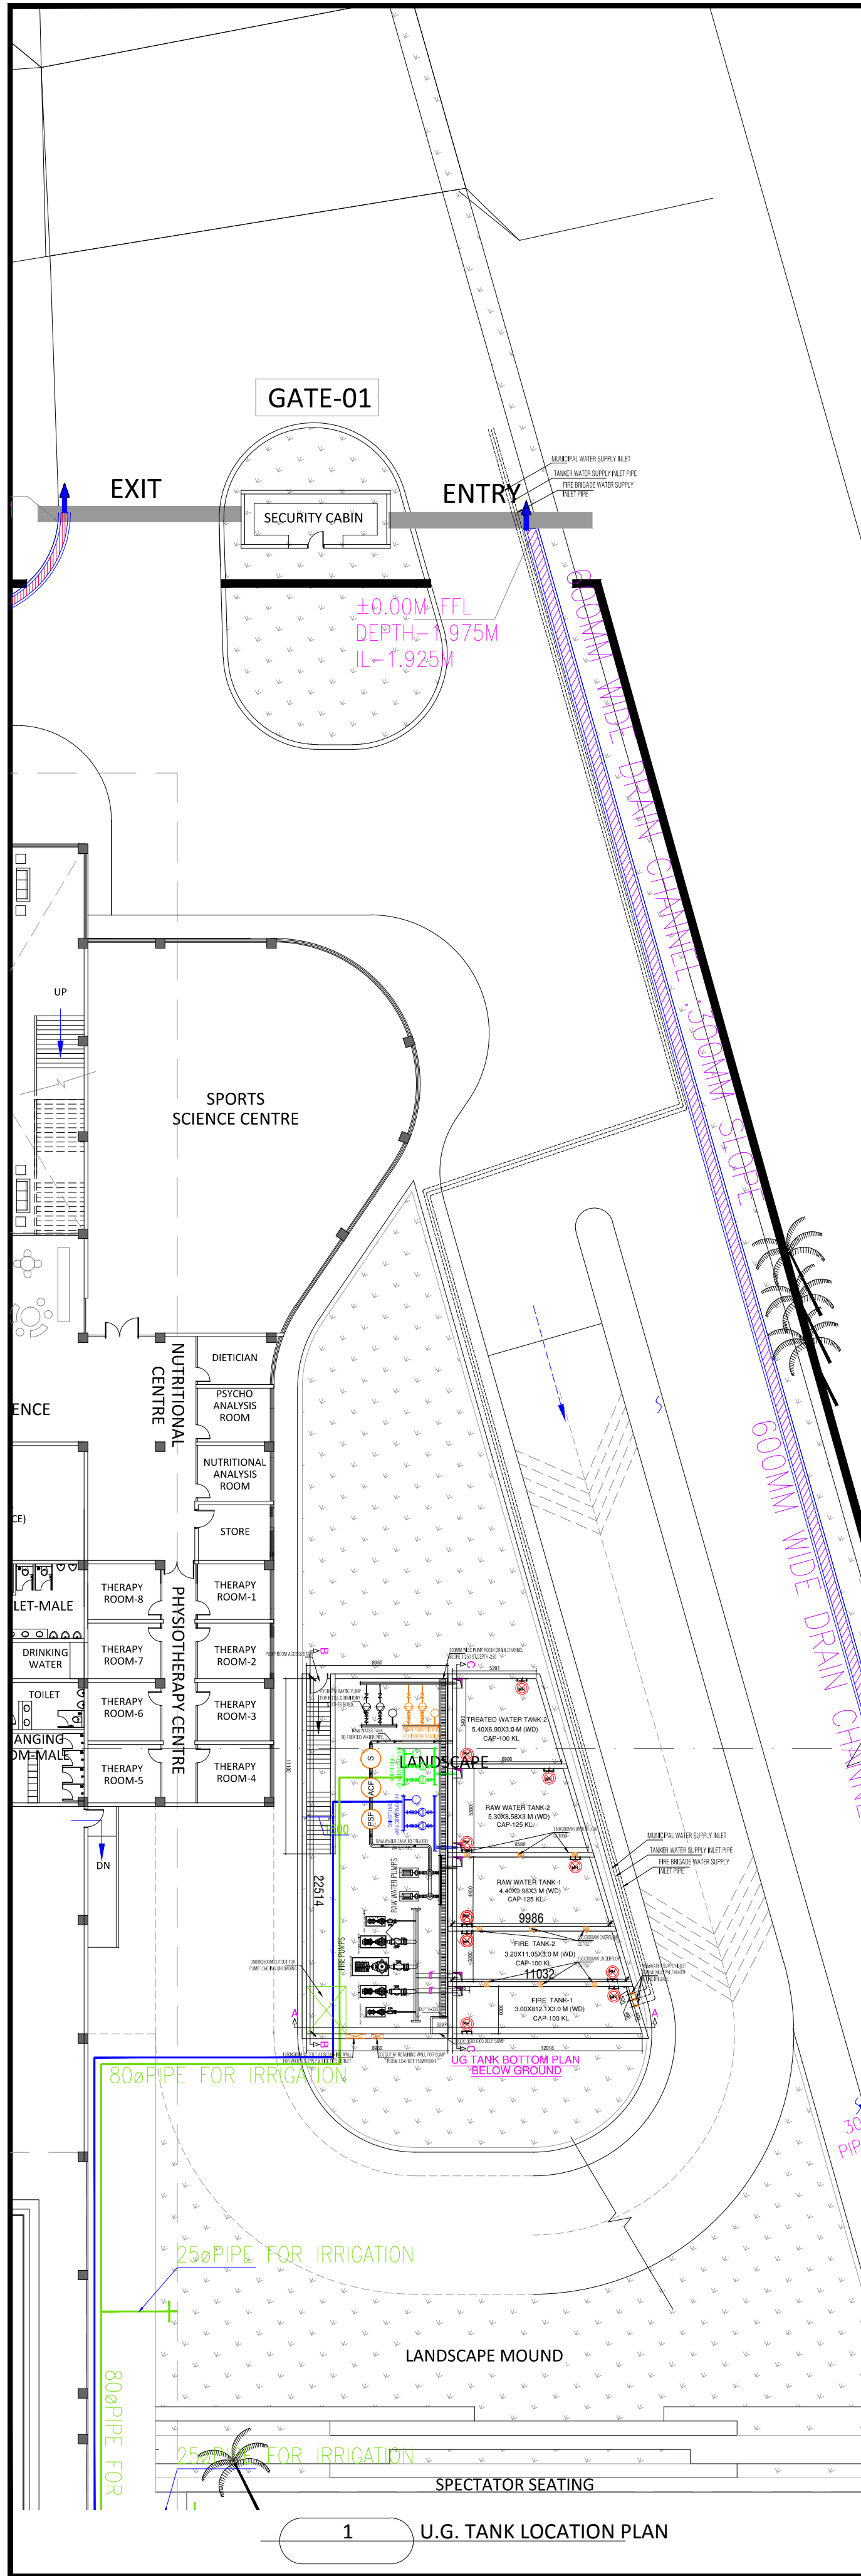

TENDER DRAWING

GENERAL NOTES

1. ALL DIMENSIONS ARE IN MILLIMETERS AND LEVELS ARE IN METER UNLESS OTHERWISE SPECIFIED.
2. ALL DIMENSIONS ARE TO BE CHECKED AND CO-RELATED WITH THE RELEVANT ARCHITECTURAL, STRUCTURAL AND SERVICES DRAWINGS AND ANY AMBIGUITY, DISCREPANCY OR OMISSION SHALL BE BROUGHT IN TO NOTICE OF ARCHITECT PRIOR TO COMMENCEMENT OF EXECUTION.
3. DO NOT SCALE THE DRAWING, WRITTEN DIMENSION TO BE FOLLOWED.
4. THIS DRAWING TO BE READ IN CONJUNCTION WITH THE RELEVANT SERVICES AND STRUCTURAL DRAWINGS.

REVISIONS

REV	DESCRIPTION	DATE

KEY PLAN

CLIENT



collage design ARCHITECTURE | INTERIORS | PMC
COLLAGE DESIGN PVT. LTD
300, Sai Sampanna, Station Rd
Vikhroli East, Mumbai 400 083
+91 22 2574 0842 / 43 / 44 / 45
www.collagedesign.net

STRUCTURAL CONSULTANT

SACPL Shanghi and Associates
Consultants Pvt.Ltd.
7th Floor, Padmavati Heights,
Shradhanand Road, Vile Parle (E),
Mumbai - 400057.
Tel - +91 22 2614 4832, Fax - +91
22 2617 1804

PROJECT

NATIONAL CENTRE OF EXCELLENCE
IN FOOTBALL @ RAJRAHAT, KOLKATA

DRAWING TITLE

U.G.TANK DETAILS

DWG. NO.	REV. NO.
TD.P.4.01	R0
PROJECT NO.	18-P245
SCALE	NORTH
1 st ISSUED ON	20-12-2018
APPROVED	
CHECKED BY	
DRAWN BY	

TENDER DRAWING

GENERAL NOTES

1. ALL DIMENSIONS ARE IN MILLIMETERS AND LEVELS ARE IN METER UNLESS OTHERWISE SPECIFIED.
2. ALL DIMENSIONS ARE TO BE CHECKED AND CO-RELATED WITH THE RELEVANT ARCHITECTURAL, STRUCTURAL AND SERVICES DRAWINGS AND ANY AMBIGUITY, DISCREPANCY OR OMISSION SHALL BE BROUGHT IN TO NOTICE OF ARCHITECT PRIOR TO COMMENCEMENT OF EXECUTION.
3. DO NOT SCALE THE DRAWING, WRITTEN DIMENSION TO BE FOLLOWED.
4. THIS DRAWING TO BE READ IN CONJUNCTION WITH THE RELEVANT SERVICES AND STRUCTURAL DRAWINGS.

REVISIONS

REV	DESCRIPTION	DATE

KEY PLAN

PILE SCHEDULE:-

DIA OF PILES	LEGEND	SAFE WORKING LOAD OF PILE	NOS. OF VERT. BARS	HELICALS	GRADE	DEPTH OF FIXITY	NO. OF PILES
750Ø		90 T	7-20T	8TØ150c/c (A) 8TØ200c/c (B)	M25	10.63 M.	21

FOOTING SCHEDULE

M-35	COL. SIZE	450x450		450x450
M-30	PILE CAP	1050x1050		1050x3300
M-15	P.C.C. 150 THK.	1350x1350		1350x3600
	D-d	800		800
BOTTOM REIN.	LONG BARS	L	REFER SCHEDULE	
	SHORT BARS	S		
GRADE	COLUMN NOS.	P1,P2,P3,P4,P6,P7,P9,P10, P12,P13,P14,P15,P16,P17,P18		
		P5,P8,P11		

PILE CAP REINF. DETAILS:-

TYPE	PILE NO. & DIA mm	D	BOTTOM BARS		TOP BARS		SHEAR LEGS
			LONG BARS	SHORT BARS	LONG BARS	SHORT BARS	
'1'	1-750Ø	800	20TØ150c/c	20TØ150c/c	10TØ200c/c	10TØ200c/c	-----
'2'	2-750Ø	800	20TØ175c/c	20TØ175c/c	10TØ200c/c	10TØ200c/c	-----

TANK BOTTOM SLAB SCHEDULE :-


SLAB NO.	SLAB THK.	BOTTOM REINF.		TOP REINF.		REMARKS
		MAIN BARS (SHORT SPAN)	DIST. BARS (LONG SPAN)	MAIN BARS (SHORT SPAN)	DIST. BARS (LONG SPAN)	
BS1	450	16TØ150c/c	16TØ150c/c	12TØ100c/c	12TØ100c/c	TWO WAY

TANK TOP SLAB SCHEDULE :-

SLAB NO.	SLAB THK.	MAIN BARS (SHORT SPAN)	DIST. BARS (LONG SPAN)	REMARKS
TS1	200	8TØ125c/c	8TØ150c/c	TWO WAY

COLUMN SCHEDULE

M35	GROUND FLOOR LEVEL	450x450	450x450
	BELOW GROUND LEVEL	450x450	450x450
GRADE	COLUMN NOS.	P1 TO P4, P6,P7,P9 P10,P12, P13 TO P18	P5,P8,P11

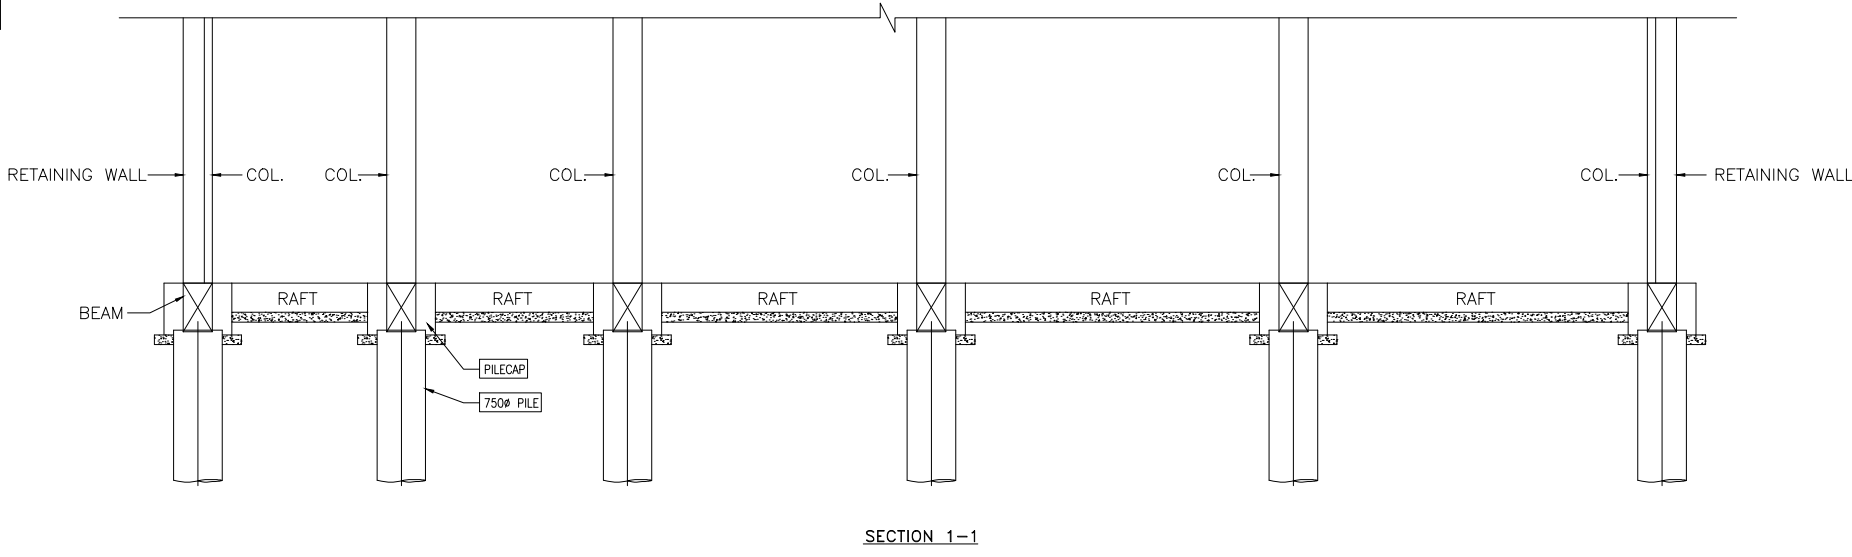


LEGEND


	COLUMN/R.C.C. WALL CONTINUOUS
	COLUMN/R.C.C. WALL STOPS
	PILE CAP
	TANK WALL
	750Ø PILE
	TRENCH

GRADE OF CONCRETE

DESCRIPTION	GRADE
PILE	M-25
PILE CAP	M-25
P. C. C.	M-15



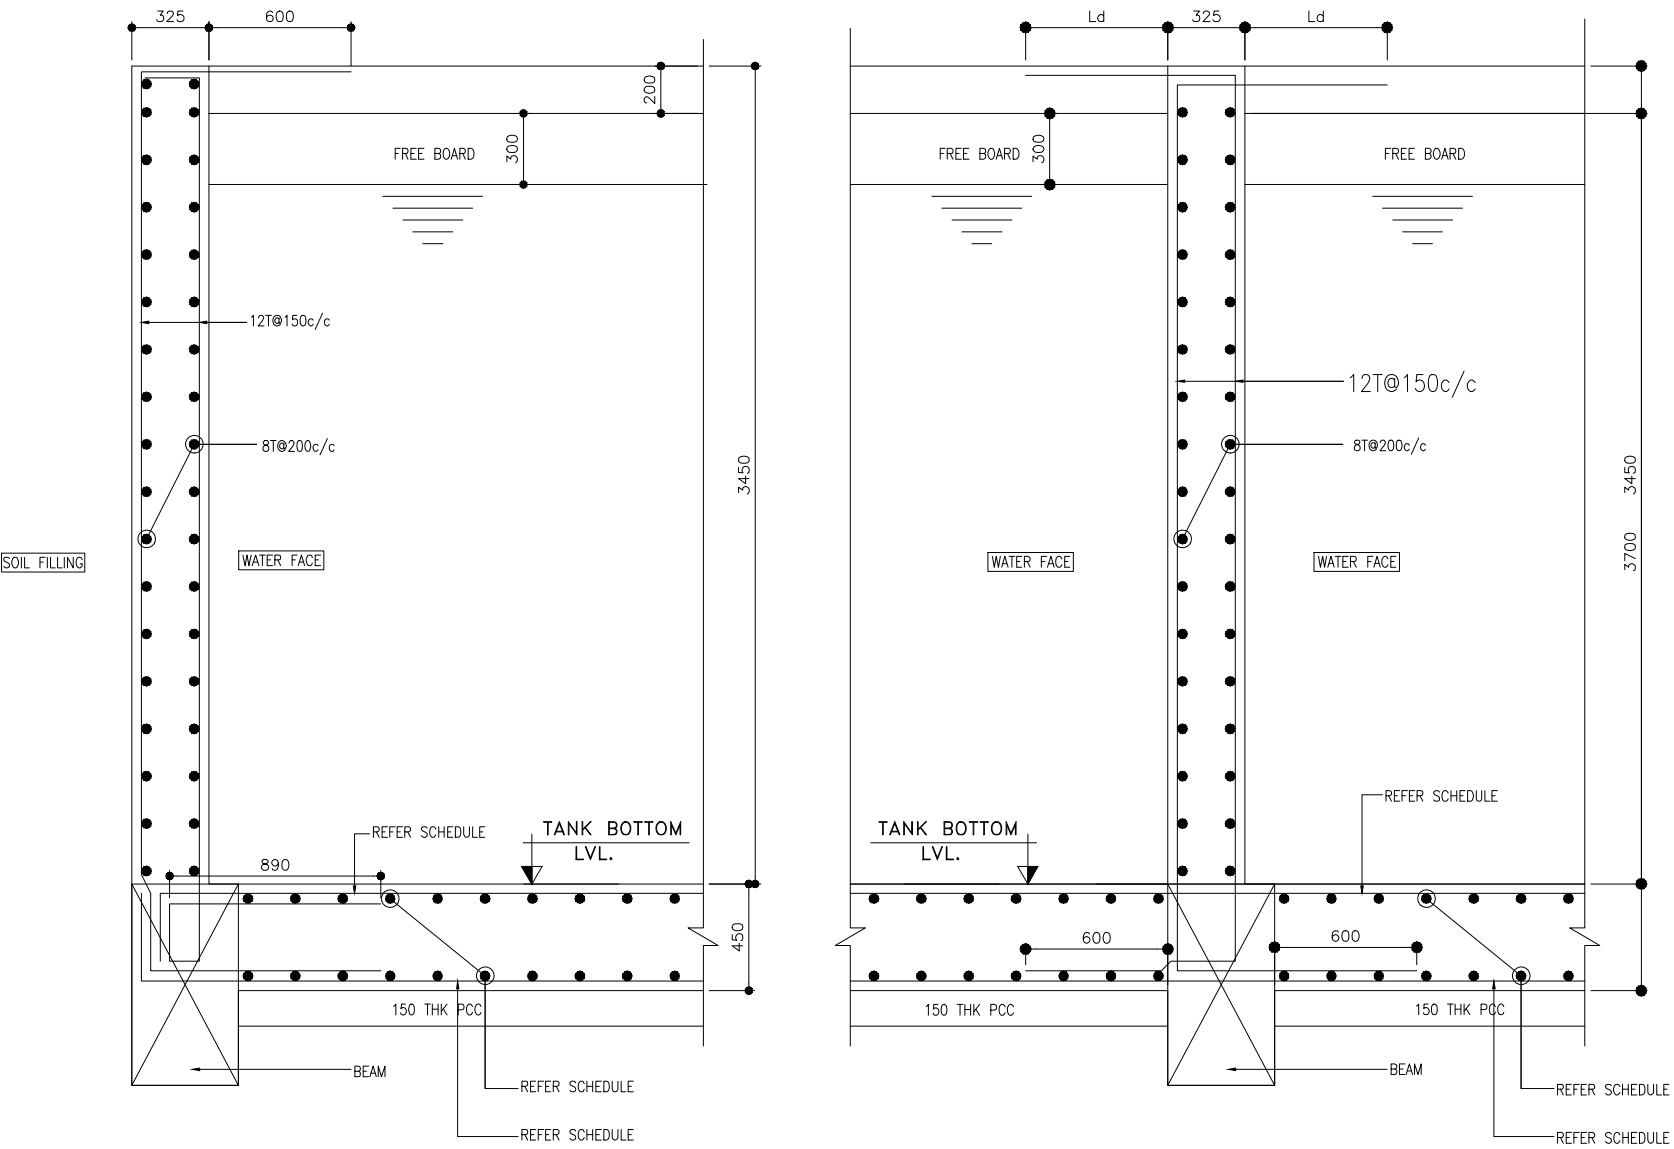


SECTION: 2-2

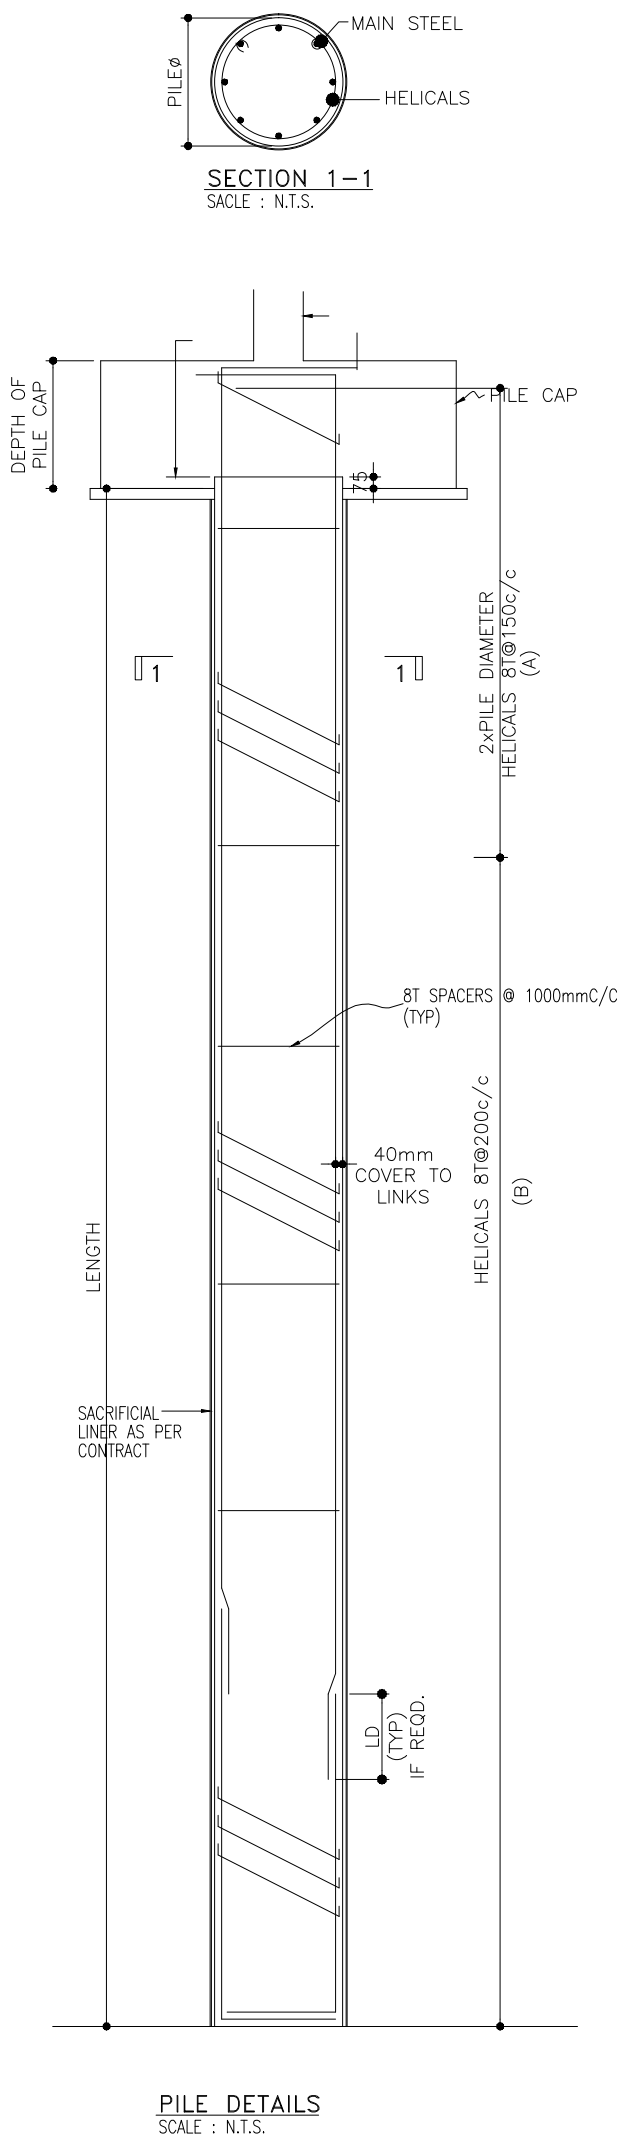

PILE DETAILS

SCALE : N.T.S.

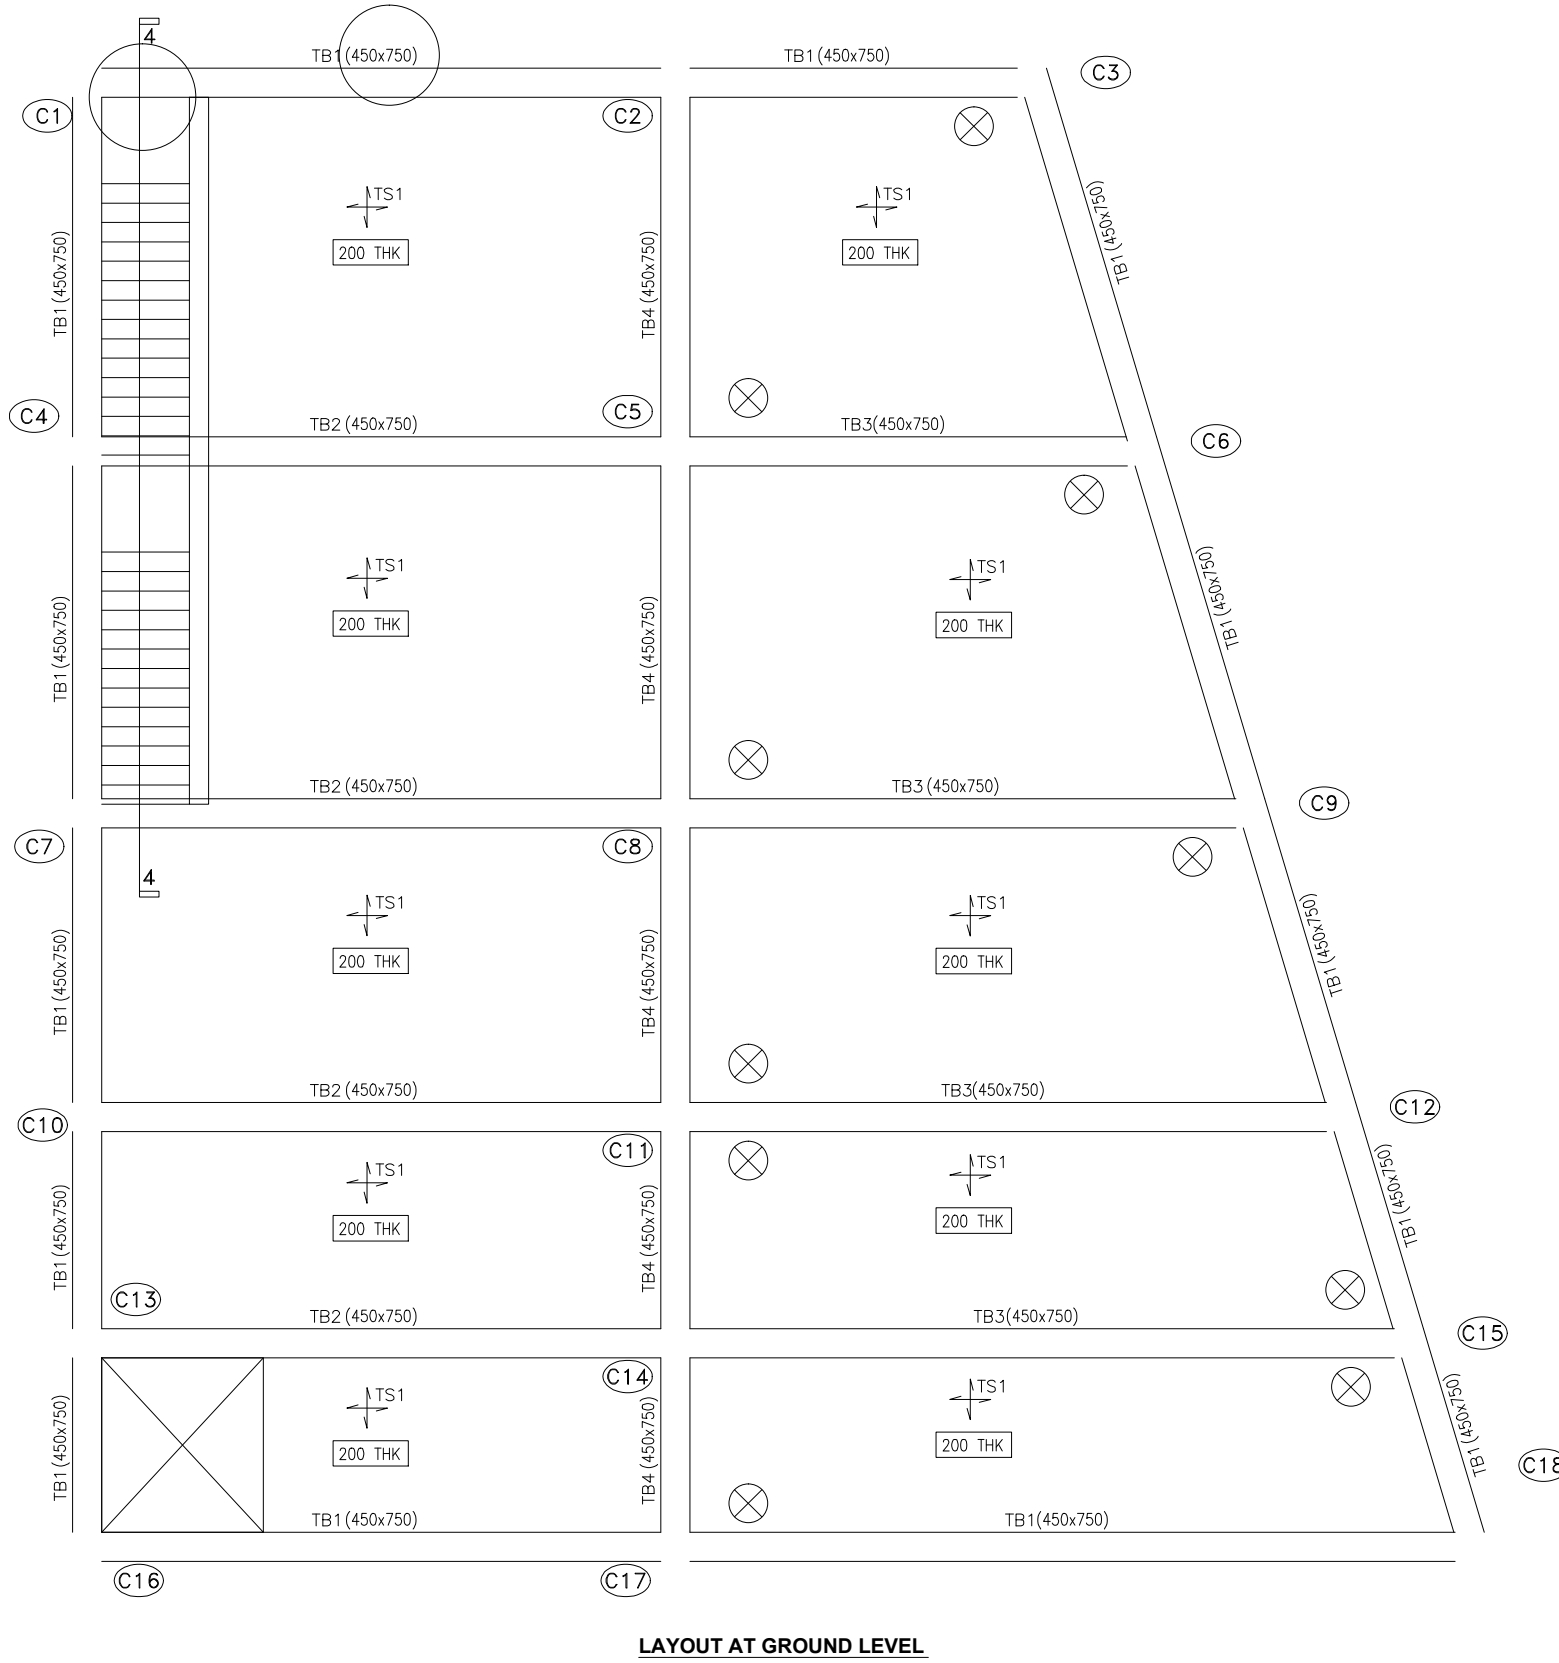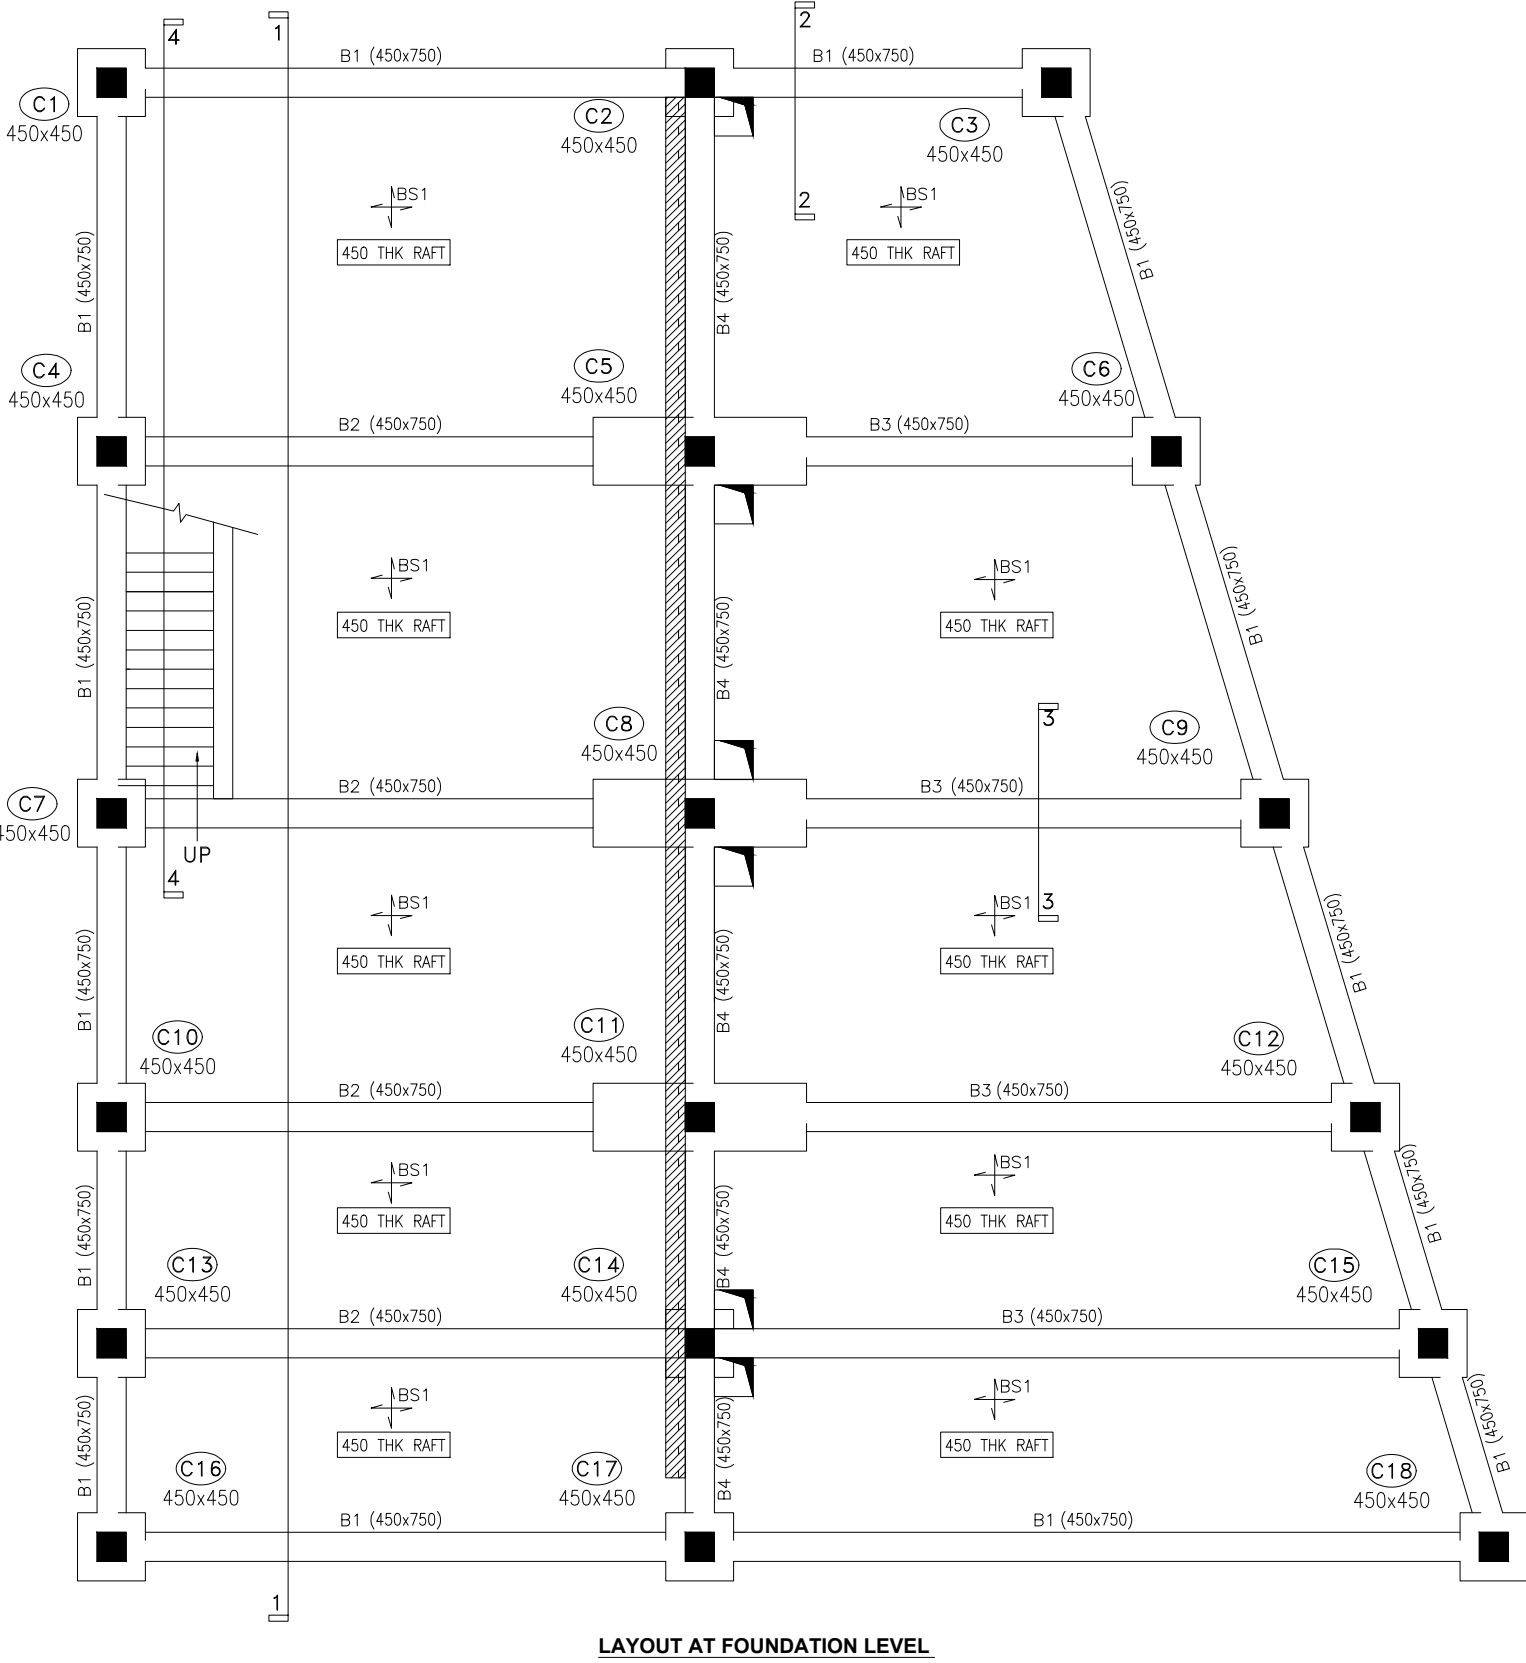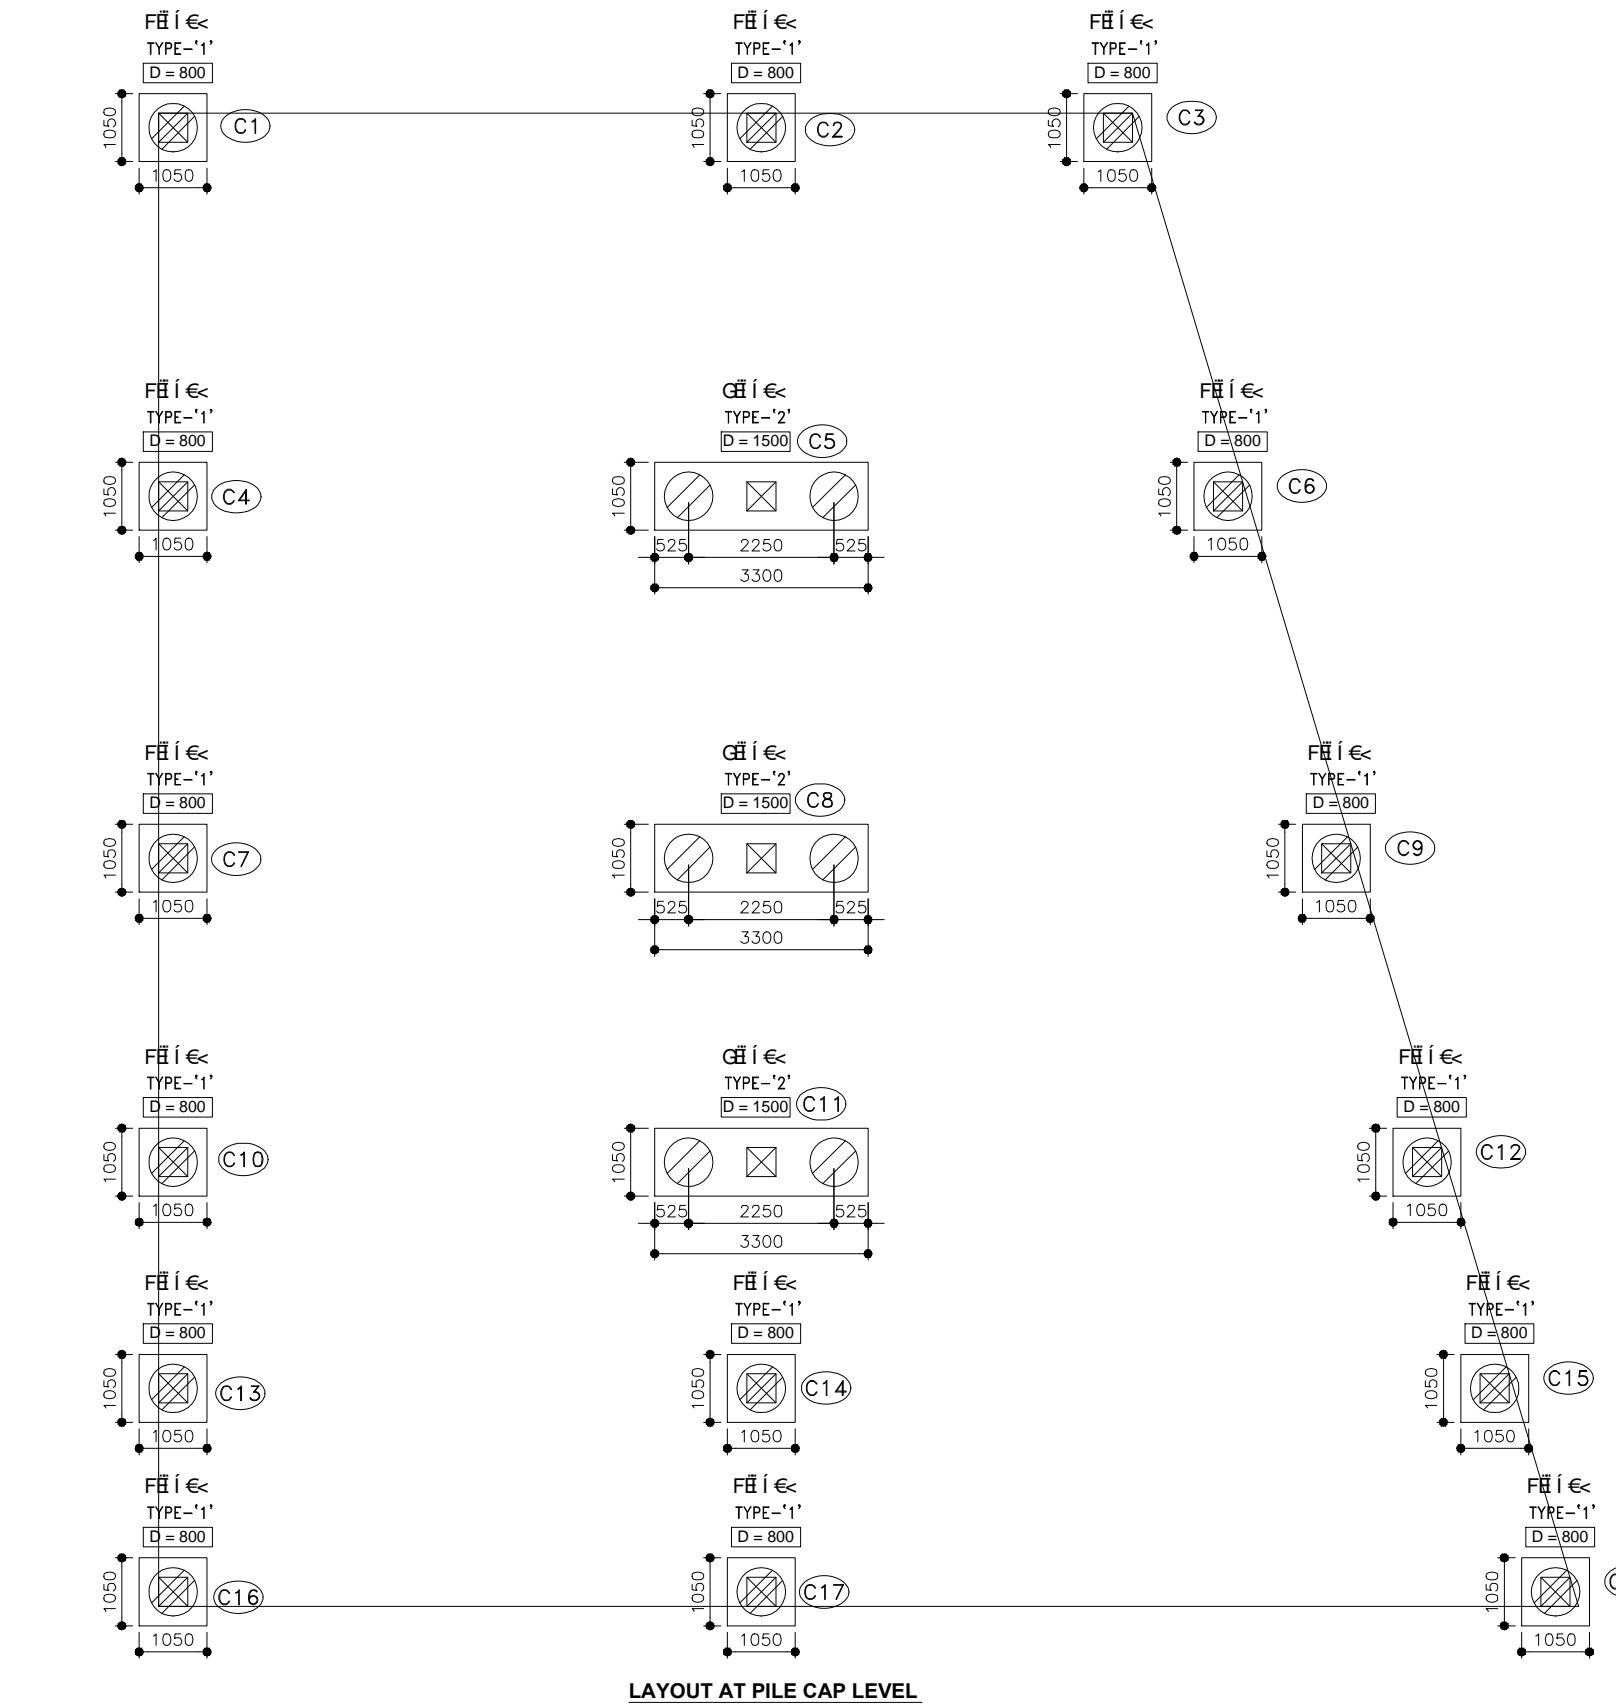

CLIENT



ALL INDIA FOOTBALL FEDERATION
 Football House, Sector 19, Phase 1,
 Dwarka, New Delhi: 110075
 Tel- 91-11-25308200/ 201
 Fax- 91-11-25308234/ 25308236
 Email- aiff@the-aiff.com

ARCHITECT



COLLAGE DESIGN PVT. LTD
 300, Sai Sampanna, Station Rd
 Vikhroli East, Mumbai 400 083
 +91 22 2574 0842 / 43 / 44 / 45
 www.collagedesign.net

STRUCTURAL CONSULTANT



Shanghvi and Associates Consultants Pvt.Ltd.
 7th Floor, Padmavati Heights,
 Shradhdhanand Road,Vile Parle (E),
 Mumbai - 400057.
 Tel - +91 22 2614 4832, Fax - +91 22 2617 1804

PROJECT

NATIONAL CENTRE OF EXCELLENCE
IN FOOTBALL @ RAJRAHAT, KOLKATA

DRAWING TITLE

U.G.TANK -
STRUCTURAL DETAILS

DWG. NO.	REV. NO.
TD.S.4.02	R0
PROJECT NO.	18-P245
SCALE	NORTH
1 st ISSUED ON	20-12-2018
APPROVED	
CHECKED BY	
DRAWN BY	

TENDER DRAWING

GENERAL NOTES

1. ALL DIMENSIONS ARE IN MILLIMETERS AND LEVELS ARE IN METER UNLESS OTHERWISE SPECIFIED.
2. ALL DIMENSIONS ARE TO BE CHECKED AND CO-RELATED WITH THE RELEVANT ARCHITECTURAL, STRUCTURAL AND SERVICES DRAWINGS AND ANY AMBIGUITY, DISCREPANCY OR OMISSION SHALL BE BROUGHT IN TO NOTICE OF ARCHITECT PRIOR TO COMMENCEMENT OF EXECUTION.
3. DO NOT SCALE THE DRAWING, WRITTEN DIMENSION TO BE FOLLOWED.
4. THIS DRAWING TO BE READ IN CONJUNCTION WITH THE RELEVANT SERVICES AND STRUCTURAL DRAWINGS.

REVISIONS

REV	DESCRIPTION	DATE

KEY PLAN

CLIENT



INDIA
FOOTBALL FEDERATION

ALL INDIA FOOTBALL FEDERATION
Football House, Sector 19, Phase 1,
Dwarka, New Delhi: 110075
Tel- 91-11-25308200/ 201
Fax- 91-11-25308234/ 25308236
Email- aiff@the-aiff.com

ARCHITECT



collage design

COLLAGE DESIGN PVT. LTD
300, Sai Sampanna, Station Rd
Vikhroli East, Mumbai 400 083
+91 22 2574 0842 / 43 / 44 / 45
www.collagedesign.net

STRUCTURAL CONSULTANT



SACPL

**Shanghvi and Associates
Consultants Pvt.Ltd.**
7th Floor, Padmavati Heights,
Shradhdhanand Road, Vile Parle (E),
Mumbai - 400057.
Tel - +91 22 2614 4832, Fax - +91
22 2617 1804


PROJECT

NATIONAL CENTRE OF EXCELLENCE
IN FOOTBALL @ RAJRAHAT, KOLKATA


DRAWING TITLE

U.G.TANK -
STRUCTURAL DETAILS

DWG. NO.	REV. NO.
TD.S.4.02-A	R0
PROJECT NO. 18-P245	
SCALE	NORTH
1 st ISSUED ON	20-12-2018
APPROVED	
CHECKED BY	
DRAWN BY	

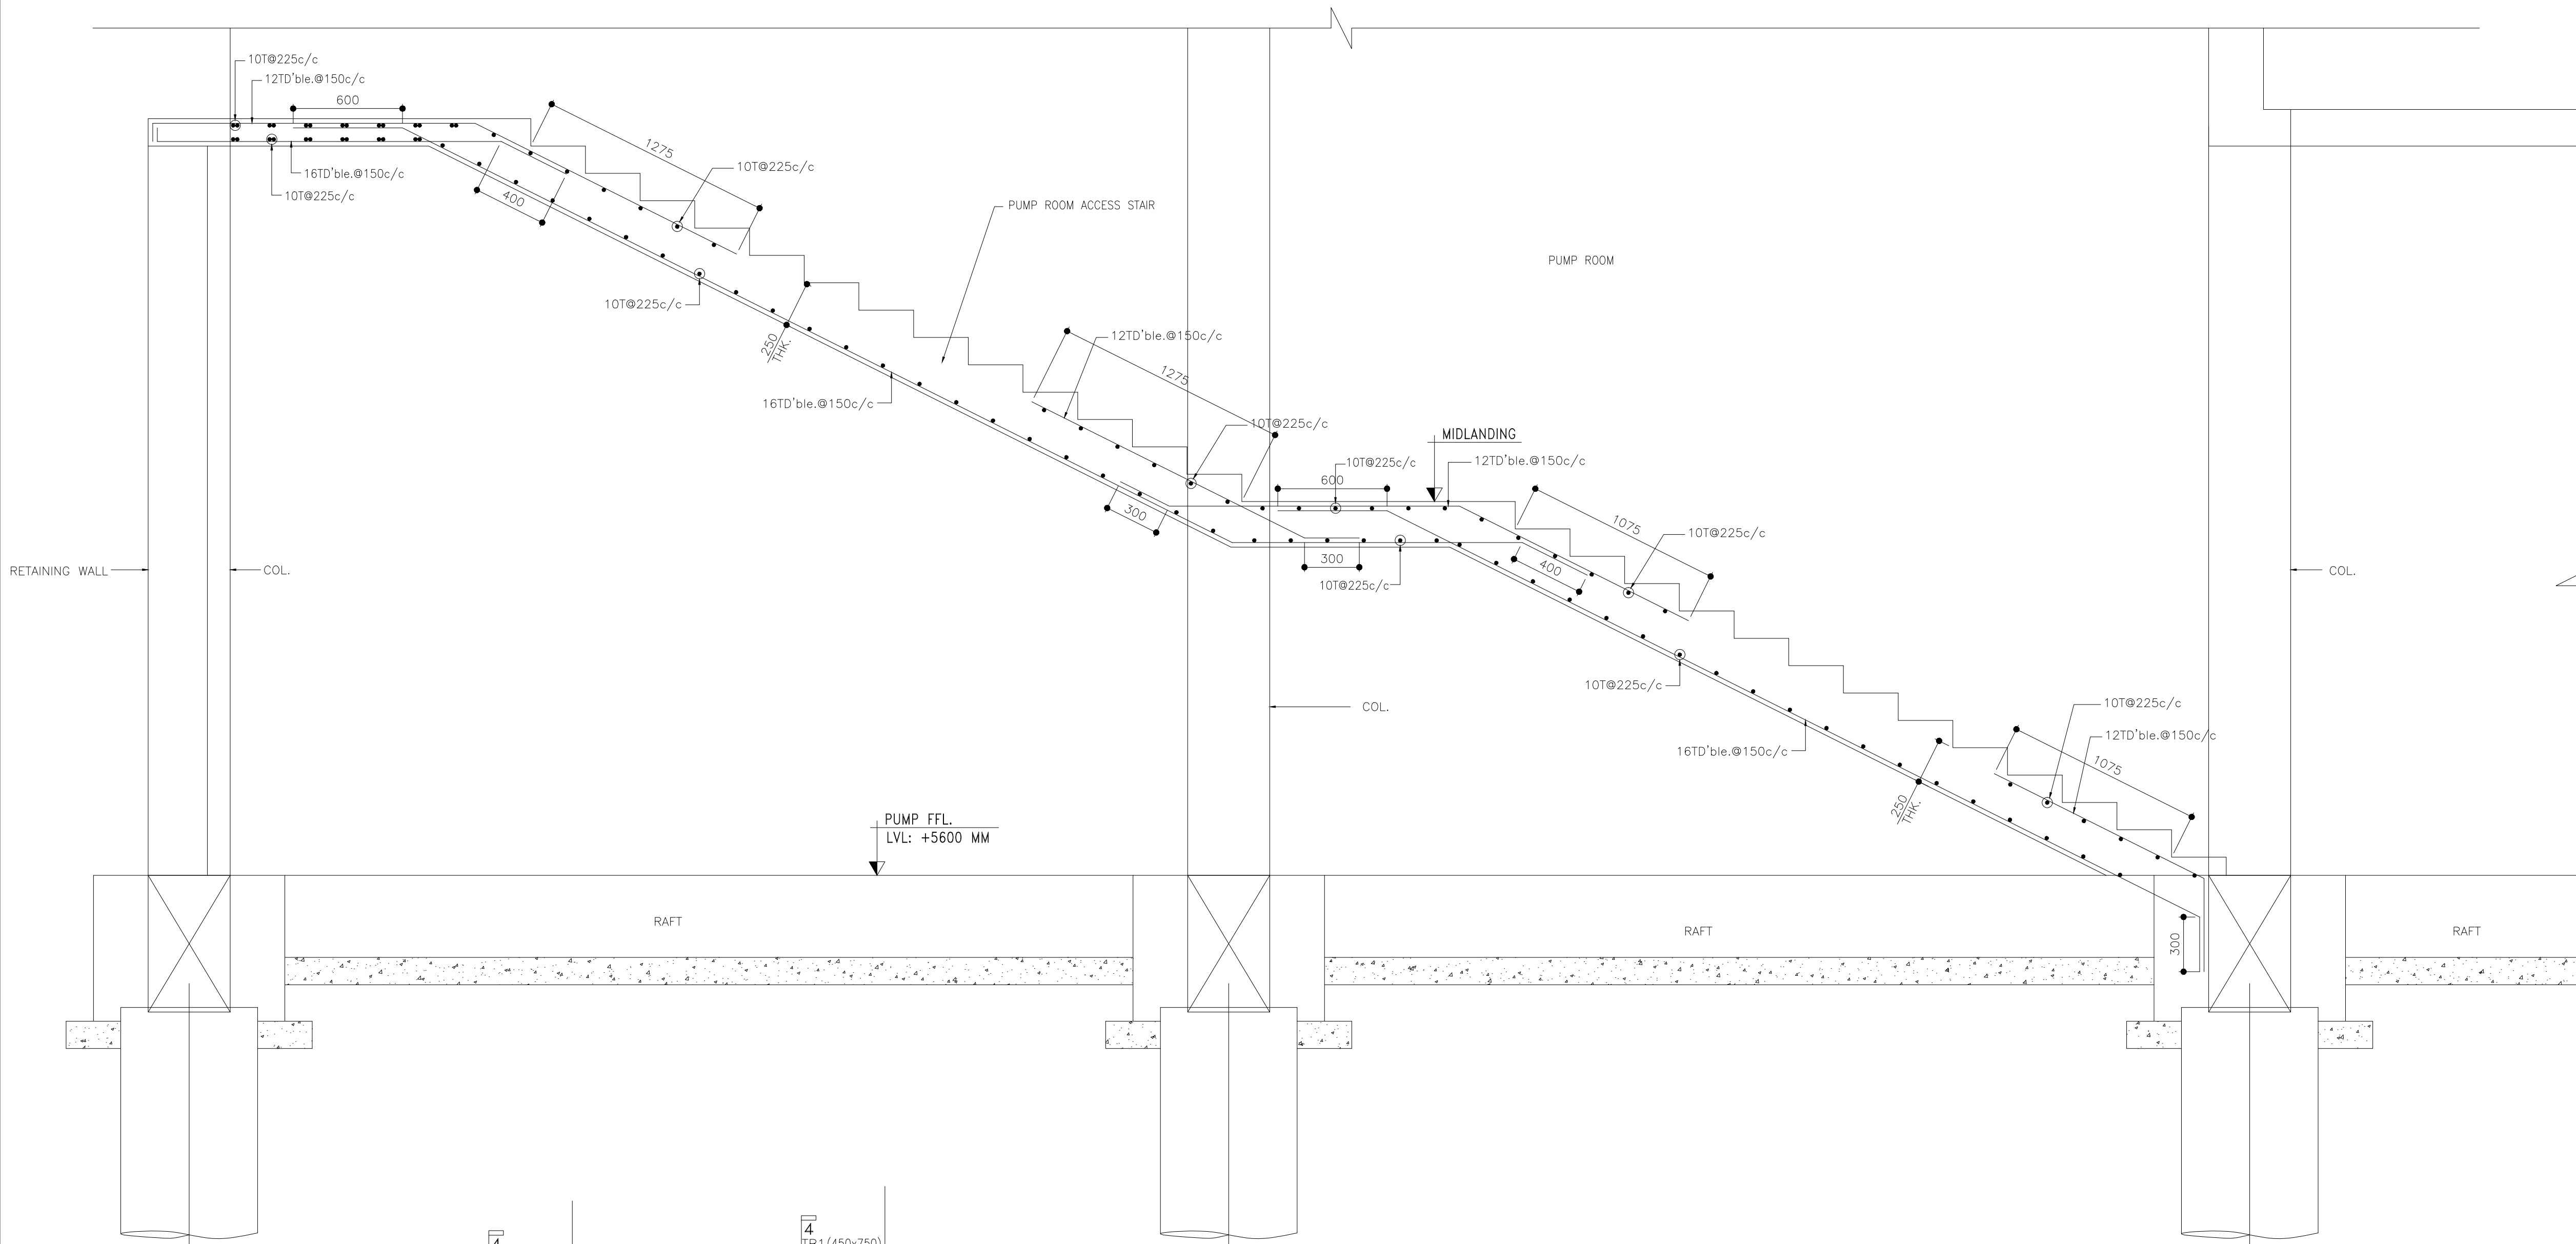

SECTION 4-4

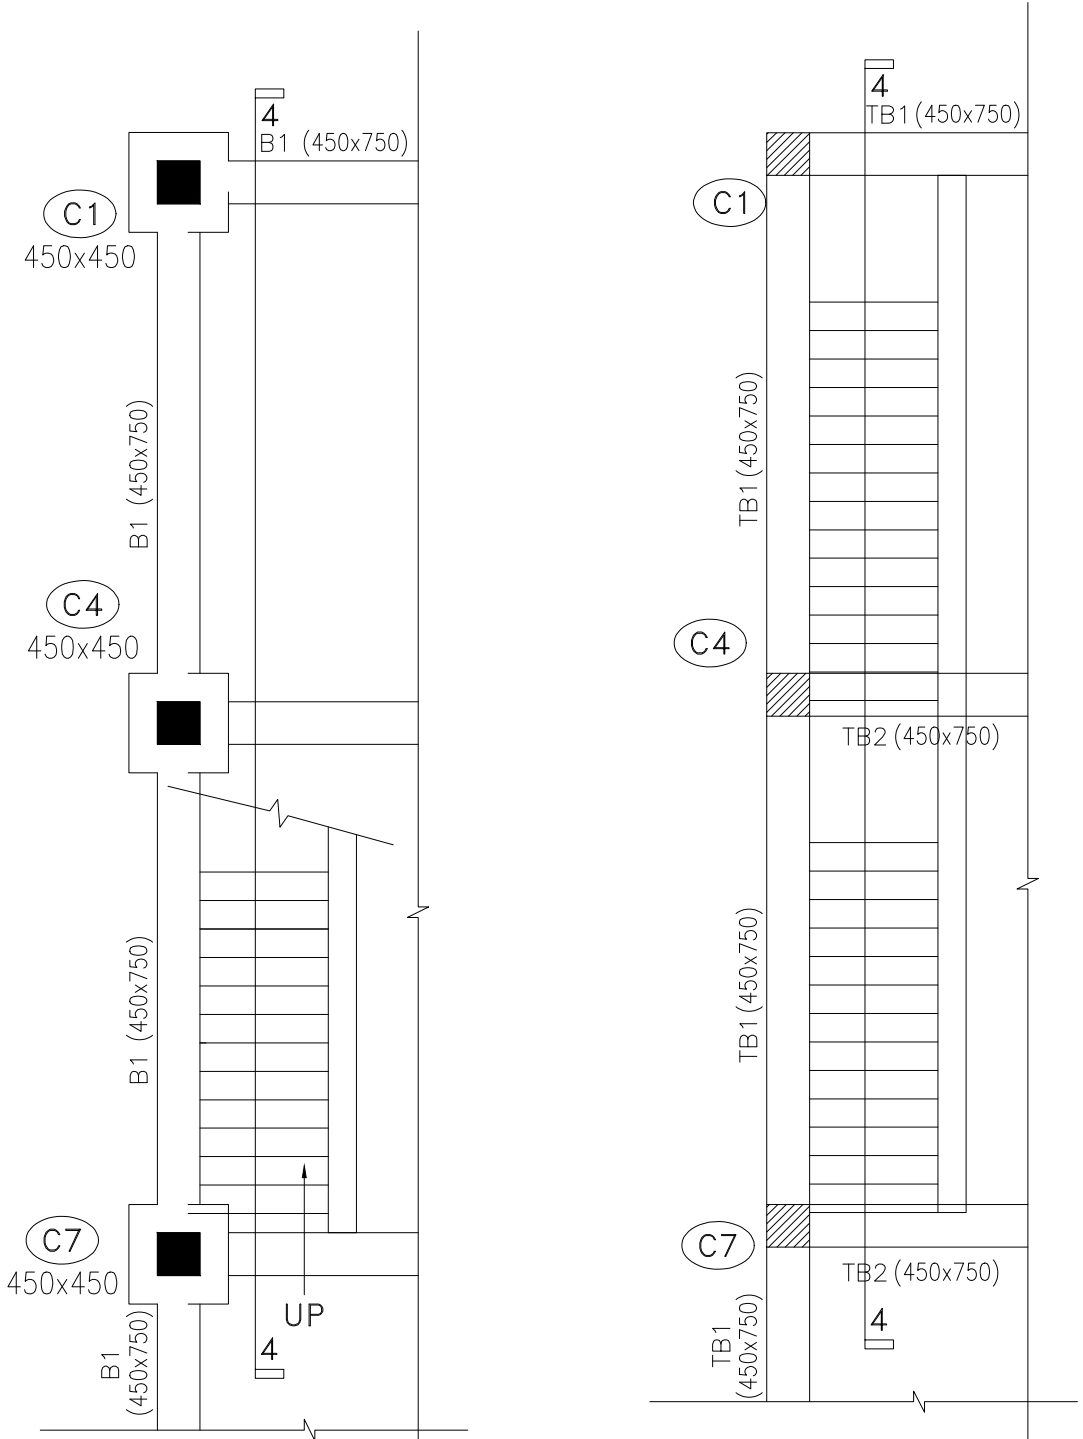

PUMP ROOM BOTTOM PLAN

PUMP ROOM TOP PLAN