



NATIONAL CENTRE OF EXCELLENCE IN FOOTBALL @ RAJRAHAT, KOLKATA


- ARCHITECTURAL DRAWINGS

TENDER PACKAGE-3
ARTIFICIAL TURF

20th DECEMBER, 2019

SR. NO.	DRAWINGS	DRAWING NO.
ARCHITECTURAL PACKAGE		
1	SITE PLAN-SURVEY	TD-A.0.01
2	TRAINING FIELD -1- ARTIFICIAL TURF	TD-A.0.03.B

CLIENT :	ARCHITECT :
	

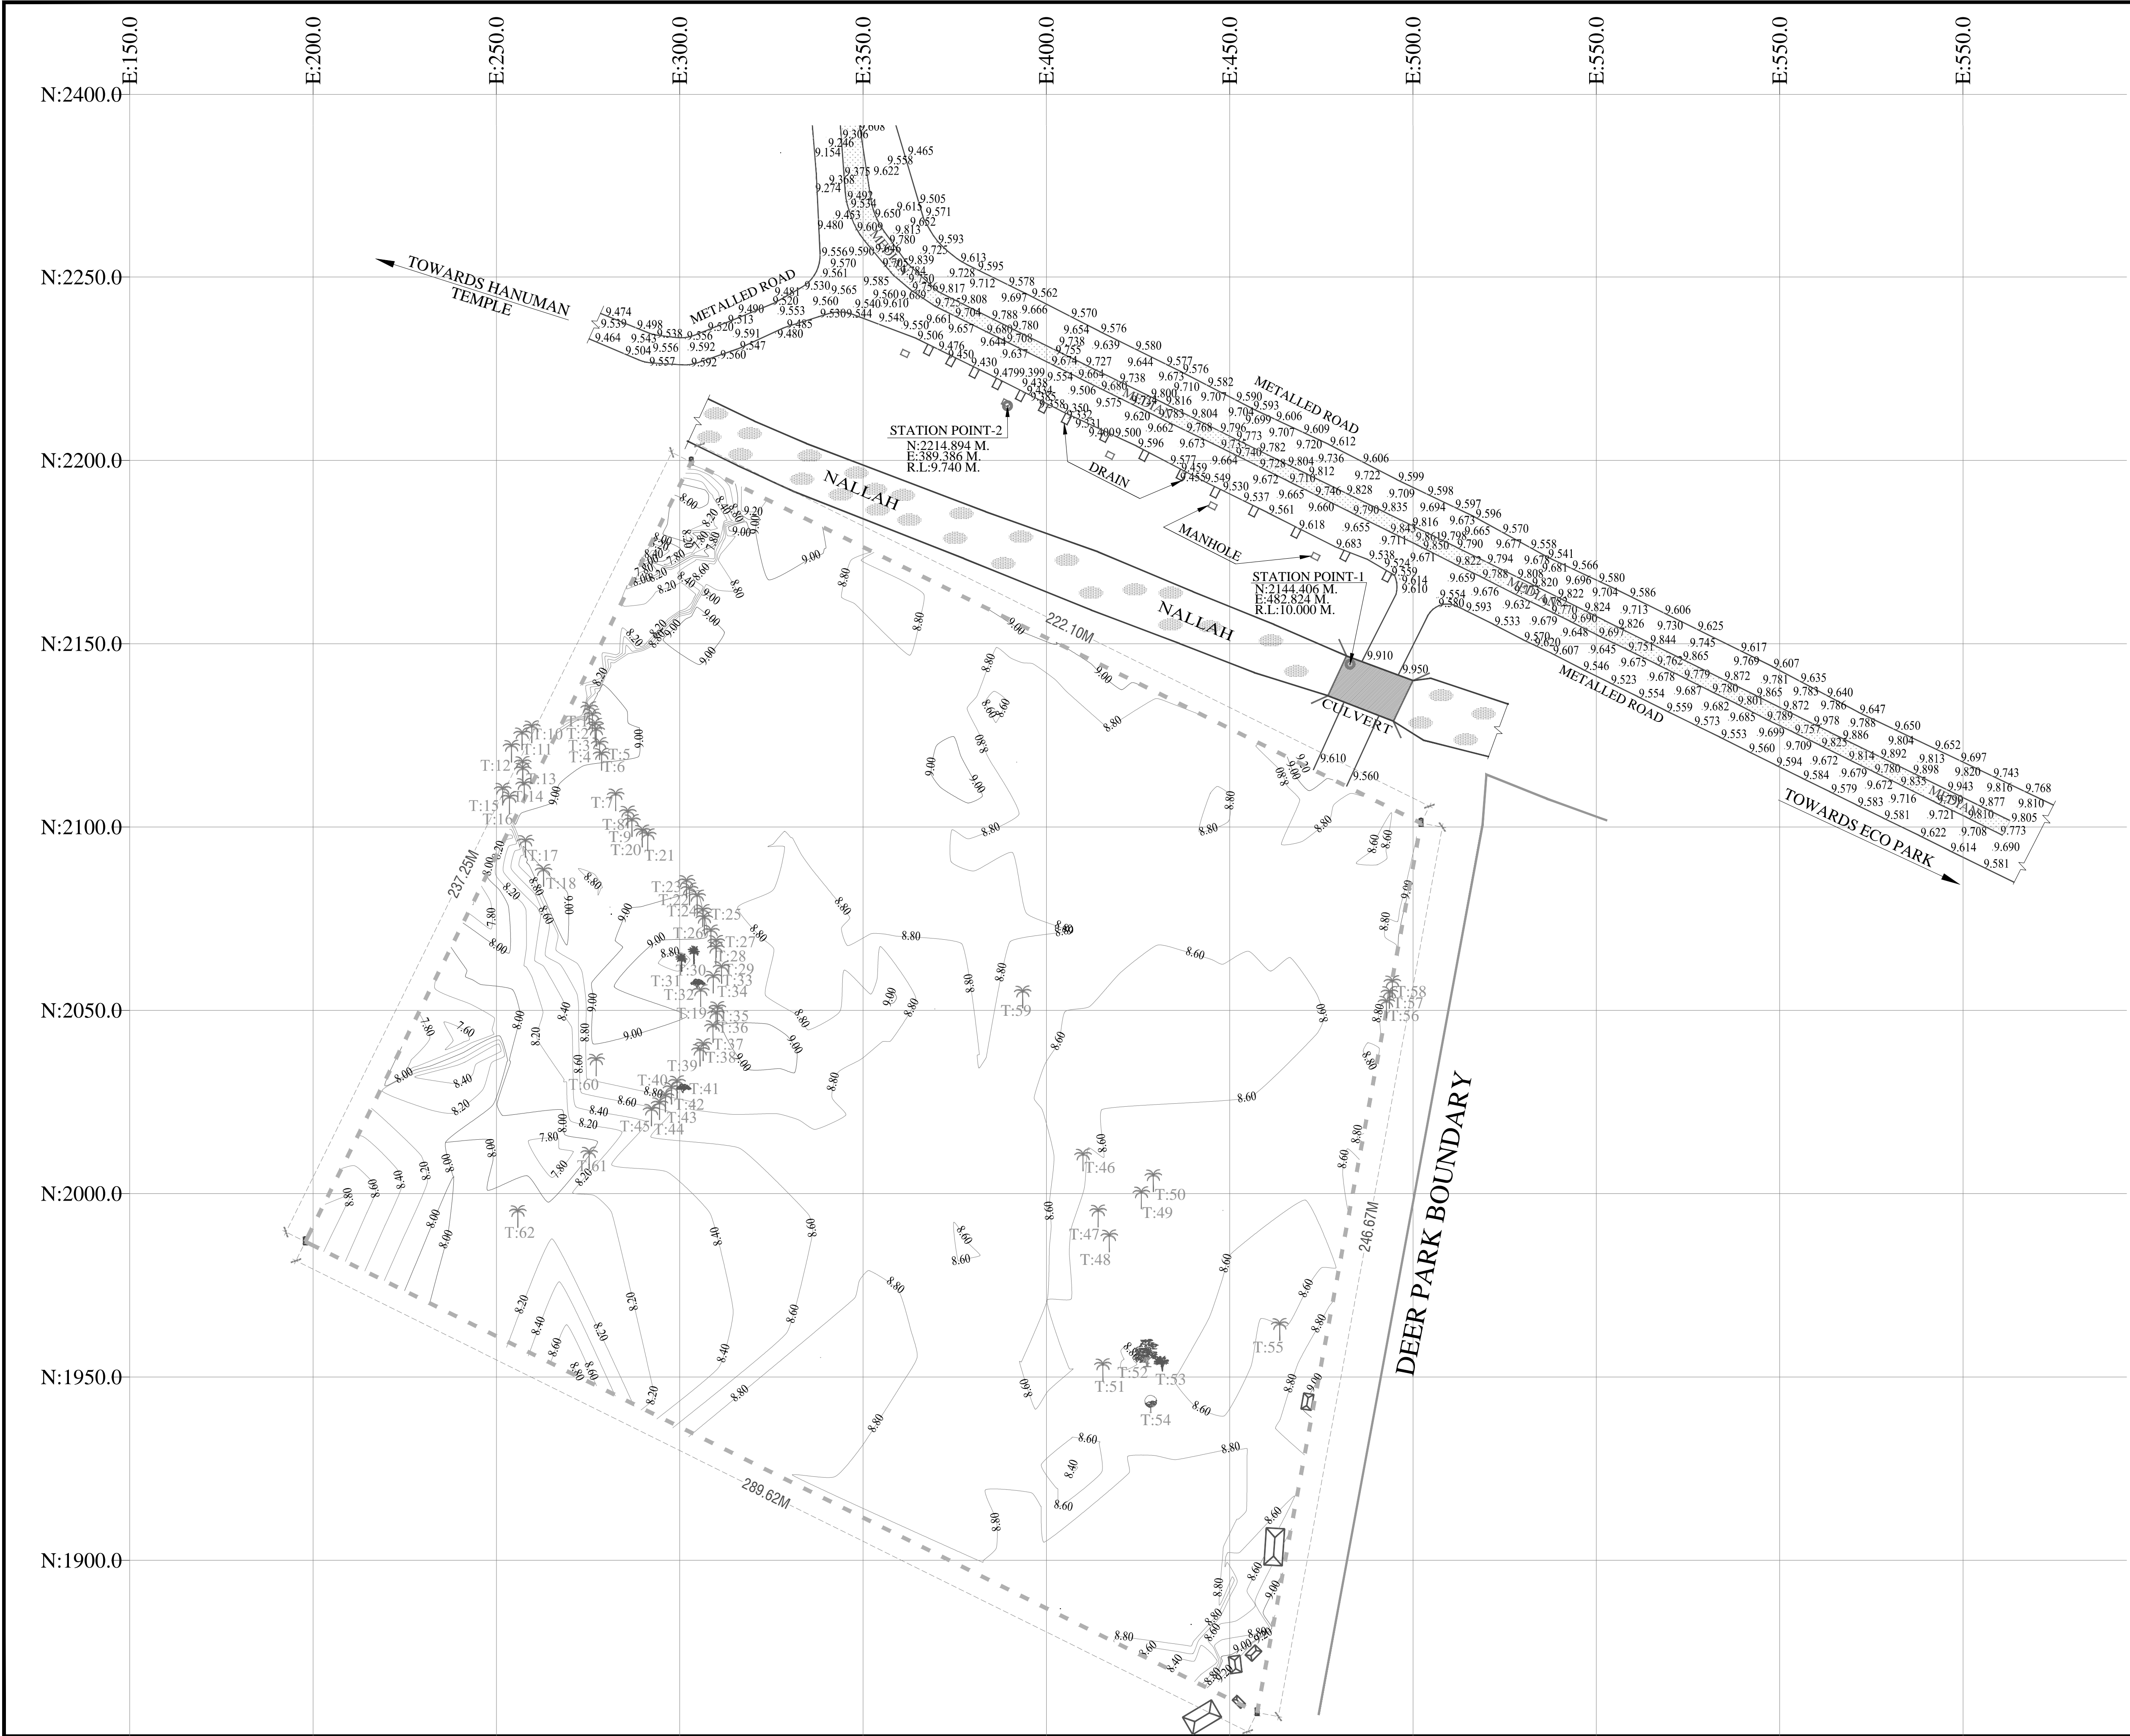

TENDER DRAWING

GENERAL NOTES

1. ALL DIMENSIONS IN MILLIMETERS AND LEVELS ARE IN METER UNLESS OTHERWISE SPECIFIED.
2. ALL DIMENSIONS ARE TO BE CHECKED AND CO-RELATED WITH THE RELEVANT ARCHITECTURAL, STRUCTURAL AND SERVICES DRAWINGS AND ANY AMBIGUITY, DISCREPANCY OR OMISSION SHALL BE BROUGHT IN TO NOTICE OF ARCHITECT PRIOR TO COMMENCEMENT OF EXECUTION.
3. DO NOT SCALE THE DRAWING, WRITTEN DIMENSION TO BE FOLLOWED.
4. THIS DRAWING TO BE READ IN CONJUNCTION WITH THE RELEVANT SERVICES AND STRUCTURAL DRAWINGS.

REVISIONS

REV	DESCRIPTION	DATE

KEY PLAN

CLIENT

ALL INDIA FOOTBALL FEDERATION

ARCHITECT

Architecture | Interiors | PMC | EPC
COLLAGE DESIGN PVT. LTD.
300 Sai Sampada, Station Rd
Vikhroli East, Mumbai - 400 083
T +91 22 2574 0844 / 45 F +91 22 2574 0846
E info@collagedesign.net
collagedesign.net

STRUCTURAL CONSULTANT

Shanghvi and Associates
Consultants Pvt. Ltd.
7th Floor, Patravali Heights,
Shradhdham Road, Vile Parle (E),
Mumbai - 400057.
Tel : +91 22 2514 4832, Fax : +91
22 2817 1804

MEP CONSULTANT

MEPCON DESIGN STUDIO

PROJECT


NATIONAL CENTRE OF EXCELLENCE
IN FOOTBALL @ RAJRAHAT, KOLKATA

DRAWING TITLE

SURVEY PLAN

DWG. NO.	REV. NO.
TD.A.0.01	R0
PROJECT NO.	
SCALE	
1"=ISSUED ON	
APPROVED	
CHECKED BY	
DRAWN BY	

THIS DRAWING IS A PROPERTY OF COLLAGE DESIGN PVT. LTD. AND IS NOT TO BE REPRODUCED OR USED FOR ANY OTHER PURPOSE THAN FOR WHICH IT HAS BEEN LOANED.

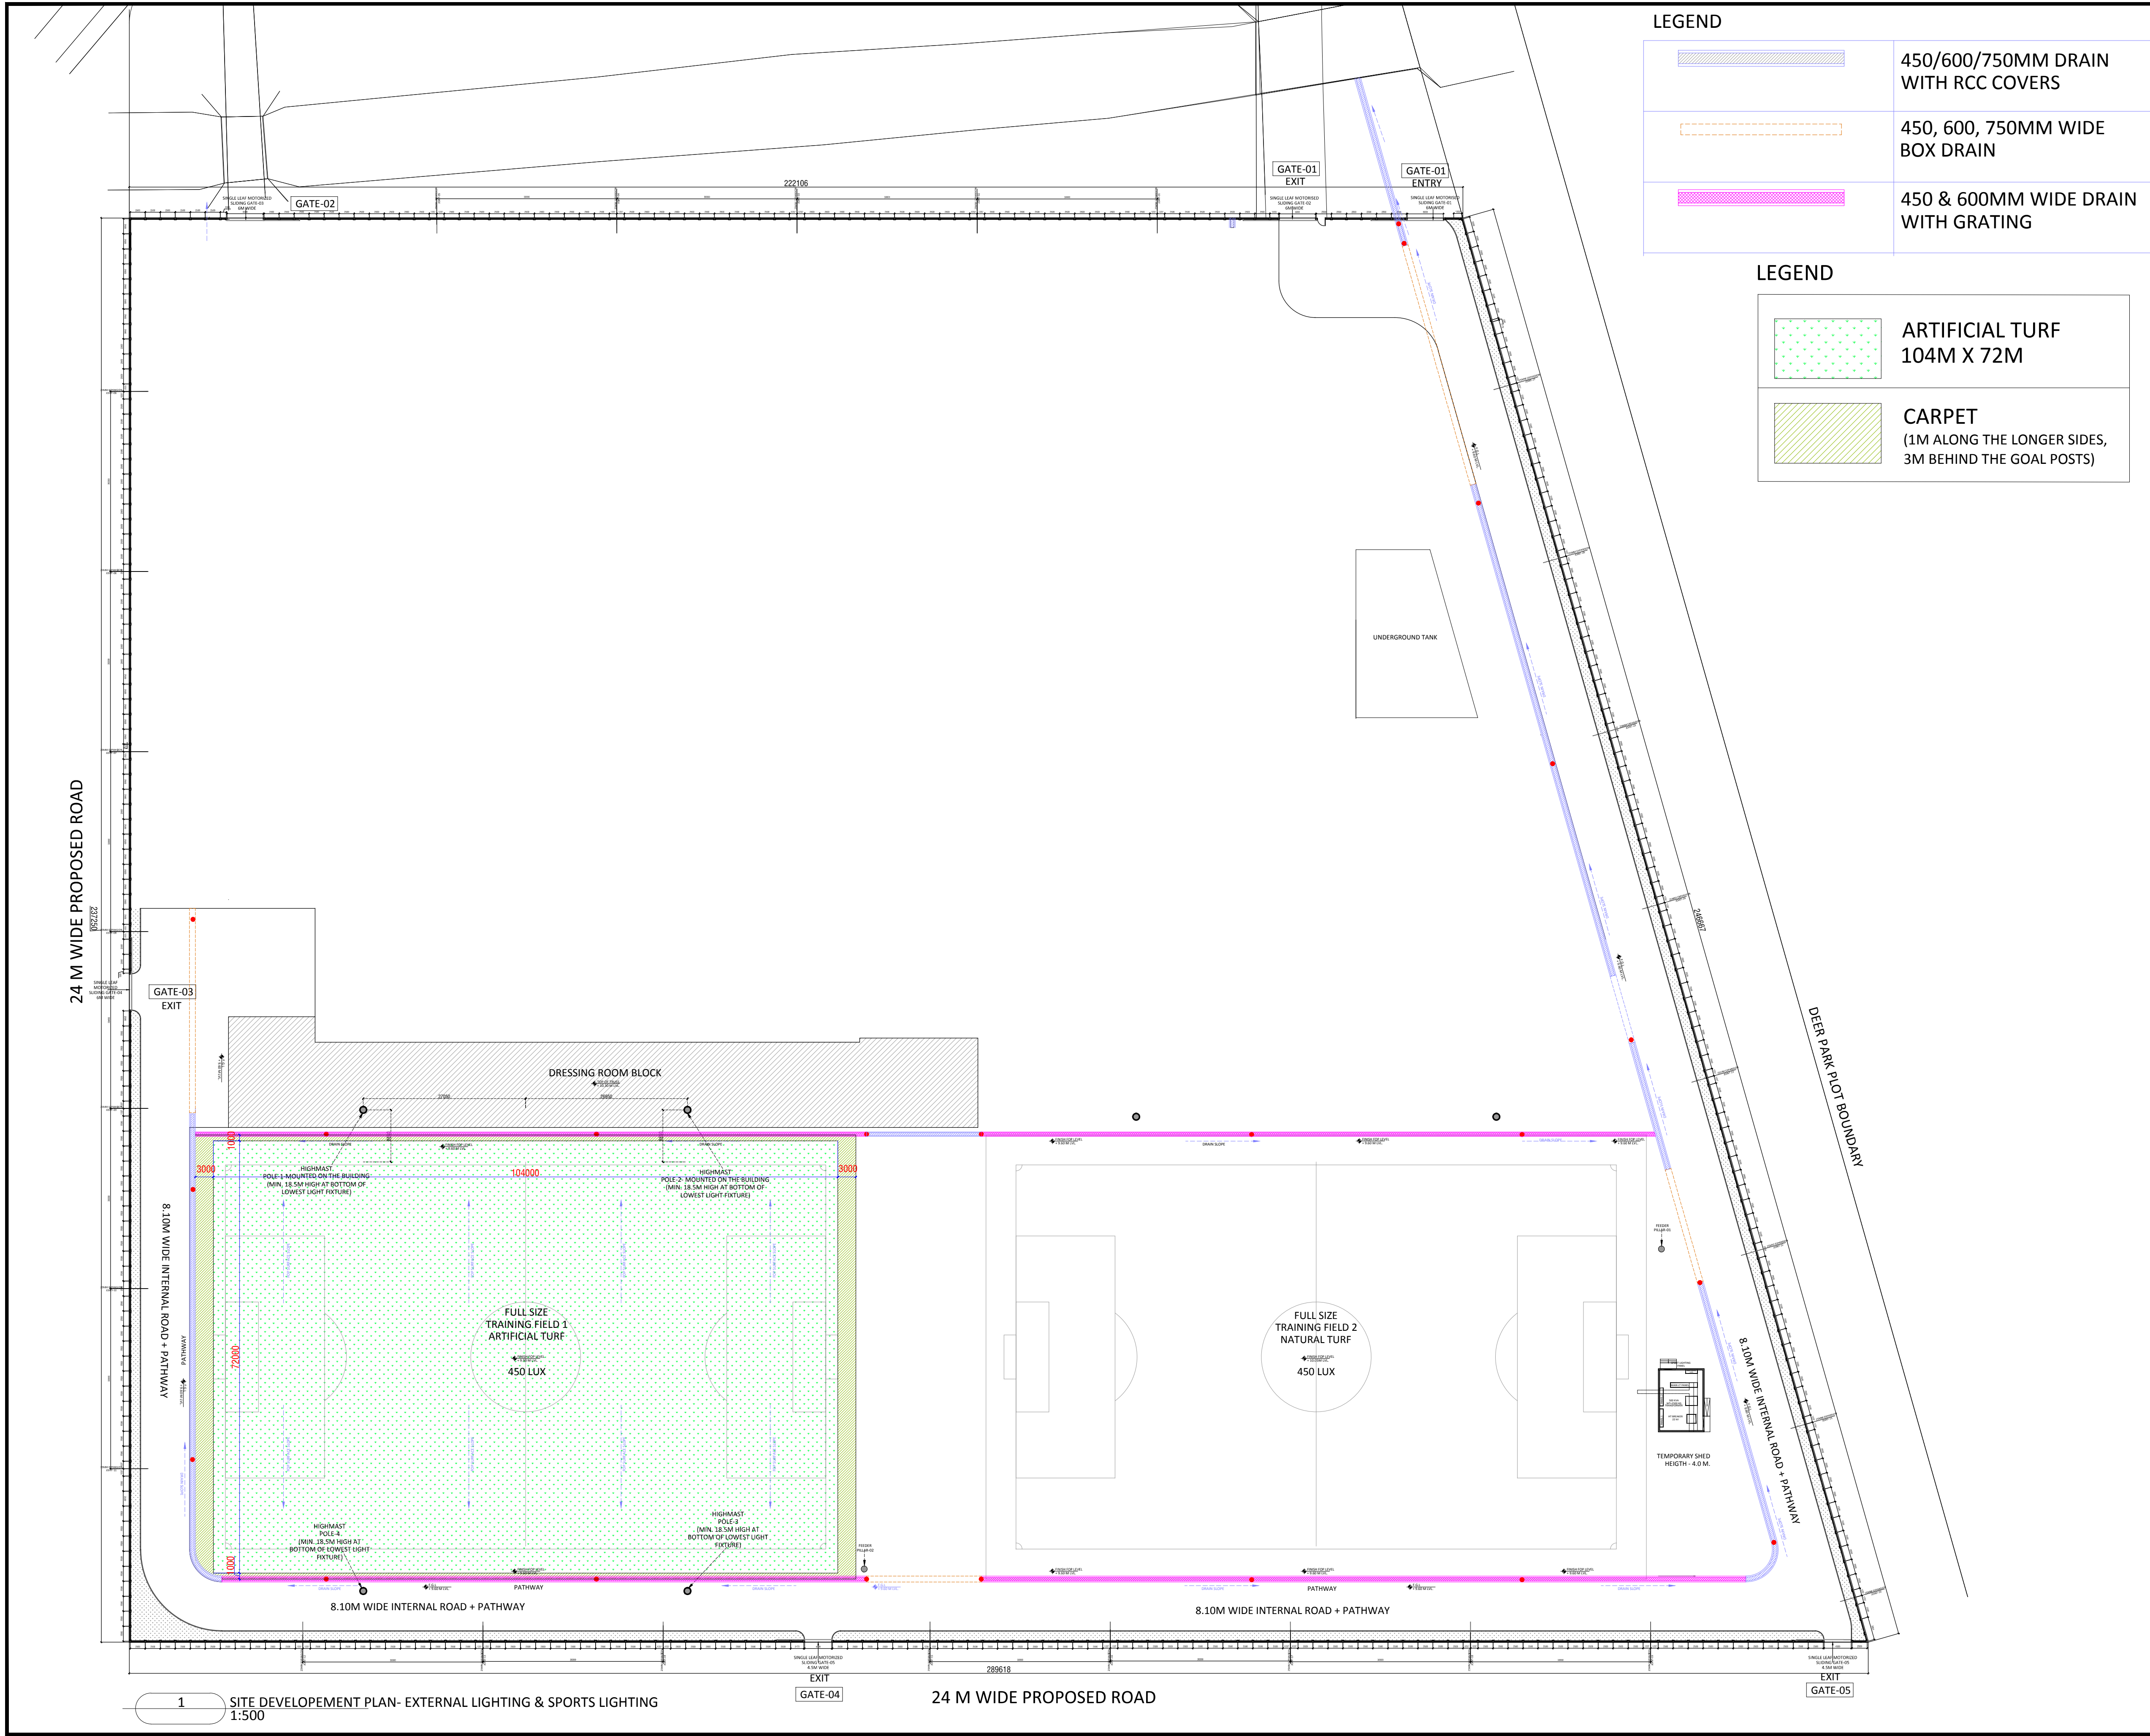

LEGEND

	450/600/750MM DRAIN WITH RCC COVERS
	450, 600, 750MM WIDE BOX DRAIN
	450 & 600MM WIDE DRAIN WITH GRATING

LEGEND

	ARTIFICIAL TURF 104M X 72M
	CARPET (1M ALONG THE LONGER SIDES, 3M BEHIND THE GOAL POSTS)

TENDER DRAWING

- GENERAL NOTES**
1. ALL DIMENSIONS ARE IN MILLIMETERS AND LEVELS ARE IN METER UNLESS OTHERWISE SPECIFIED.
 2. ALL DIMENSIONS ARE TO BE CHECKED AND CO-RELATED WITH THE RELEVANT ARCHITECTURAL, STRUCTURAL AND SERVICES DRAWINGS AND ANY AMBIGUITY, DISCREPANCY OR OMISSION SHALL BE BROUGHT IN TO NOTICE OF ARCHITECT PRIOR TO COMMENCEMENT OF EXECUTION.
 3. DO NOT SCALE THE DRAWING, WRITTEN DIMENSION TO BE FOLLOWED.
 4. THIS DRAWING TO BE READ IN CONJUNCTION WITH THE RELEVANT SERVICES AND STRUCTURAL DRAWINGS.

REV	DESCRIPTION	DATE

KEY PLAN

CLIENT

ALL INDIA FOOTBALL FEDERATION
Football House, Sector 19, Phase 1,
Dwarka, New Delhi: 110075
Tel- 91-11-25308200/ 201
Fax- 91-11-25308234/ 25308236
Email- aiff@the-aiff.com

ARCHITECT

collage design
ARCHITECTURE | INTERIORS | PMC
COLLAGE DESIGN PVT. LTD
300, Sai Sampanna, Station Rd
Vikhroli East, Mumbai 400 083
+91 22 2574 0842 / 43 / 44 / 45
www.collagedesign.net

STRUCTURAL CONSULTANT

SACPL
Shanghi and Associates
Consultants Pvt.Ltd.
7th Floor, Padmavati Heights,
Shradhdhanand Road, Vile Parle (E),
Mumbai - 400057.
Tel - +91 22 2614 4832, Fax - +91
22 2617 1804

PROJECT

NATIONAL CENTRE OF EXCELLENCE
IN FOOTBALL @ RAJRAHAT, KOLKATA

DRAWING TITLE

TRAINING FIELD 1-
ARTIFICIAL TURF

DWG. NO.	REV. NO.
TD-A.0.03.B	R0
PROJECT NO.	18-P245
SCALE	1:500
1 st ISSUED ON	17-07-2019
APPROVED	RS
CHECKED BY	
DRAWN BY	BD